

KiliManjaro 2.0


(Montevina DDR3)


Pre-MV Build 2008.06.19


DATE	CHANGE NO.	REV




DRAWER	EE	DATE	POWER	DATE	INVENTEC		
DESIGN					TITLE		
CHECK					KiliManjaro 2.0(Montevina)		
RESPONSIBLE							
SIZE = 3					SIZE	CODE	DOC. NUMBER
FILE NAME : XXXX-XXXXXX-XX					A3	CS	1310A2207301-0-M
P/N XXXXXXXXXXXX					REV		
					SHEET 1 OF 58		

	1	2	3	4	5	6	7	8	
A	TABLE OF CONTENTS								A
B	PAGE		PAGE		PAGE				B
	MAINBOARD				SMALL BOARD				
	1.COVER PAGE		39.CARD READER		53.IO BOARD(TV Tuner or Robson)				
	2.INDEX		40.LAN CONTROLLER		54. USB & TV BOARD				
	3.BLOCK DIAGRAM		41.RJ45 & TRANSFORMER		55. PWR JACK LED BOARD				
C	4.POWER SEQUENCE BLOCK		42.MINI CARD CONN		56. PWR BUTTON & LID BOARD				C
	5-12.SYSTEM POWER		43.ODD & HDD CONN		57.E-KEY BOARD				
	13.CLOCK GENERATOR		44.USB CONN/ESATA		58.TH-BUTTON BOARD				
	14-17.CPU Penryn		45.BT & LED & CIR & SW		59.HOTKEY BOARD				
	18.FAN & THERMAL CONTROLLER		46.KBC						
	19-25.N/B Cantiga		47.CODEC						
D	26.DDR2 DIMM0		48-49.AUDIO AMP&JACK						D
	27.DDR2 DIMM1		50.MDC						
	28.DDR DAMPING		51.SCREW & EMI						
	29.MXM CONN		52.TO OTHER BOARD CONN						
	30.CRT CONN								
	31.HDMI CONN								
E	32.LCD CONN								E
	33-37.S/B ICH9								
	38.EXPRESS CARD								
F									F
CHANGE by						Docver Name		6-Jun-2008	
SIZE						CODE		DOC. NUMBER	REV
A3						CS		1310A2207301-0-M	202
						SHEET		2	OF 58
	1	2	3	4	5	6	7	8	

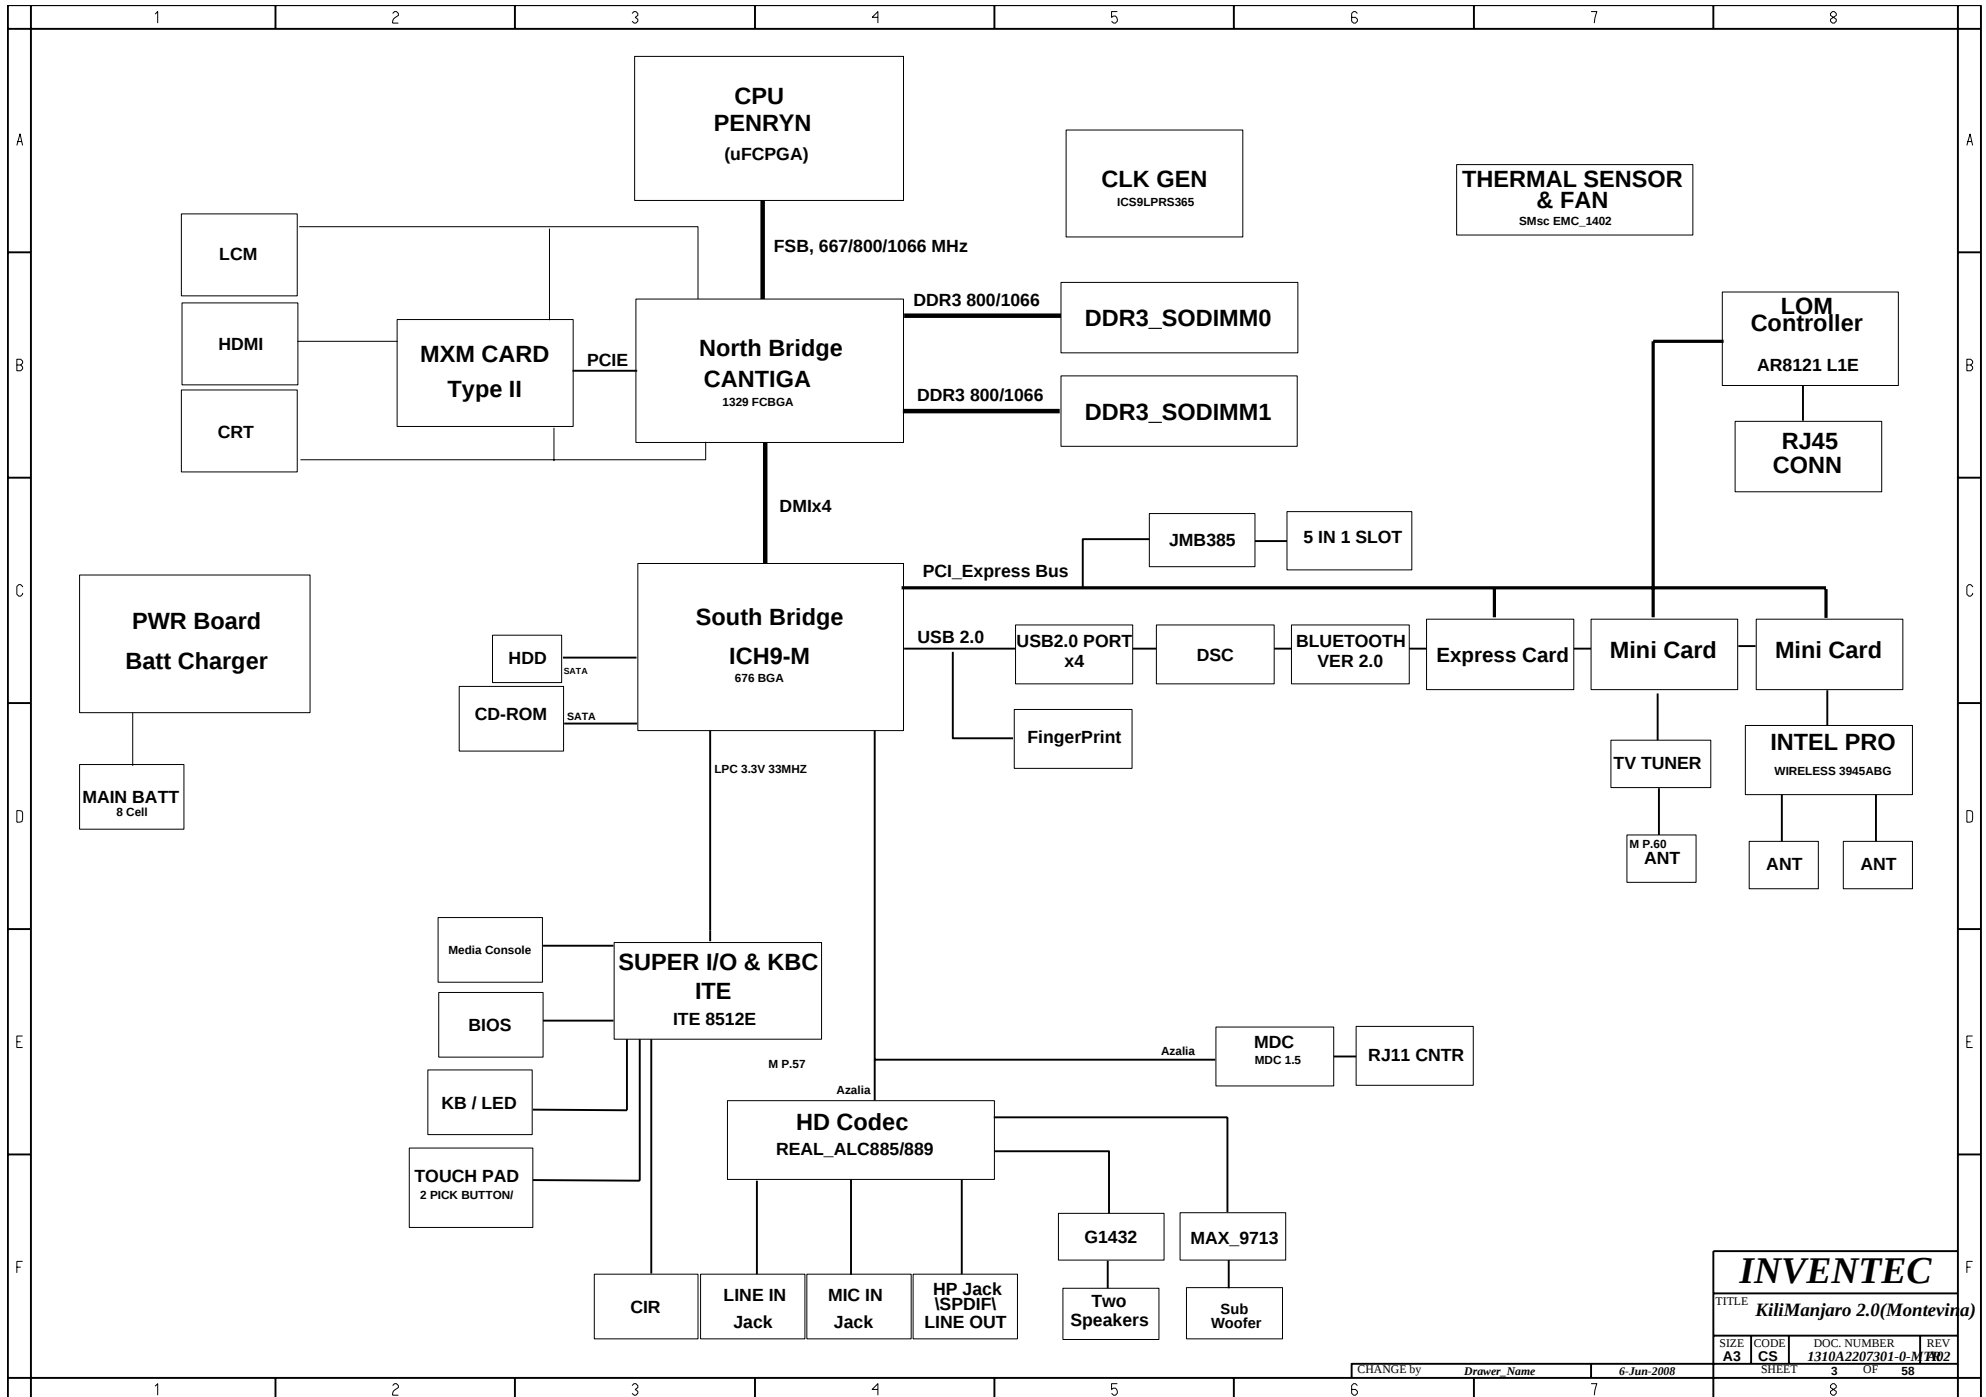


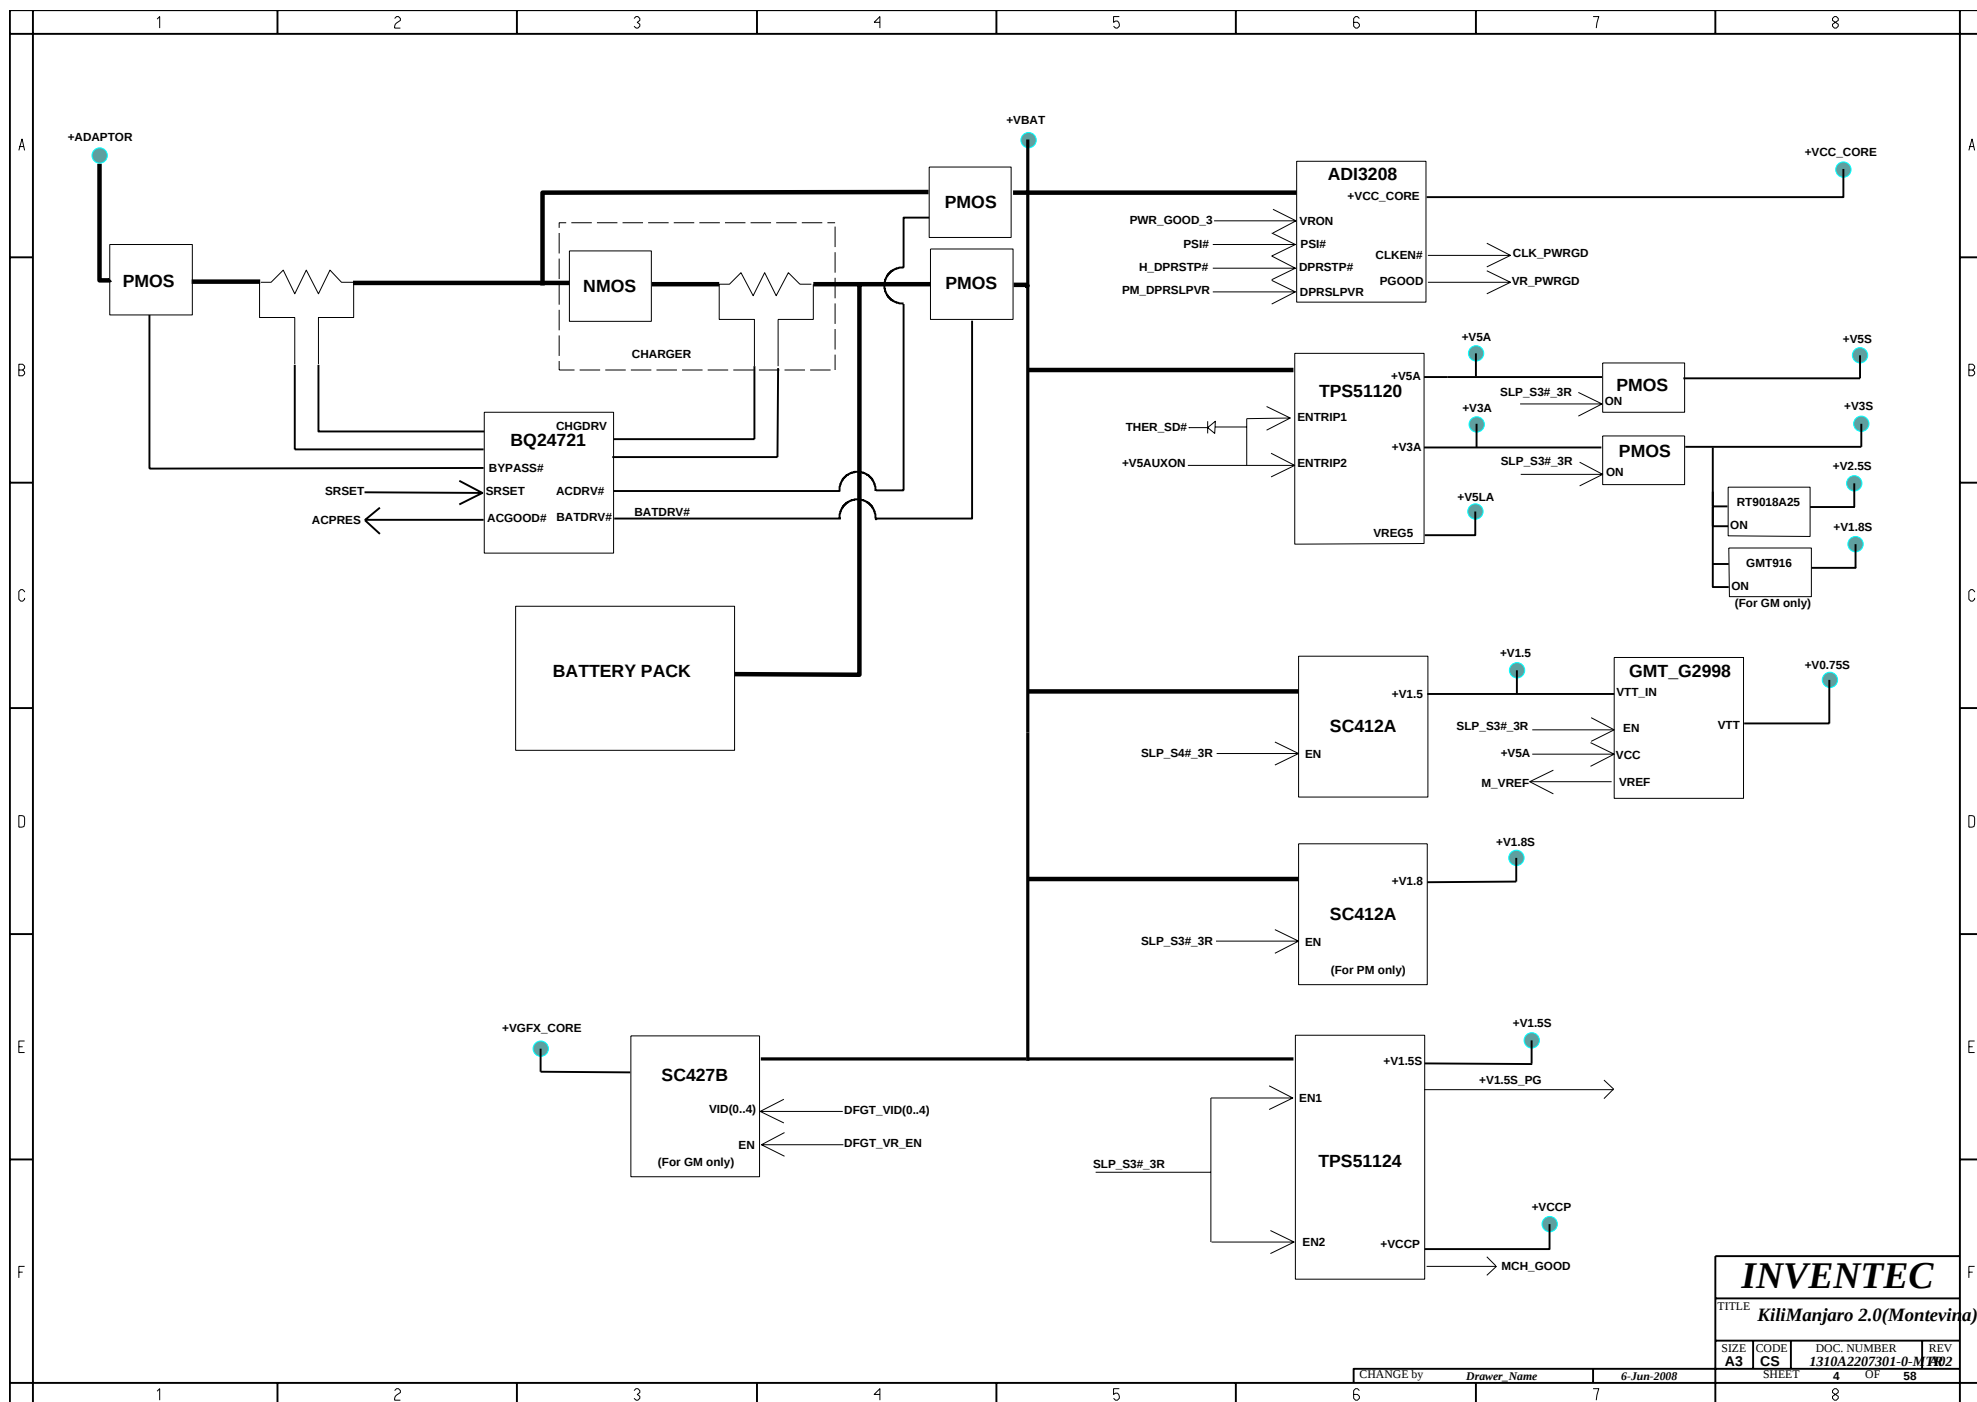

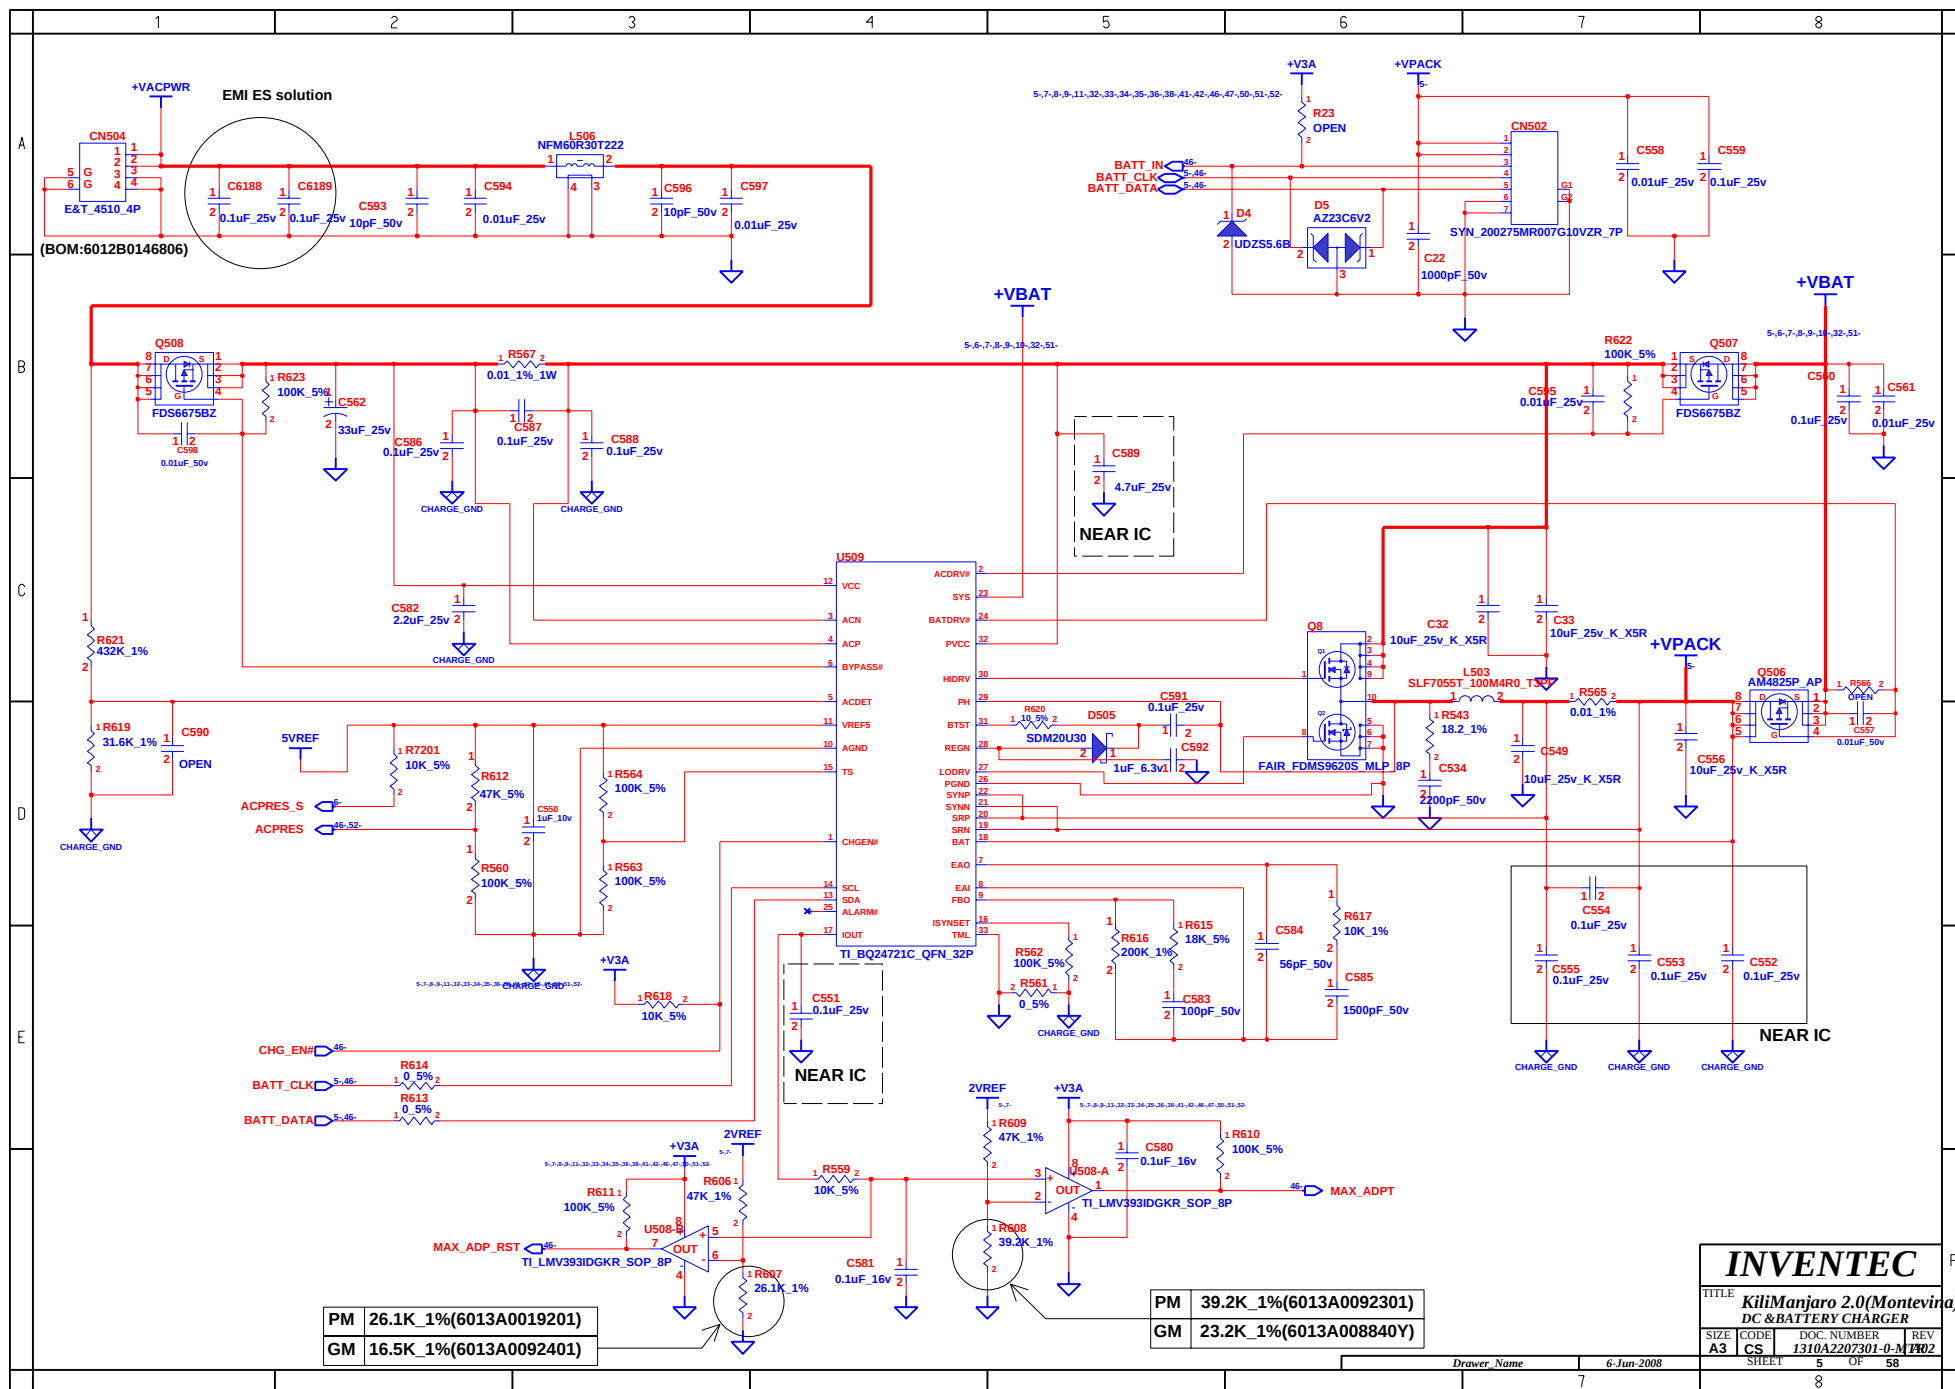


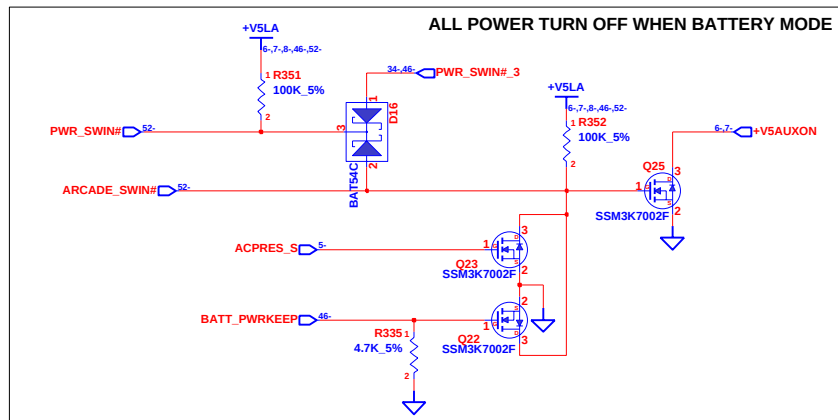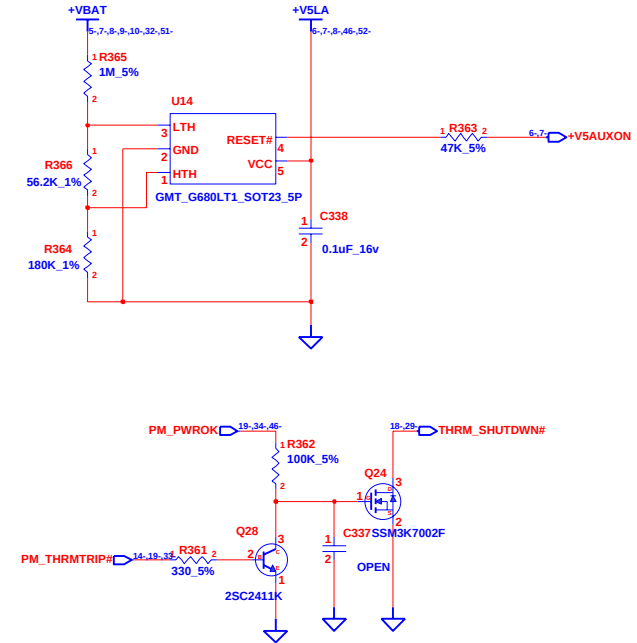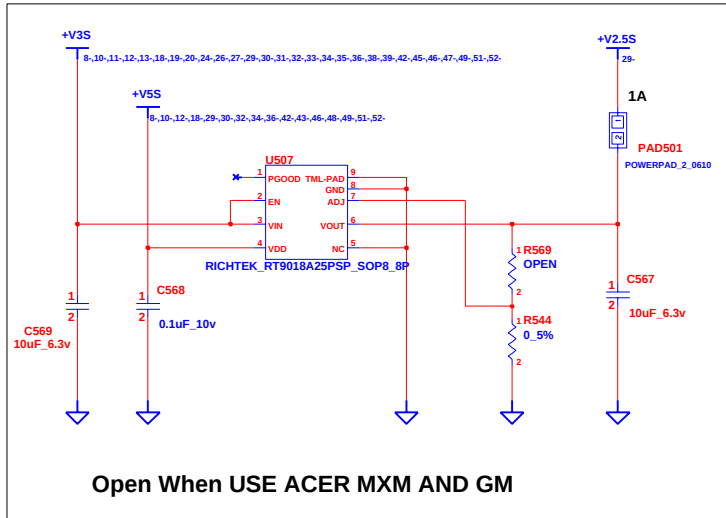


INVENTEC			
TITLE			
KiliManjaro 2.0(Montevina)			
+V2.5S / RESET			
SIZE	CODE	DOC. NUMBER	REV
A3	CS	1310A2207301-0-M	02
CHANGE by		Drawer Name	6-Jun-2008
SHEET		6	OF 58

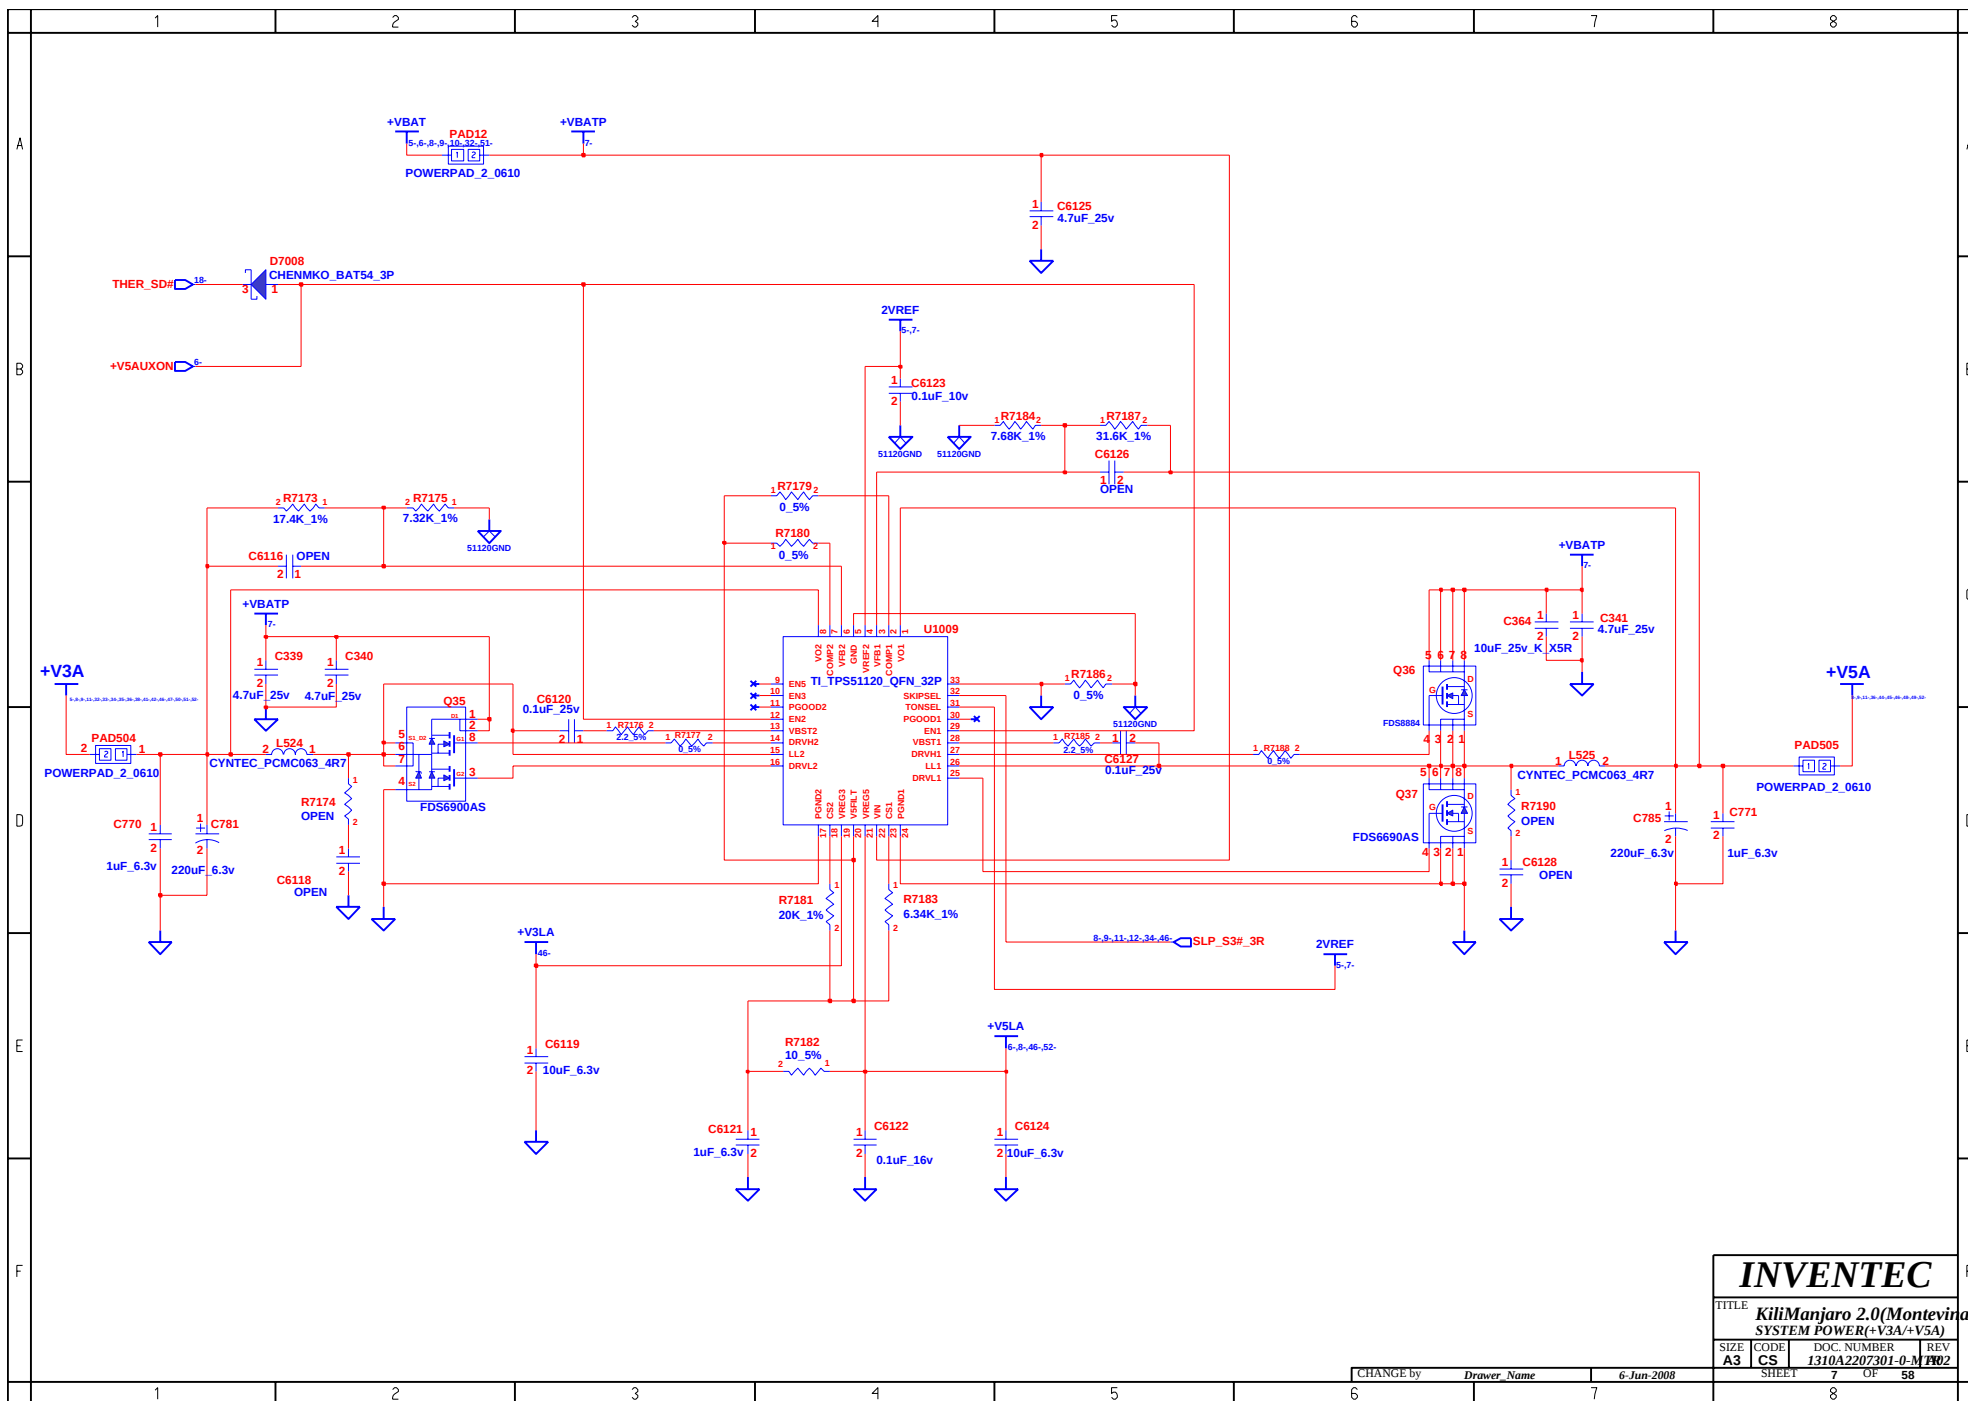


INVENTEC			
TITLE KiliManjaro 2.0(Montevina) SYSTEM POWER(+V3A/+V5A)			
SIZE A3	CODE CS	DOC. NUMBER 1310A2207301-0-M	REV #02
SHEET 7		OF 58	



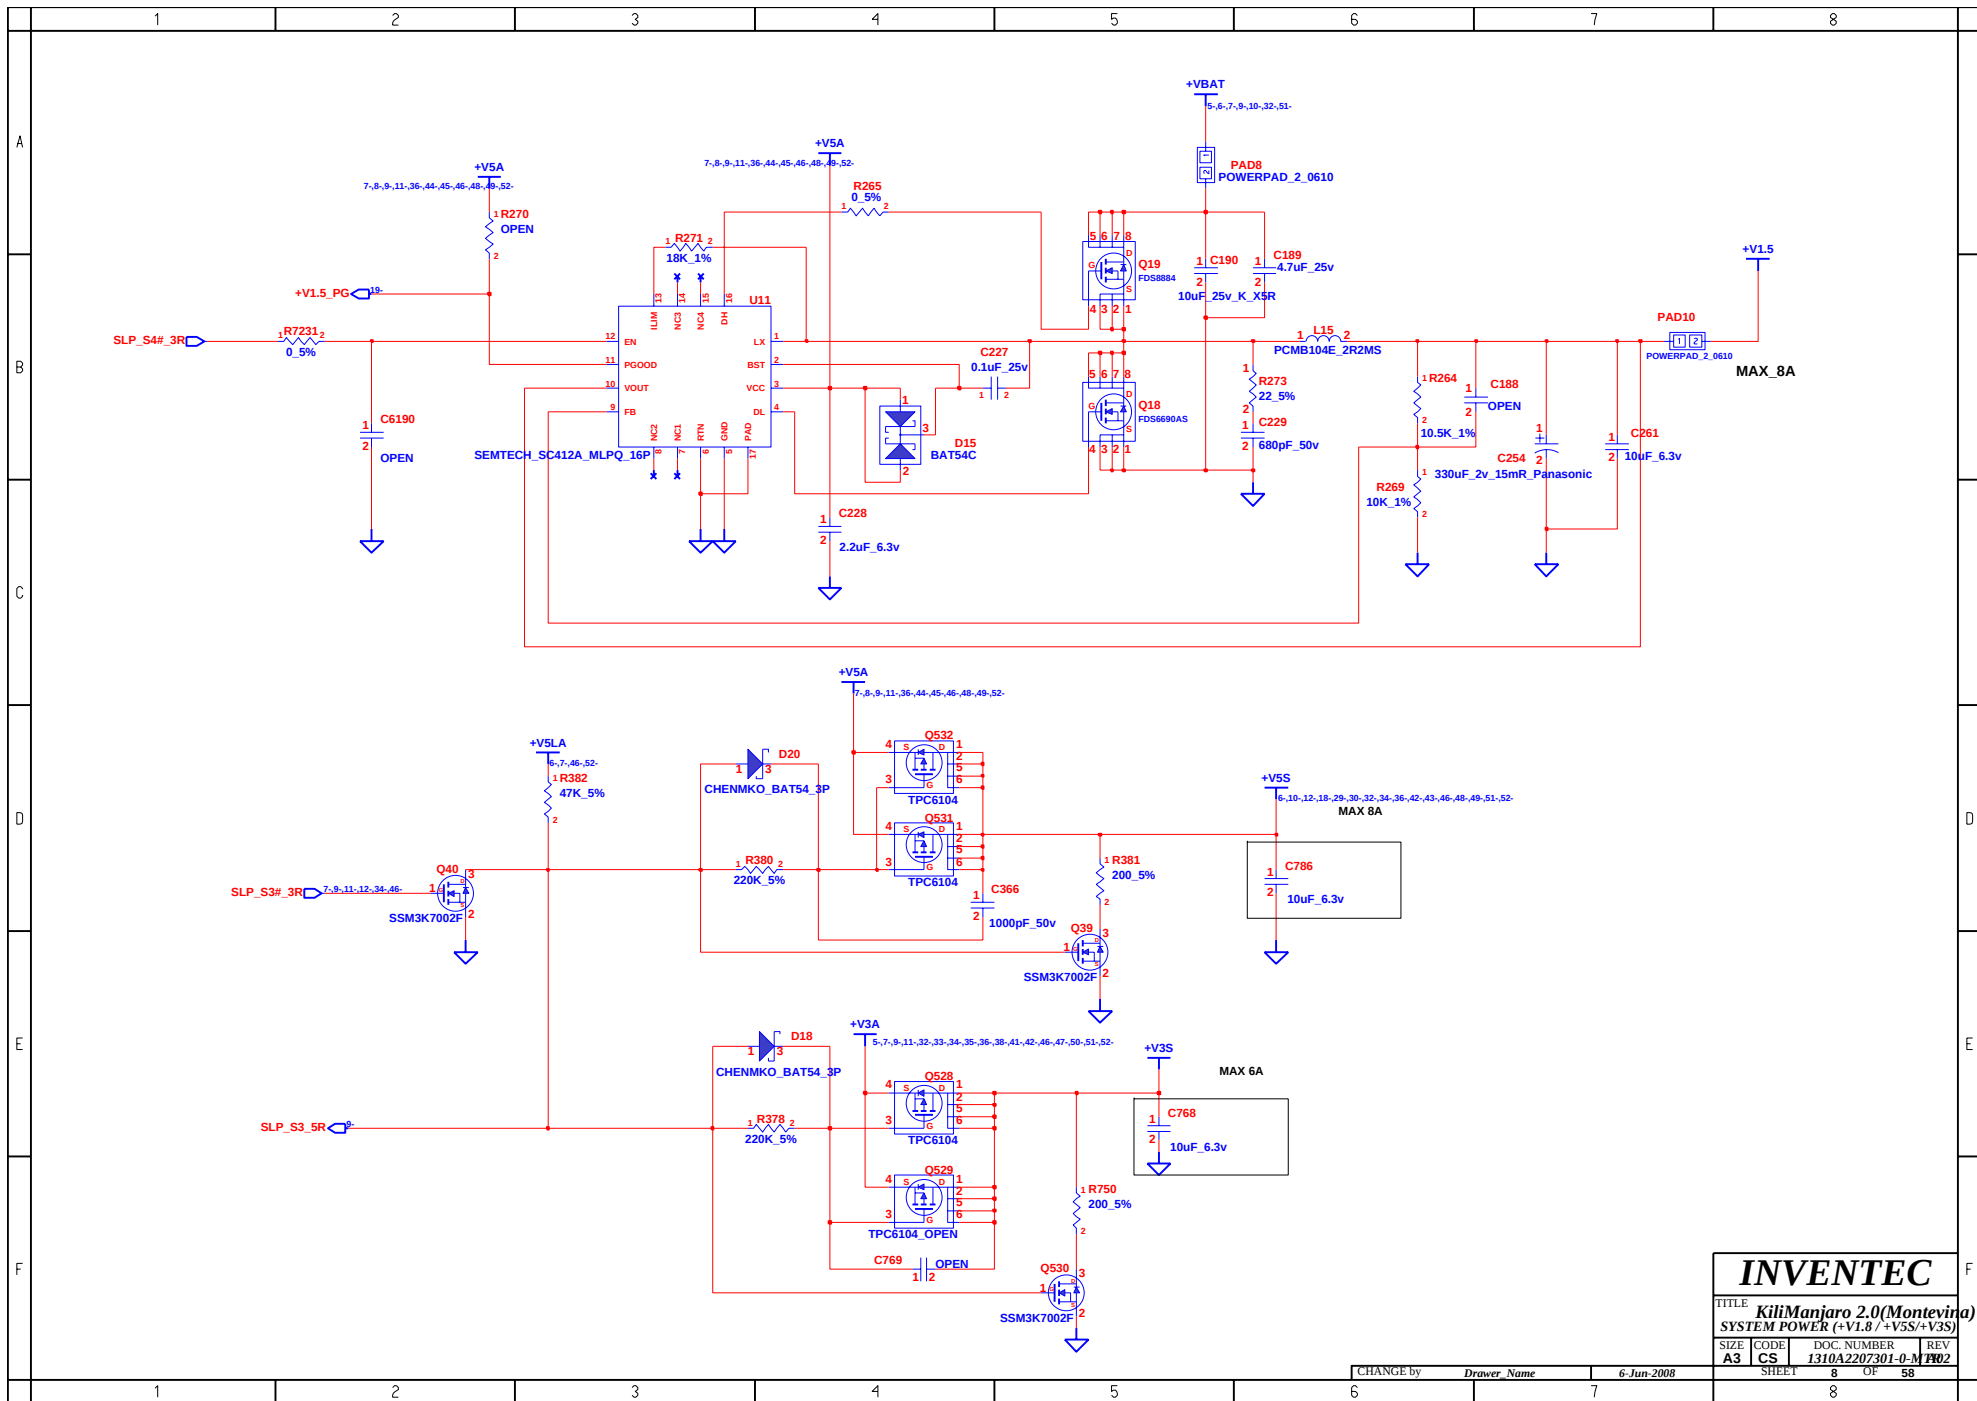


INVENTEC			
TITLE KiliManjaro 2.0(Montevina)			
SYSTEM POWER (+V1.8 / +VSS/+V3S)			
SIZE A3	CODE CS	DOC. NUMBER 1310A2207301-0-M	REV 02

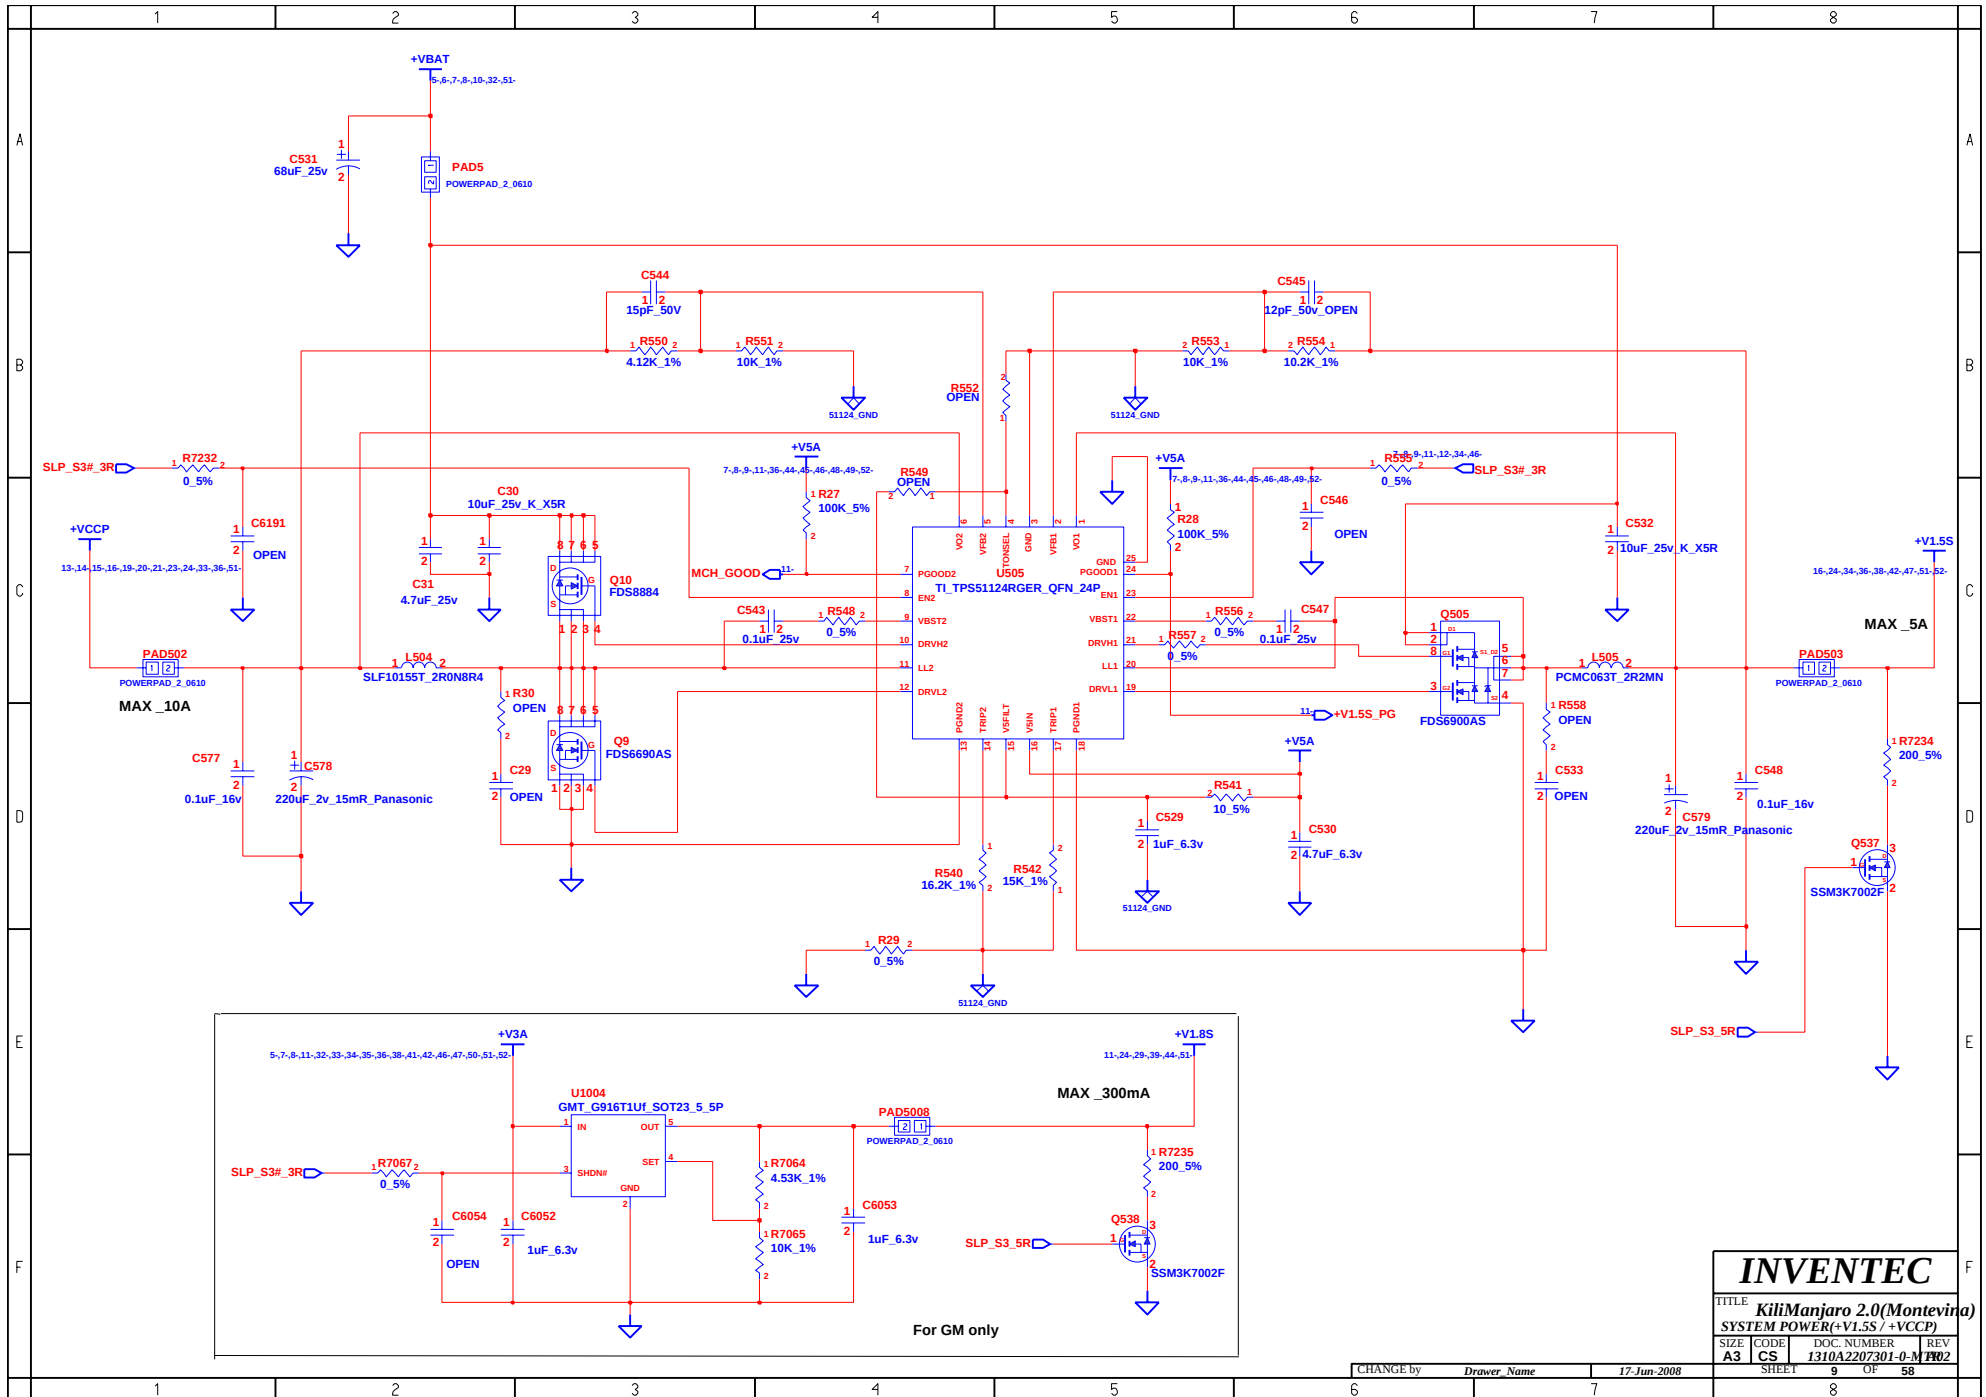

INVENTEC					F
TITLE					
KiliManjaro 2.0(Montevina)					
SYSTEM POWER(+V1.5S / +VCCP)					
SIZE	CODE	DOC. NUMBER	REV		
A3	CS	1310A2207301-0-M	02		
SHEET		9	OF	58	
8					

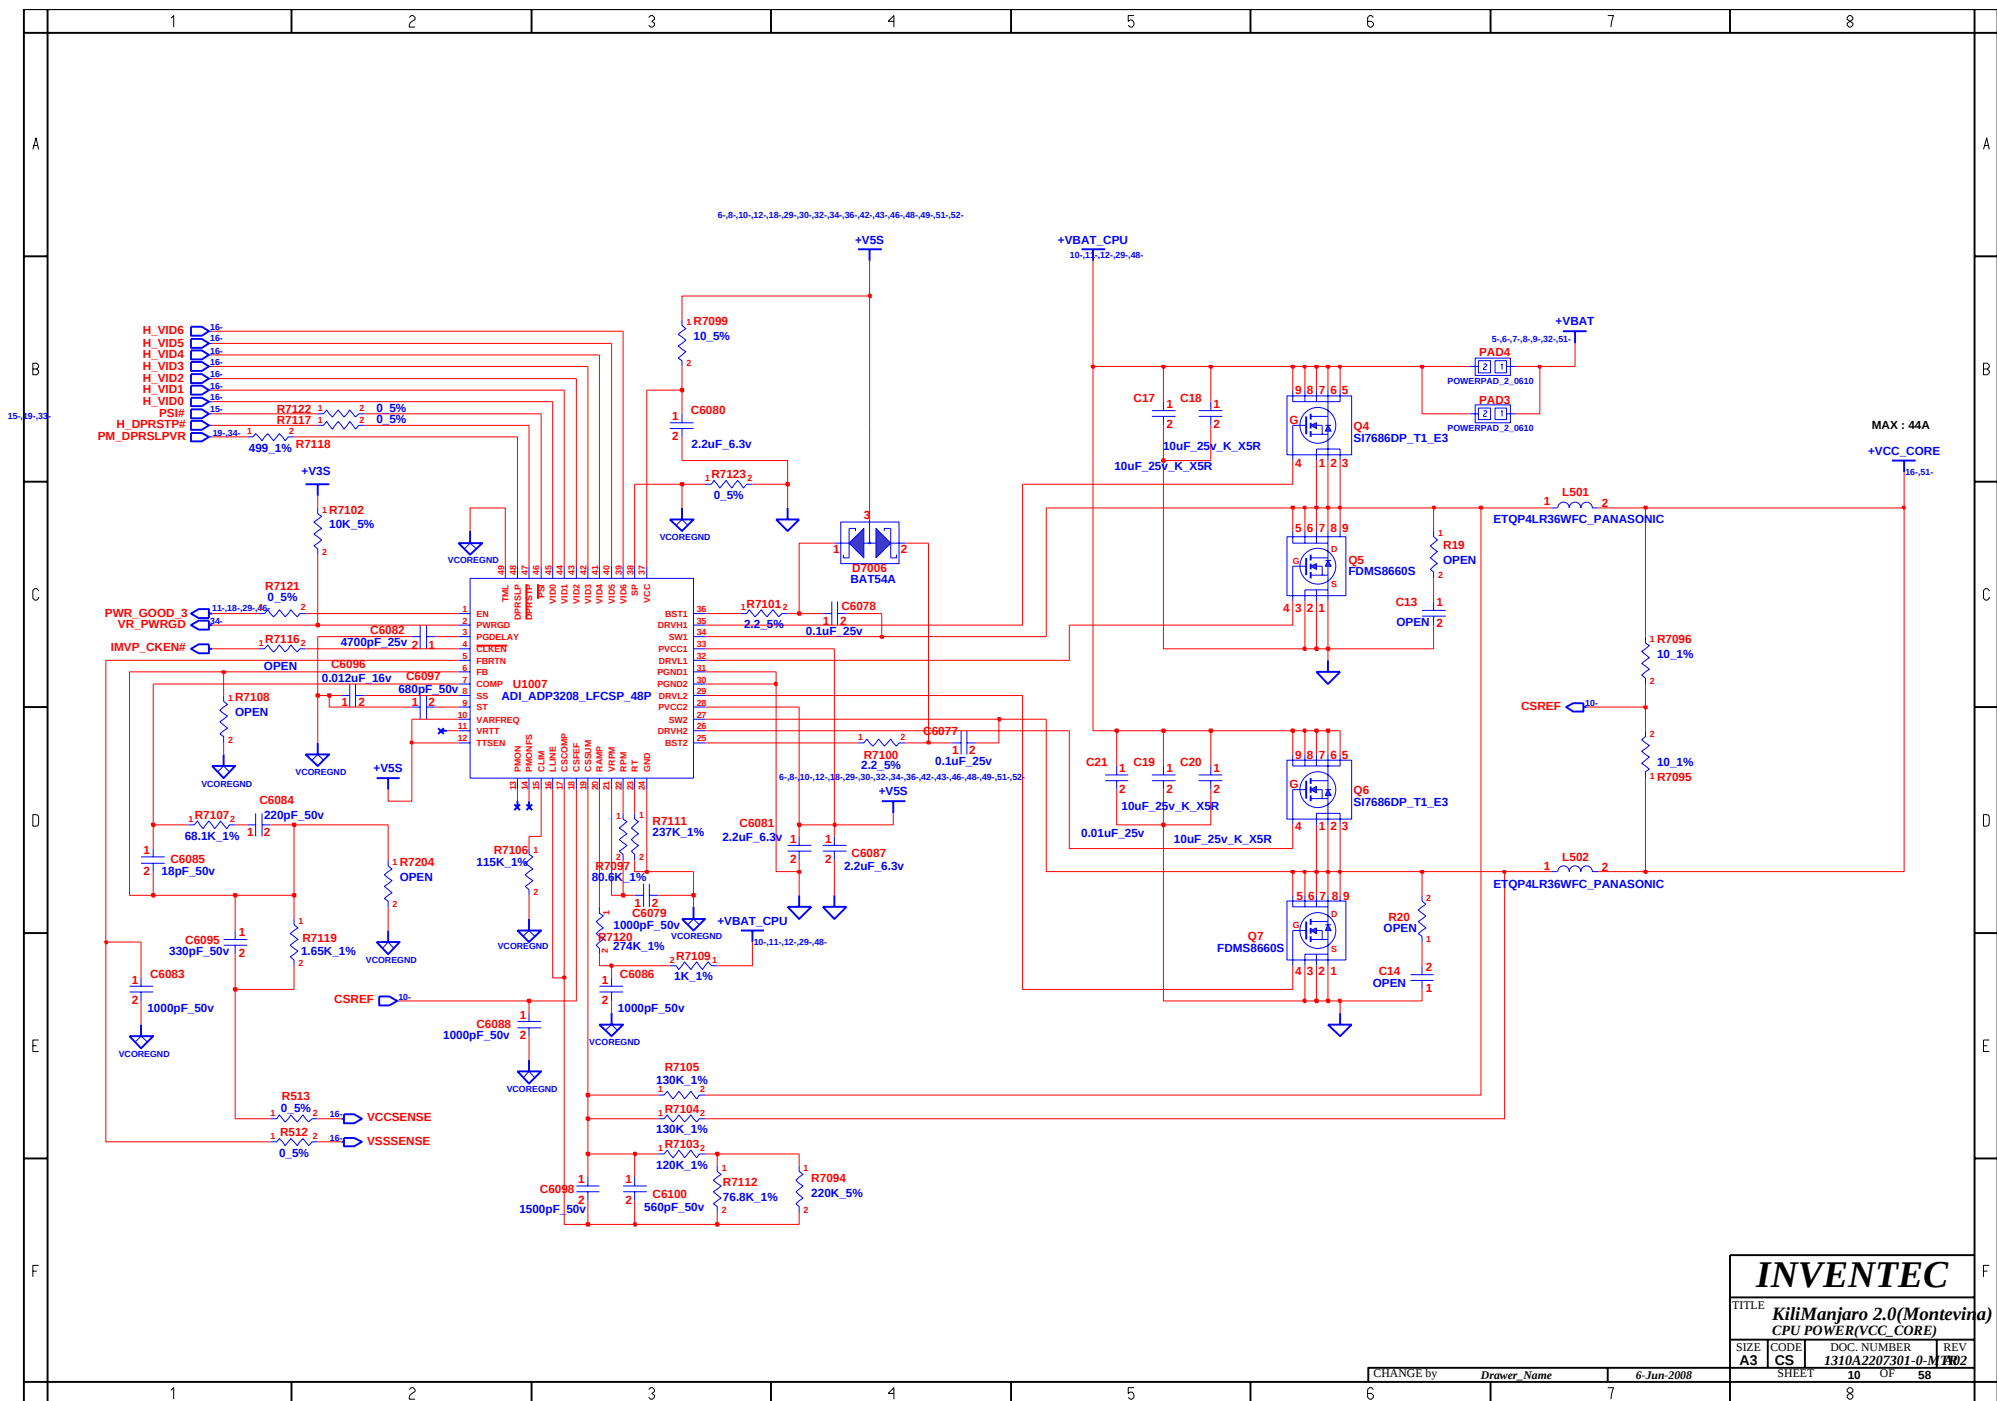

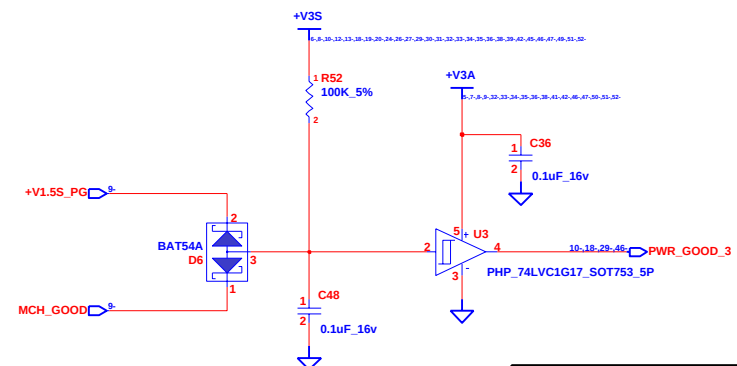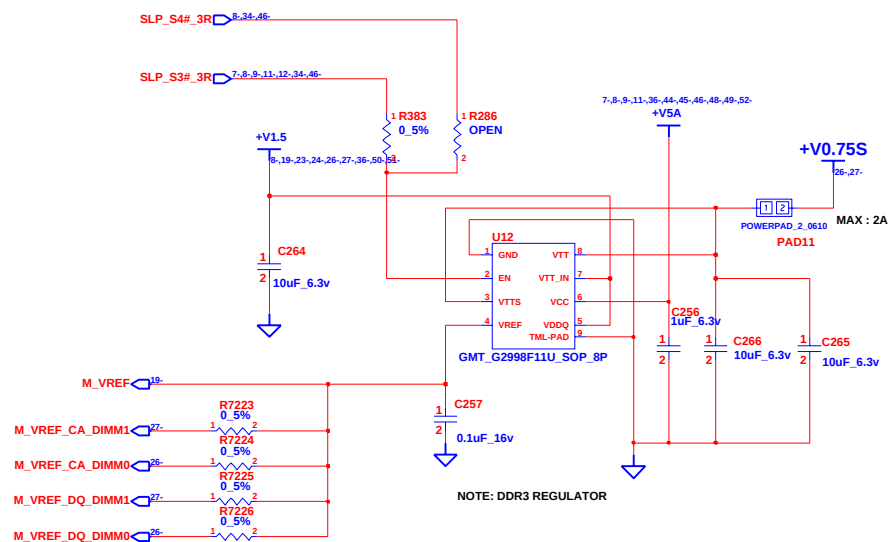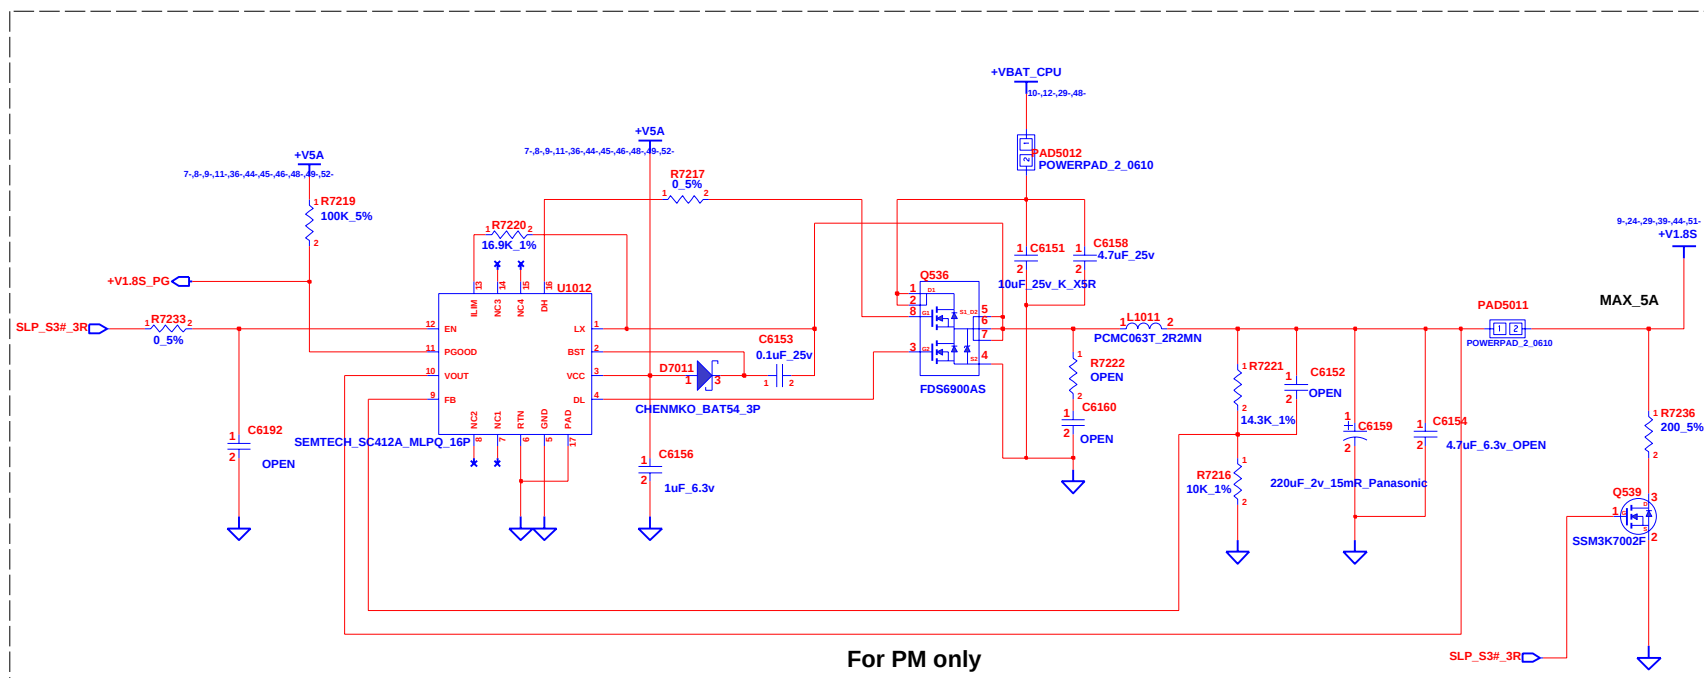

INVENTEC

TITLE	<i>KiliManjaro 2.0(Montevina)</i> +V0.9S / +V1.8S / POWER GOOD
-------	---


SIZE	CODE	DOC. NUMBER	REV.
------	------	-------------	------


SIZE	CODE	DOC. NUMBER	REV
A3	CS	1310A2207301-0-MTB2	


AS	CS	1310Azz07301-0-M	Hz
SHEET		11	OF 58

CHANGE by	<i>Drawer Name</i>	6-Jun-2008
-----------	--------------------	------------


CS	1310A2207301-0-
SHEET	11 OF 5

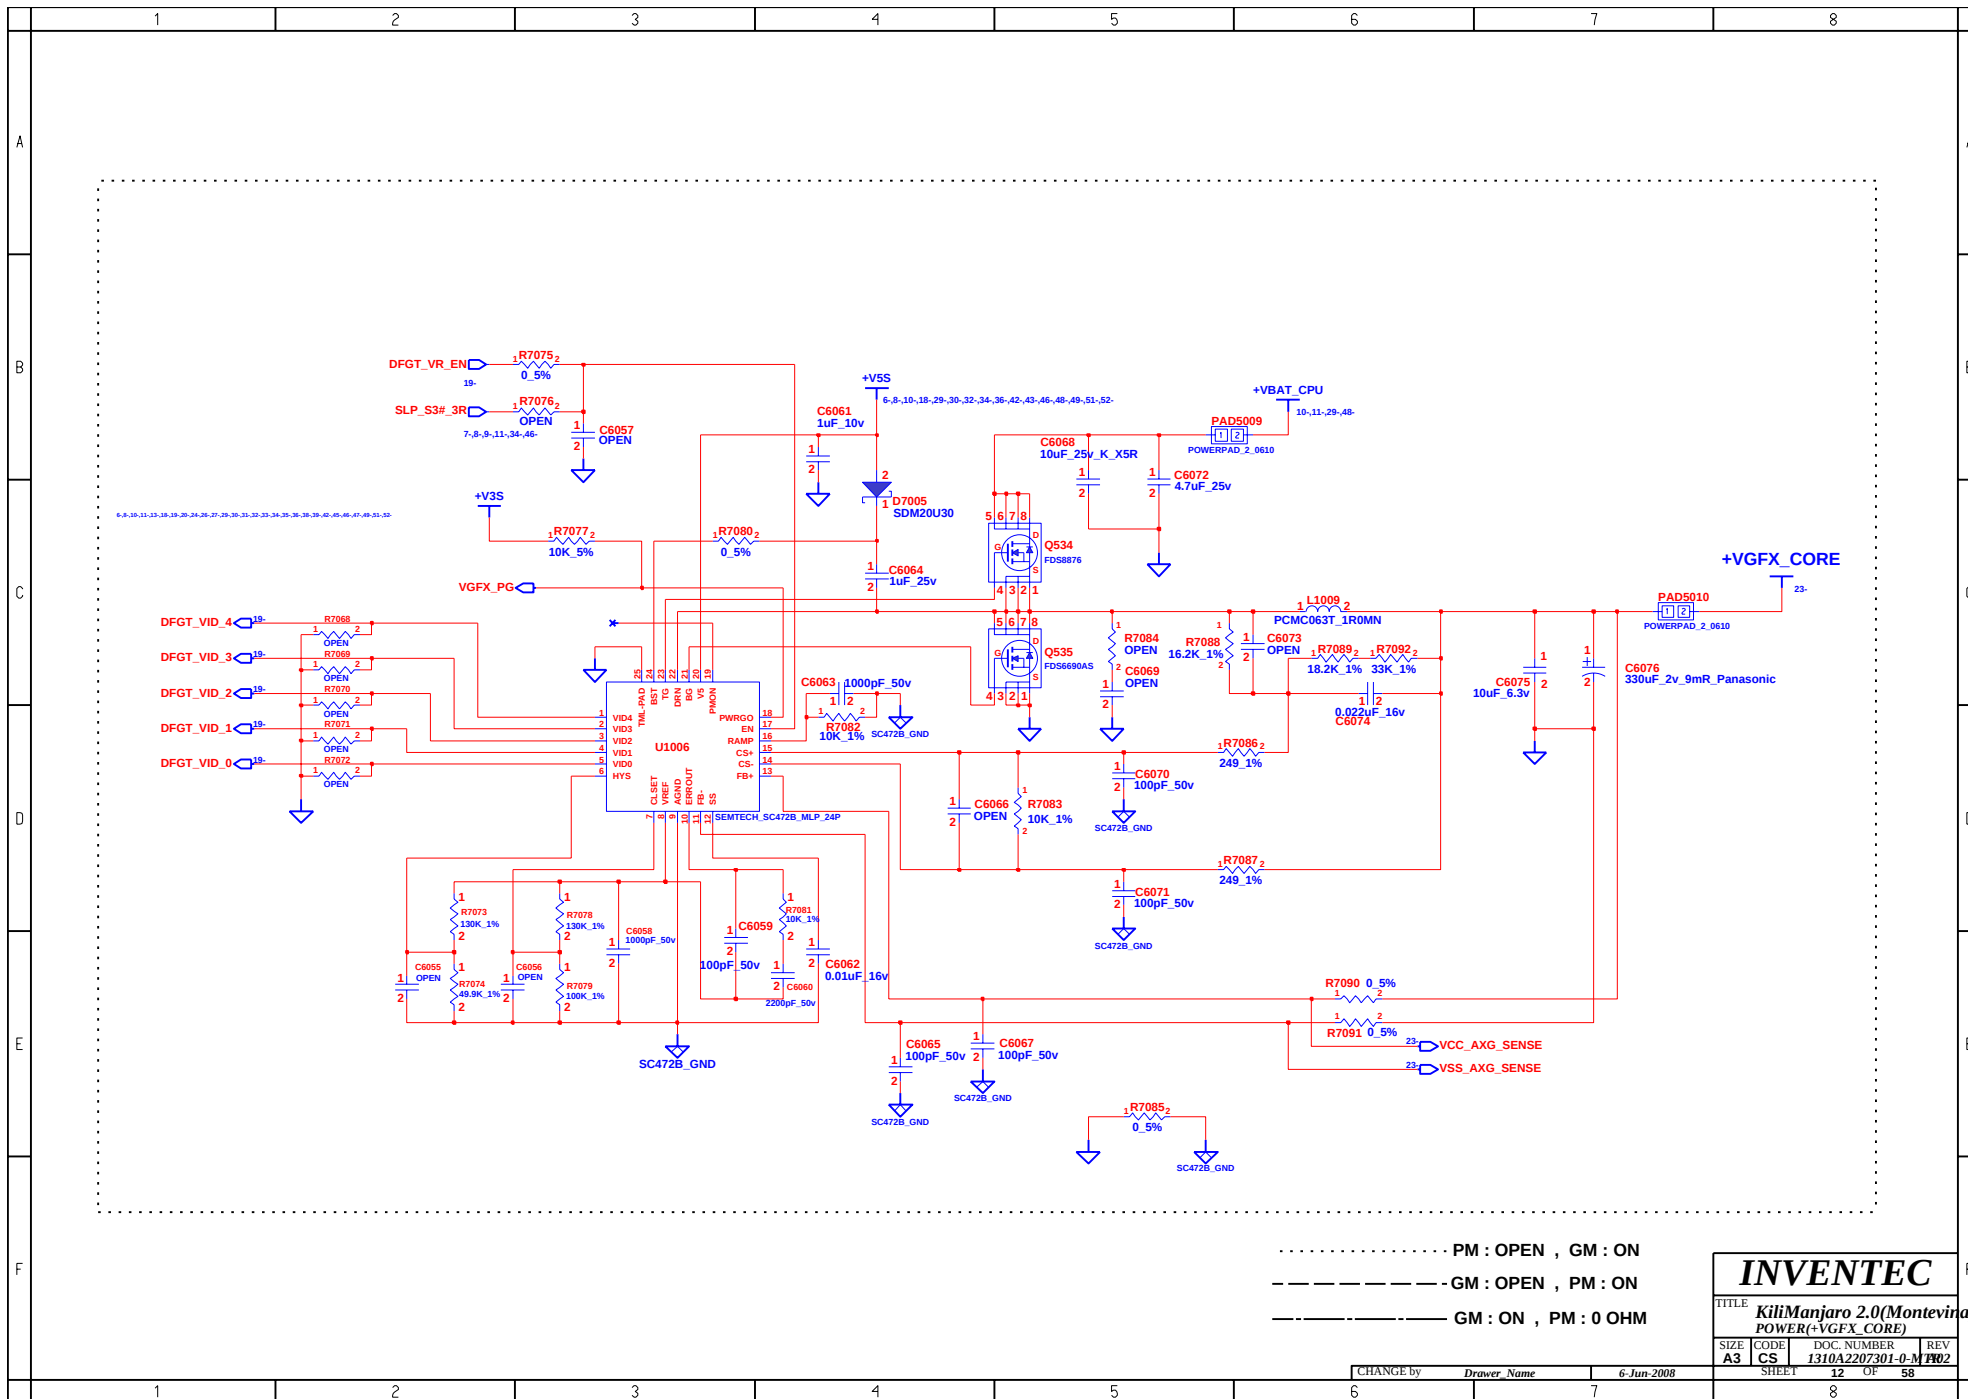

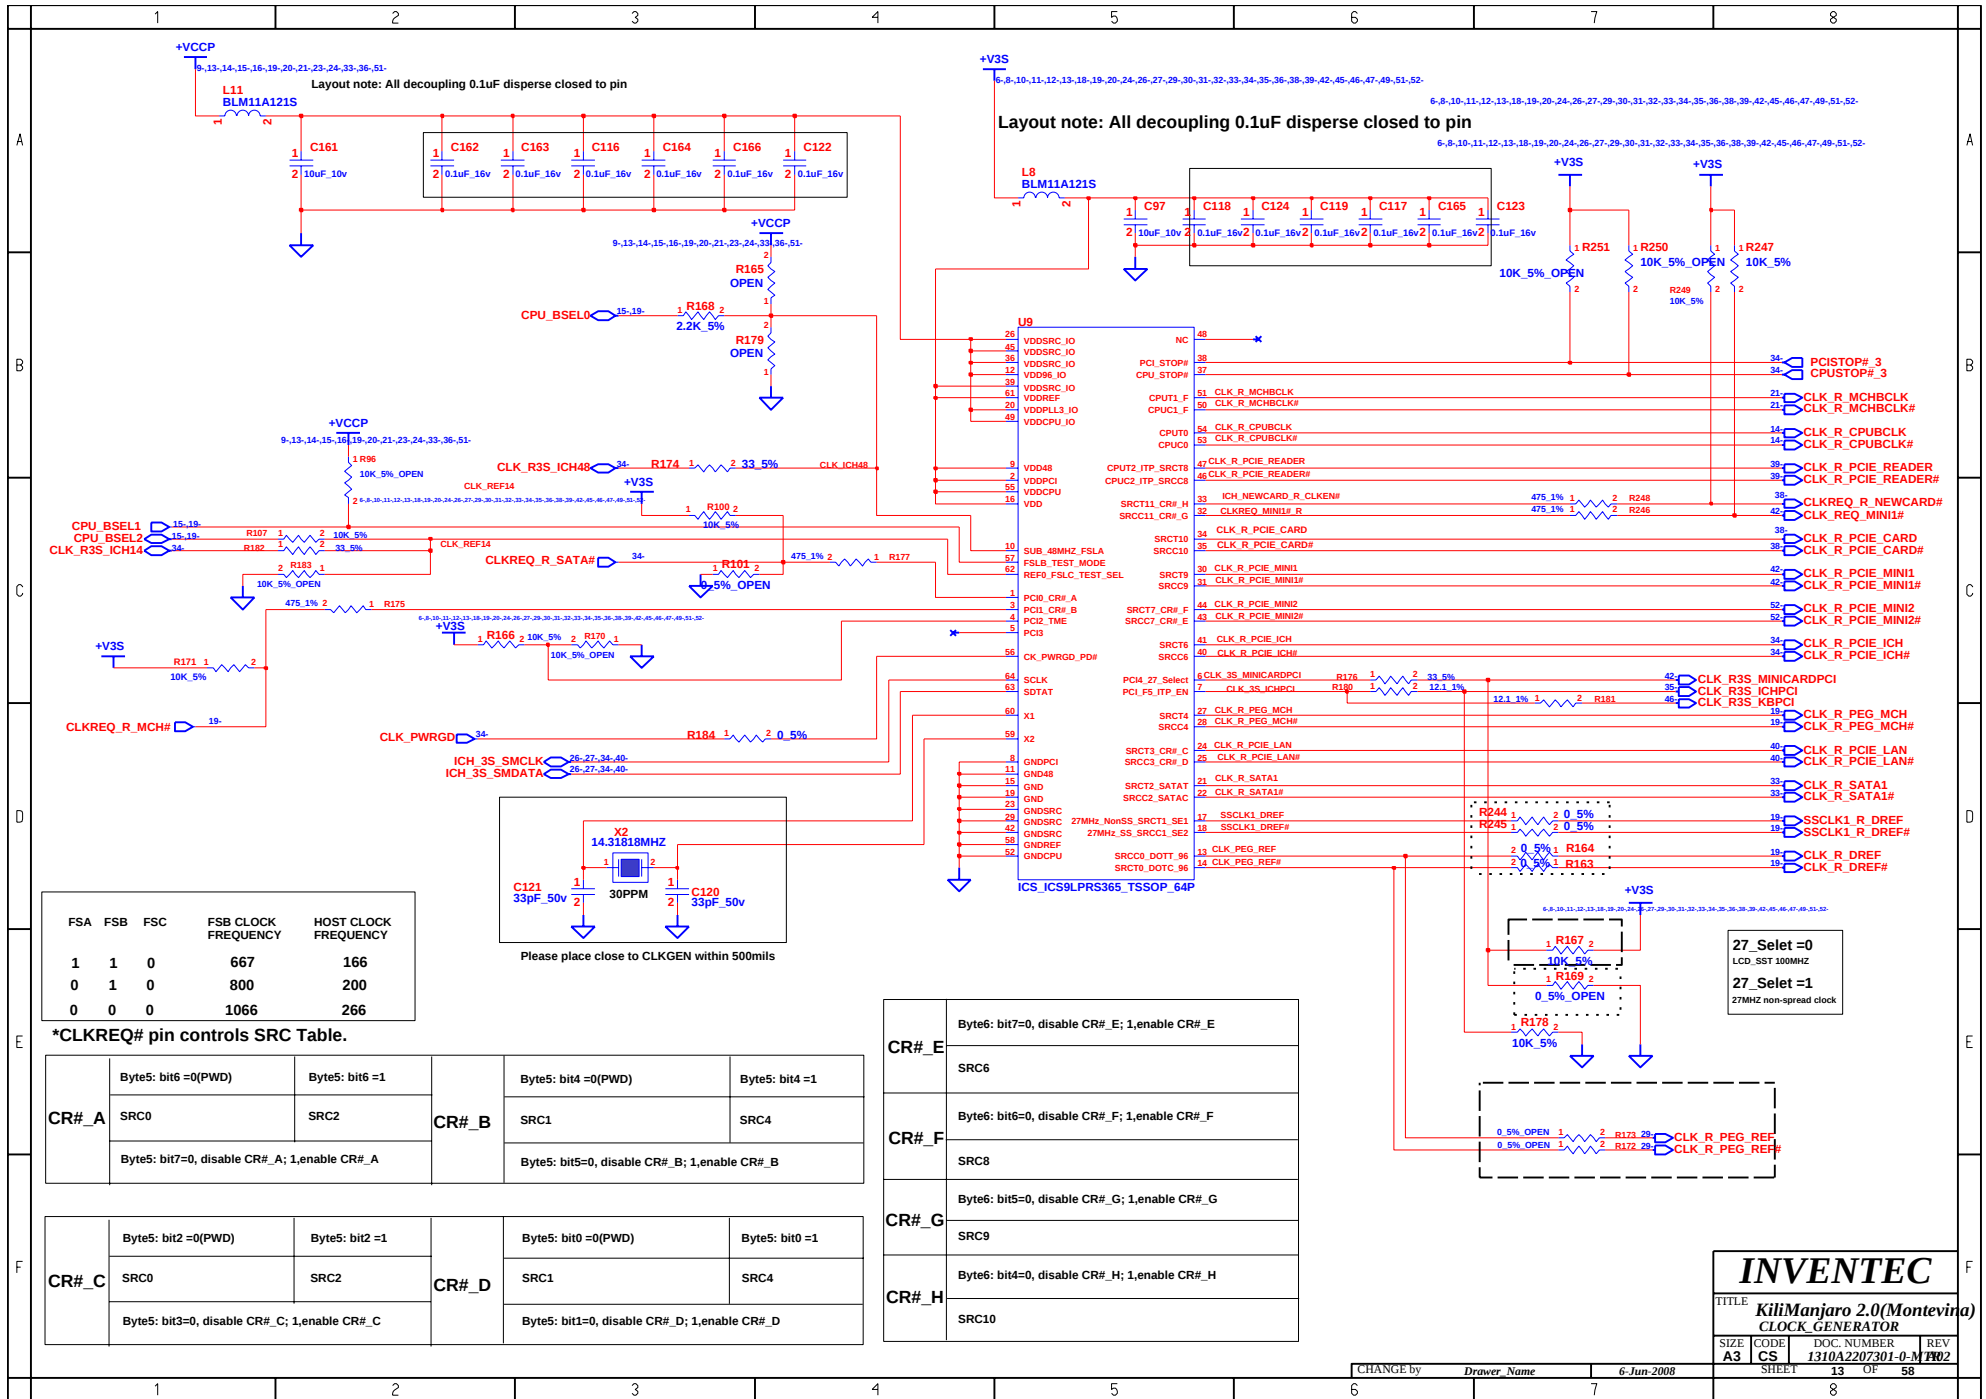

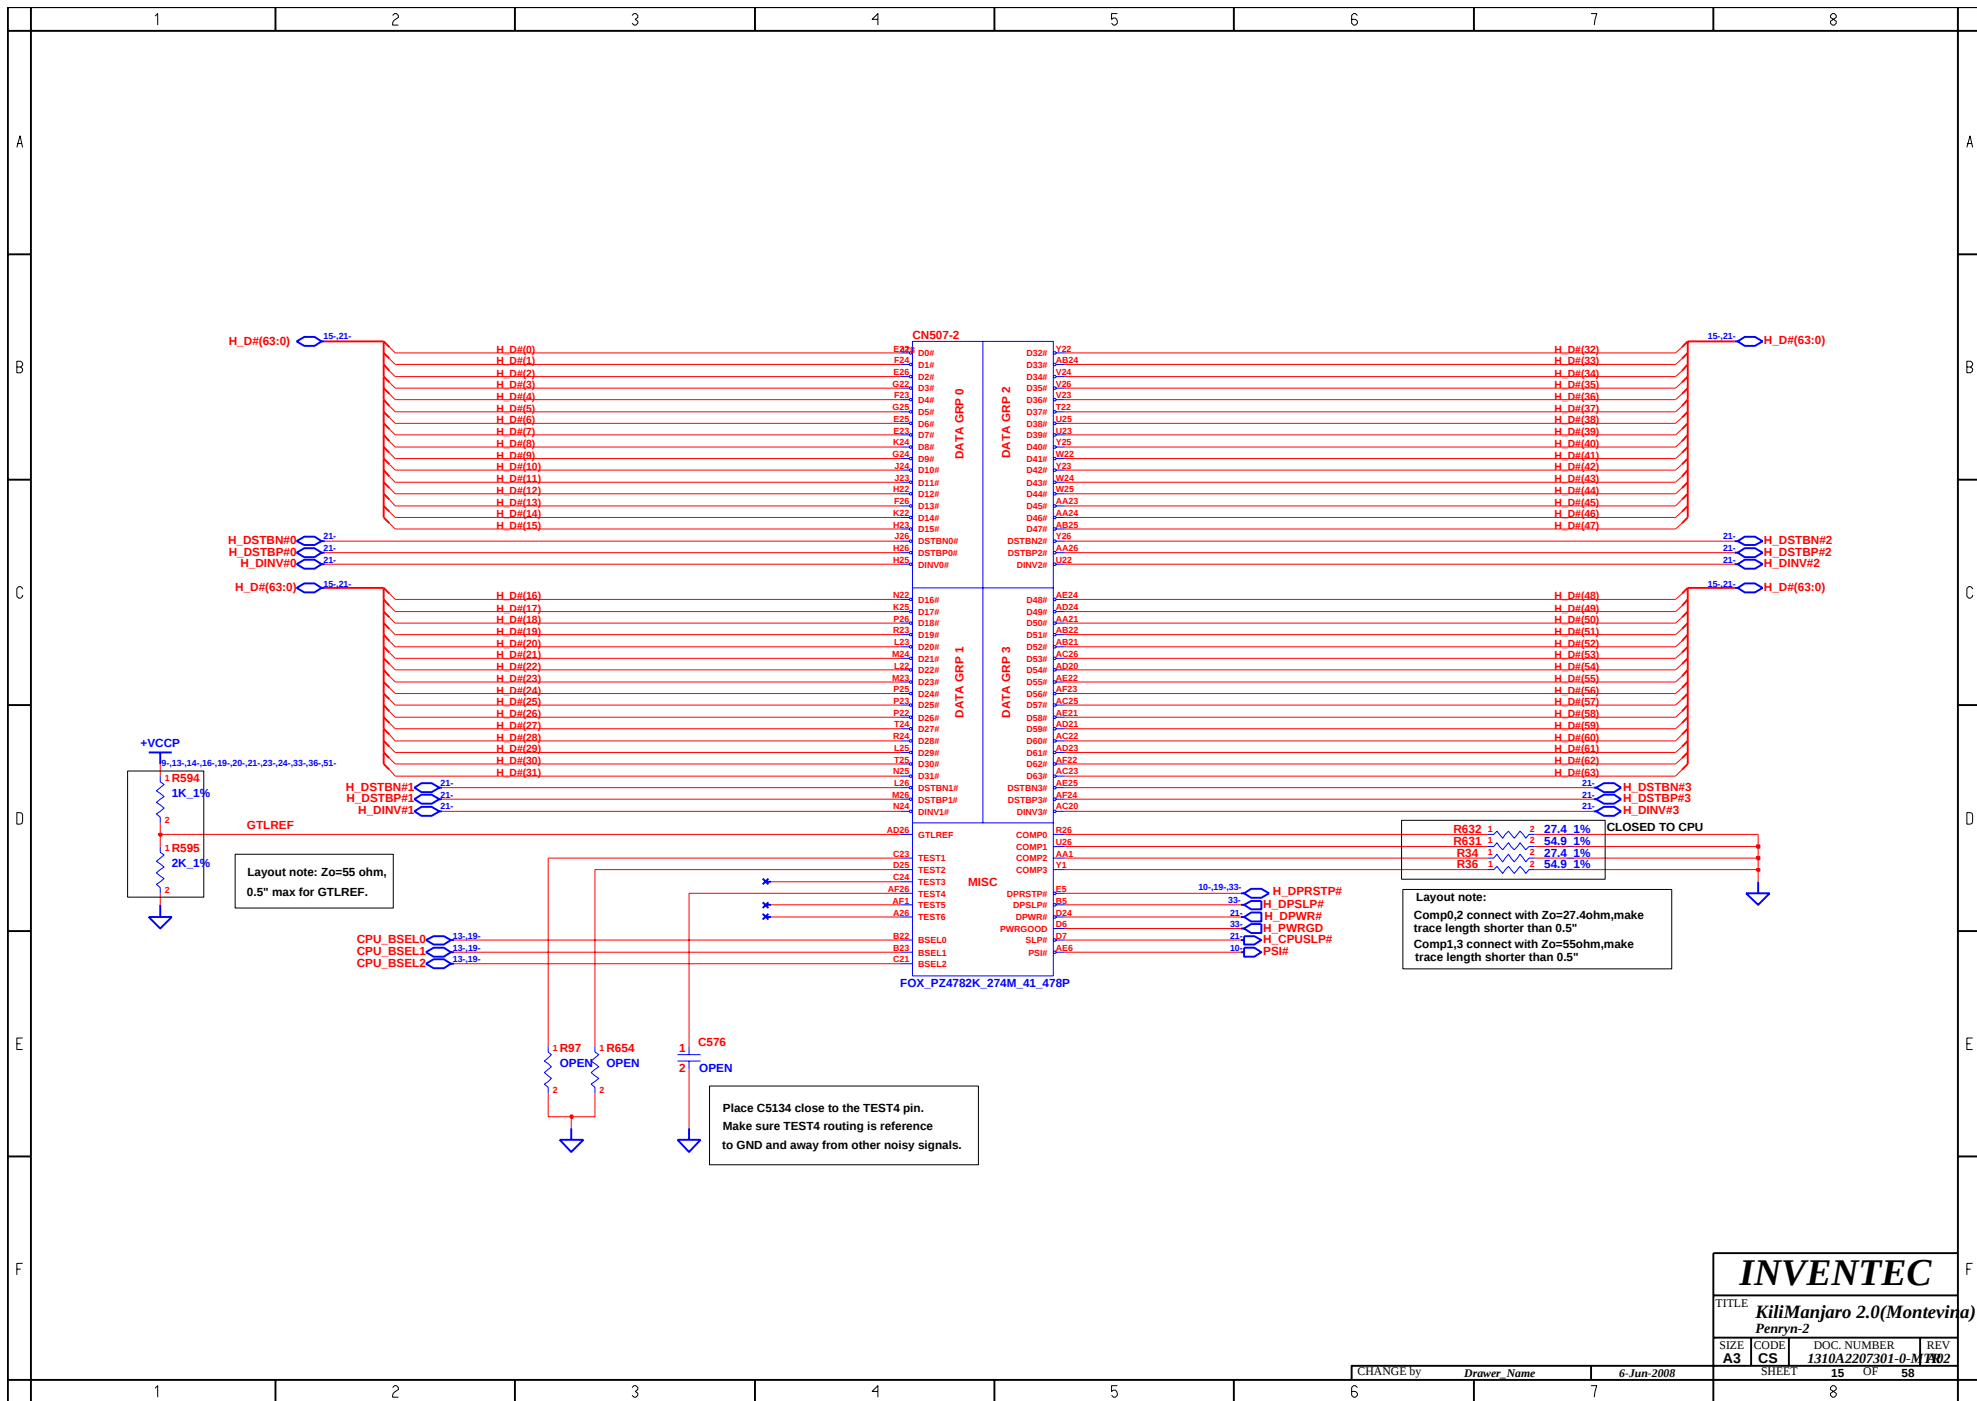

INVENTEC			
TITLE KiliManjaro 2.0(Montevina) Penryn-2			
SIZE A3	CODE CS	DOC. NUMBER 1310A2207301-0-M	REV P02
CHANGE by Drawer Name		6-Jun-2008	SHEET 15 OF 58

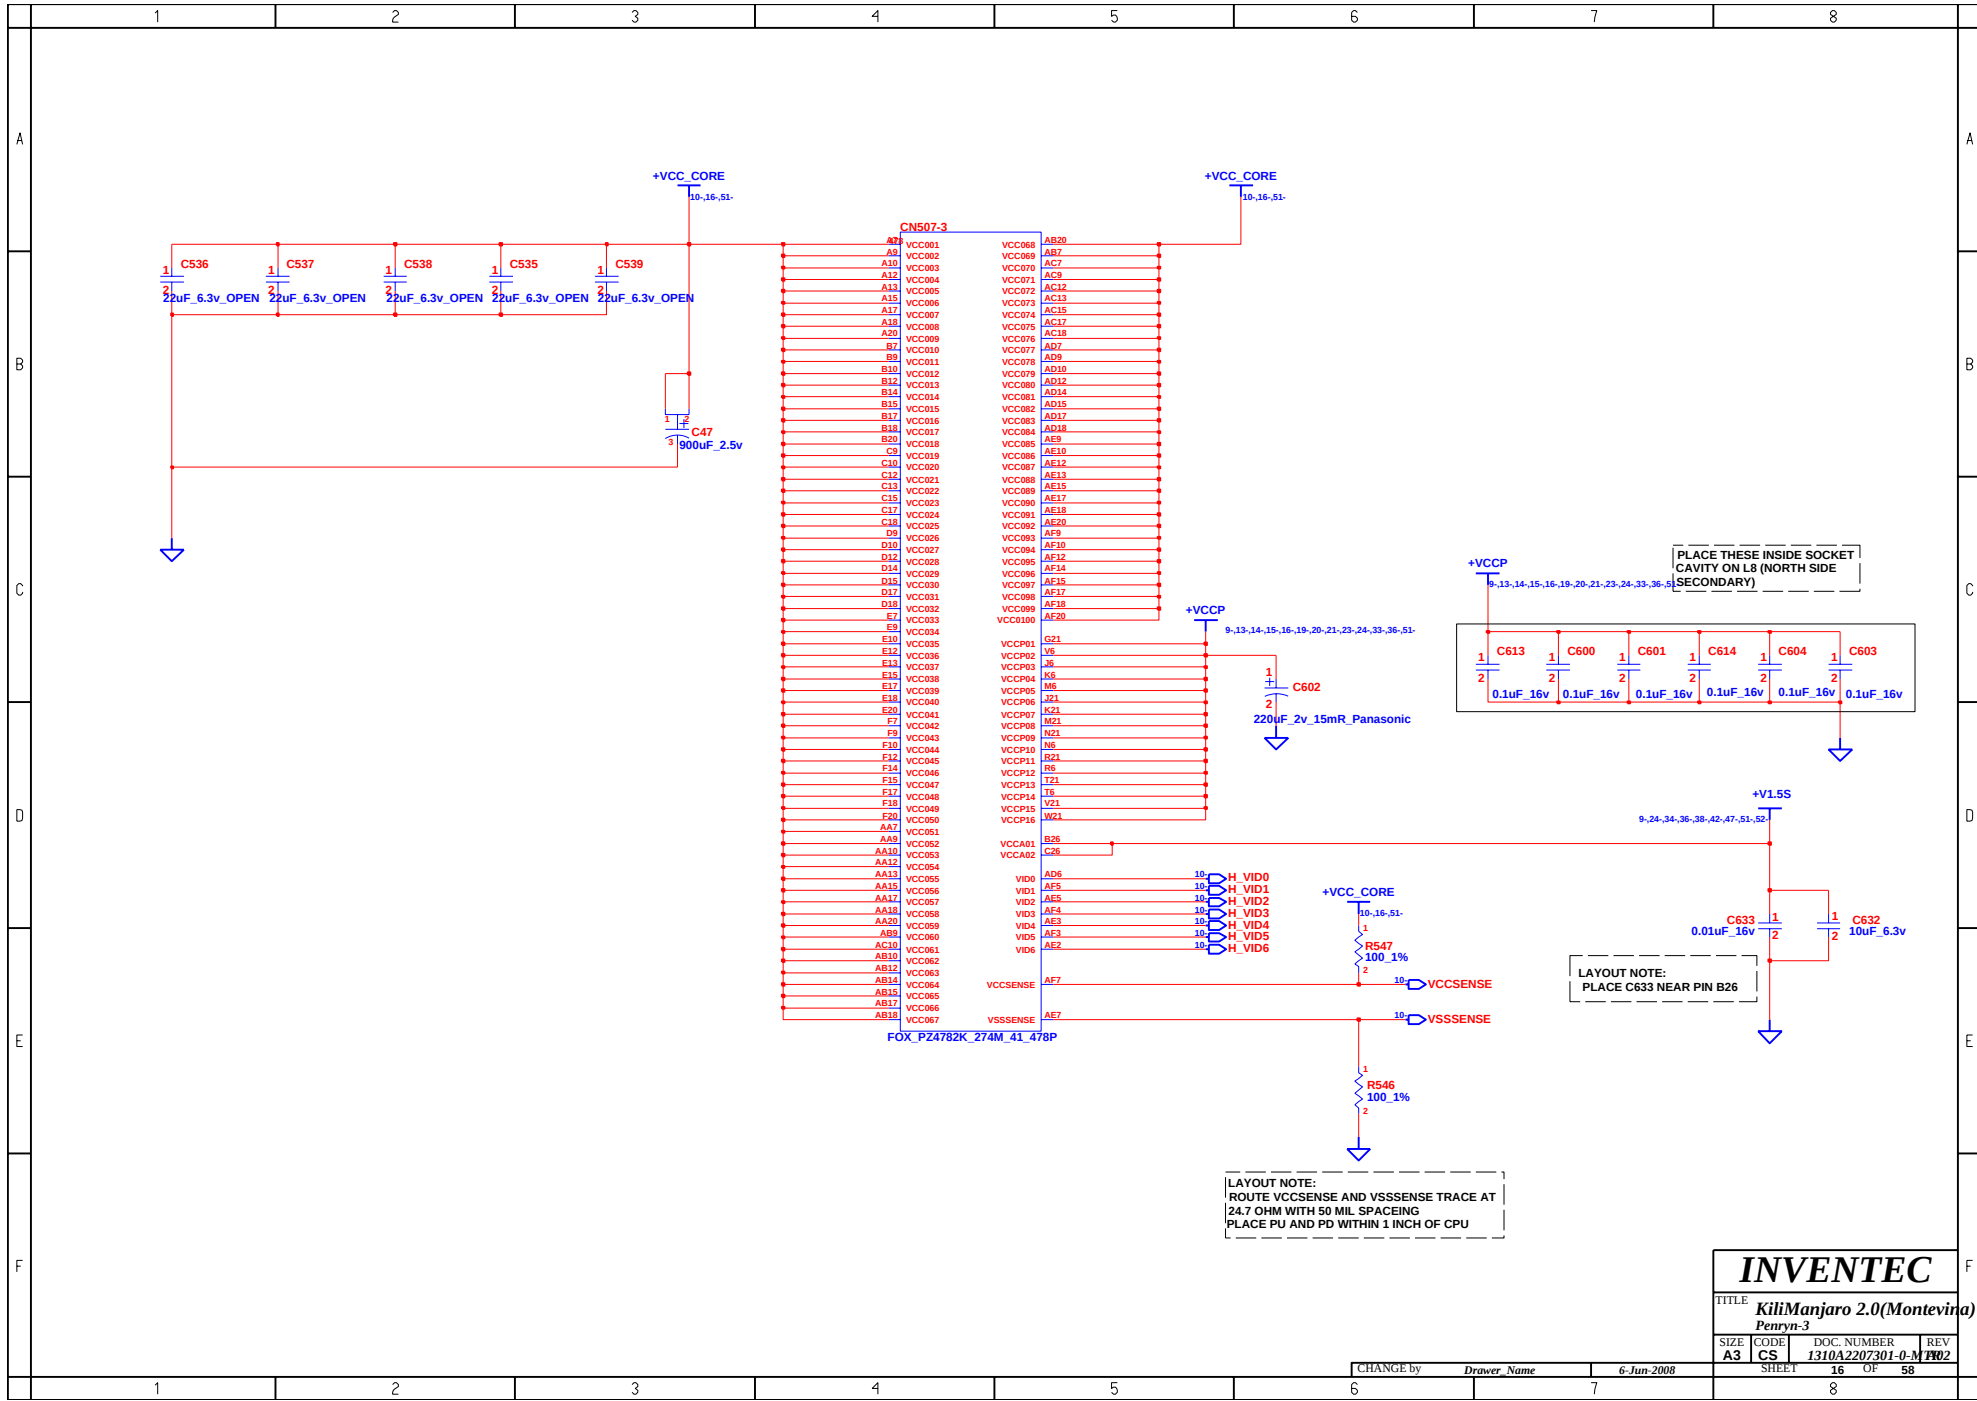

INVENTEC			
TITLE KiliManjaro 2.0(Montevina) Penryn-3			
SIZE A3	CODE CS	DOC. NUMBER 1310A2207301-0-M	REV P02
CHANGE by Drawer Name		6-Jun-2008	
SHEET 16		OF 58	
1		8	

Diagram illustrating the wiring connections for the **Penryn-4** system, showing a central vertical bus labeled **CN507-4** connected to various components.

The components are organized into columns labeled **A1** through **P6**, with corresponding pin numbers listed next to them. The connections are as follows:

Column	Pin	Component
A1	1	VSS001
A1	2	VSS002
A1	3	VSS003
A1	150	VSS150
A1	1	

INVENTEC

TITLE

KiliManjaro 2.0(Montevina)

Penryn-4

SIZE

A3

CODE

CS

DOC. NUMBER

1310A2207301-0-M

REV

102

CHANGE by

Drawer Name




6-Jun-2008

SHEET

17


OF


58

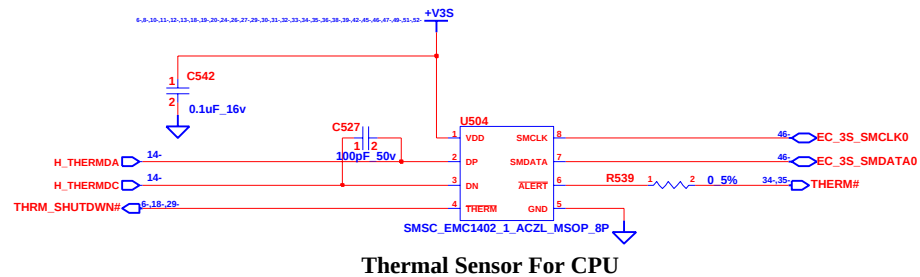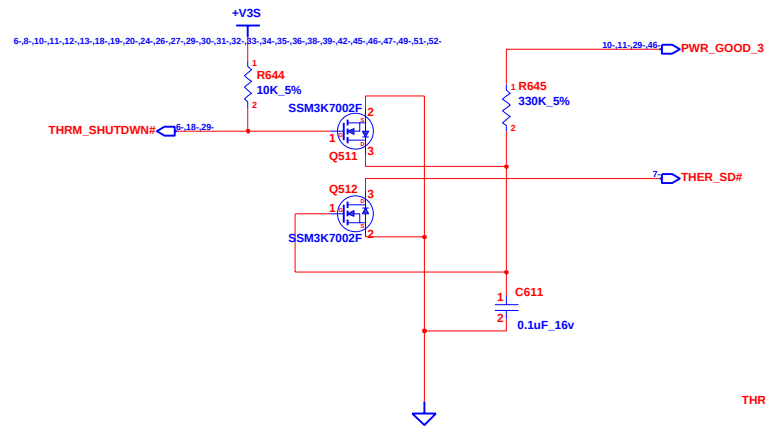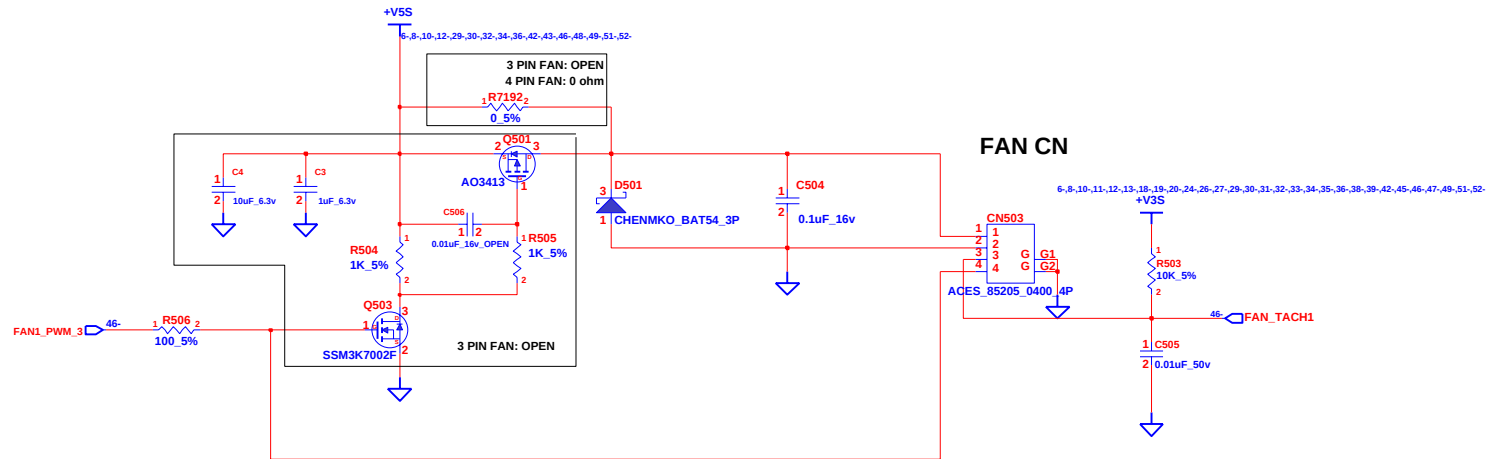



INVENTEC			
TITLE KiliManjaro 2.0(Montevina)			
THERMAL&FAN CONTROLLER			
SIZE A3	CODE CS	DOC. NUMBER 1310A2207301-0-M	REV 02
SHEET 18		OF 58	

CHANGE by Draover Name 6-Jun-2008

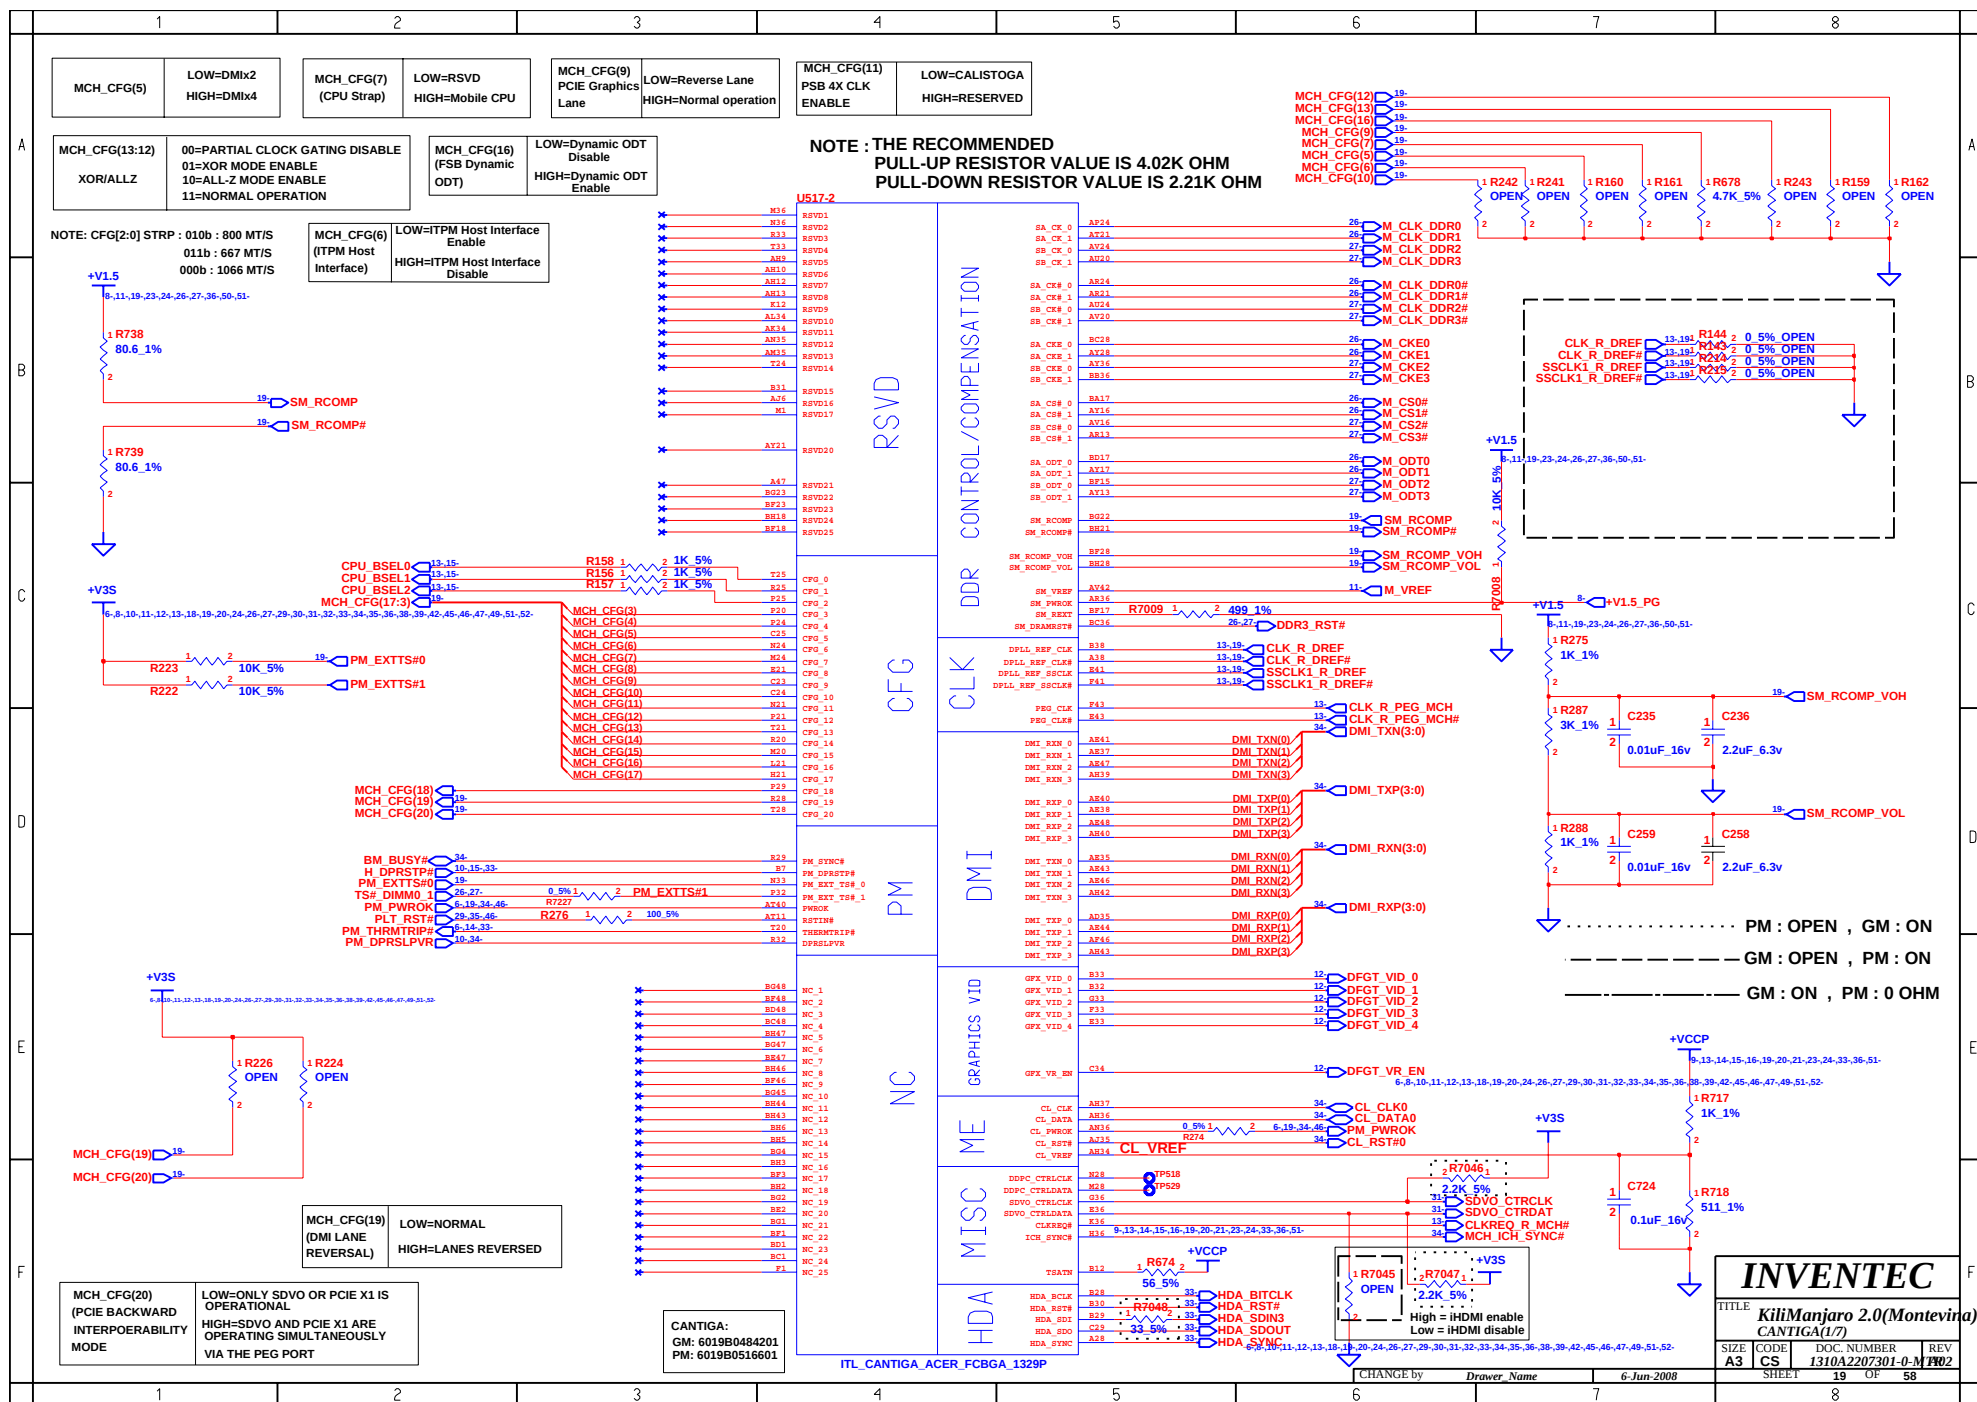

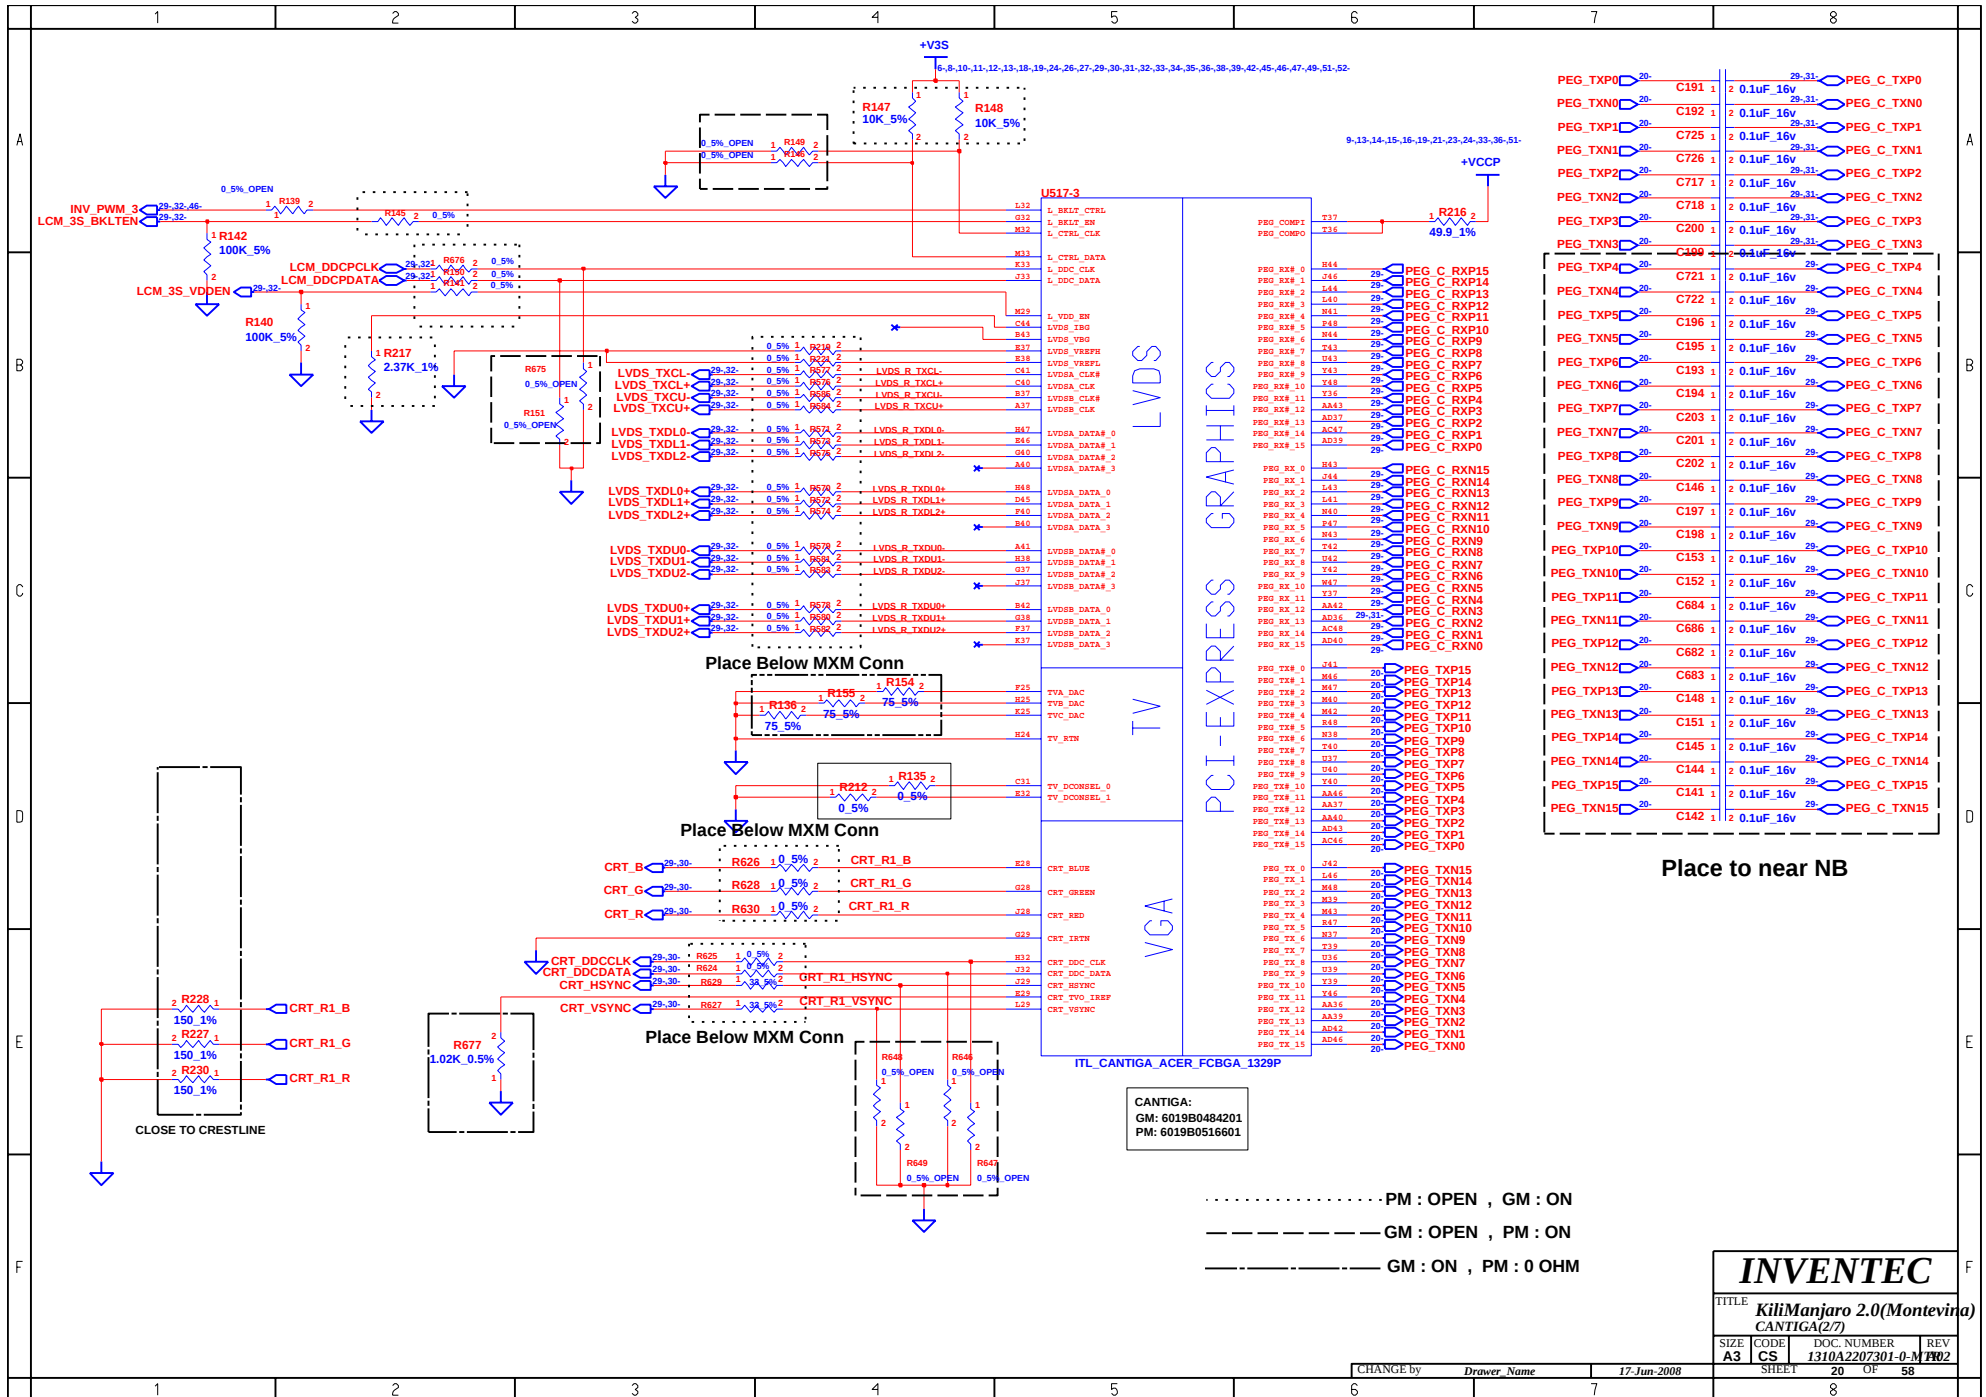

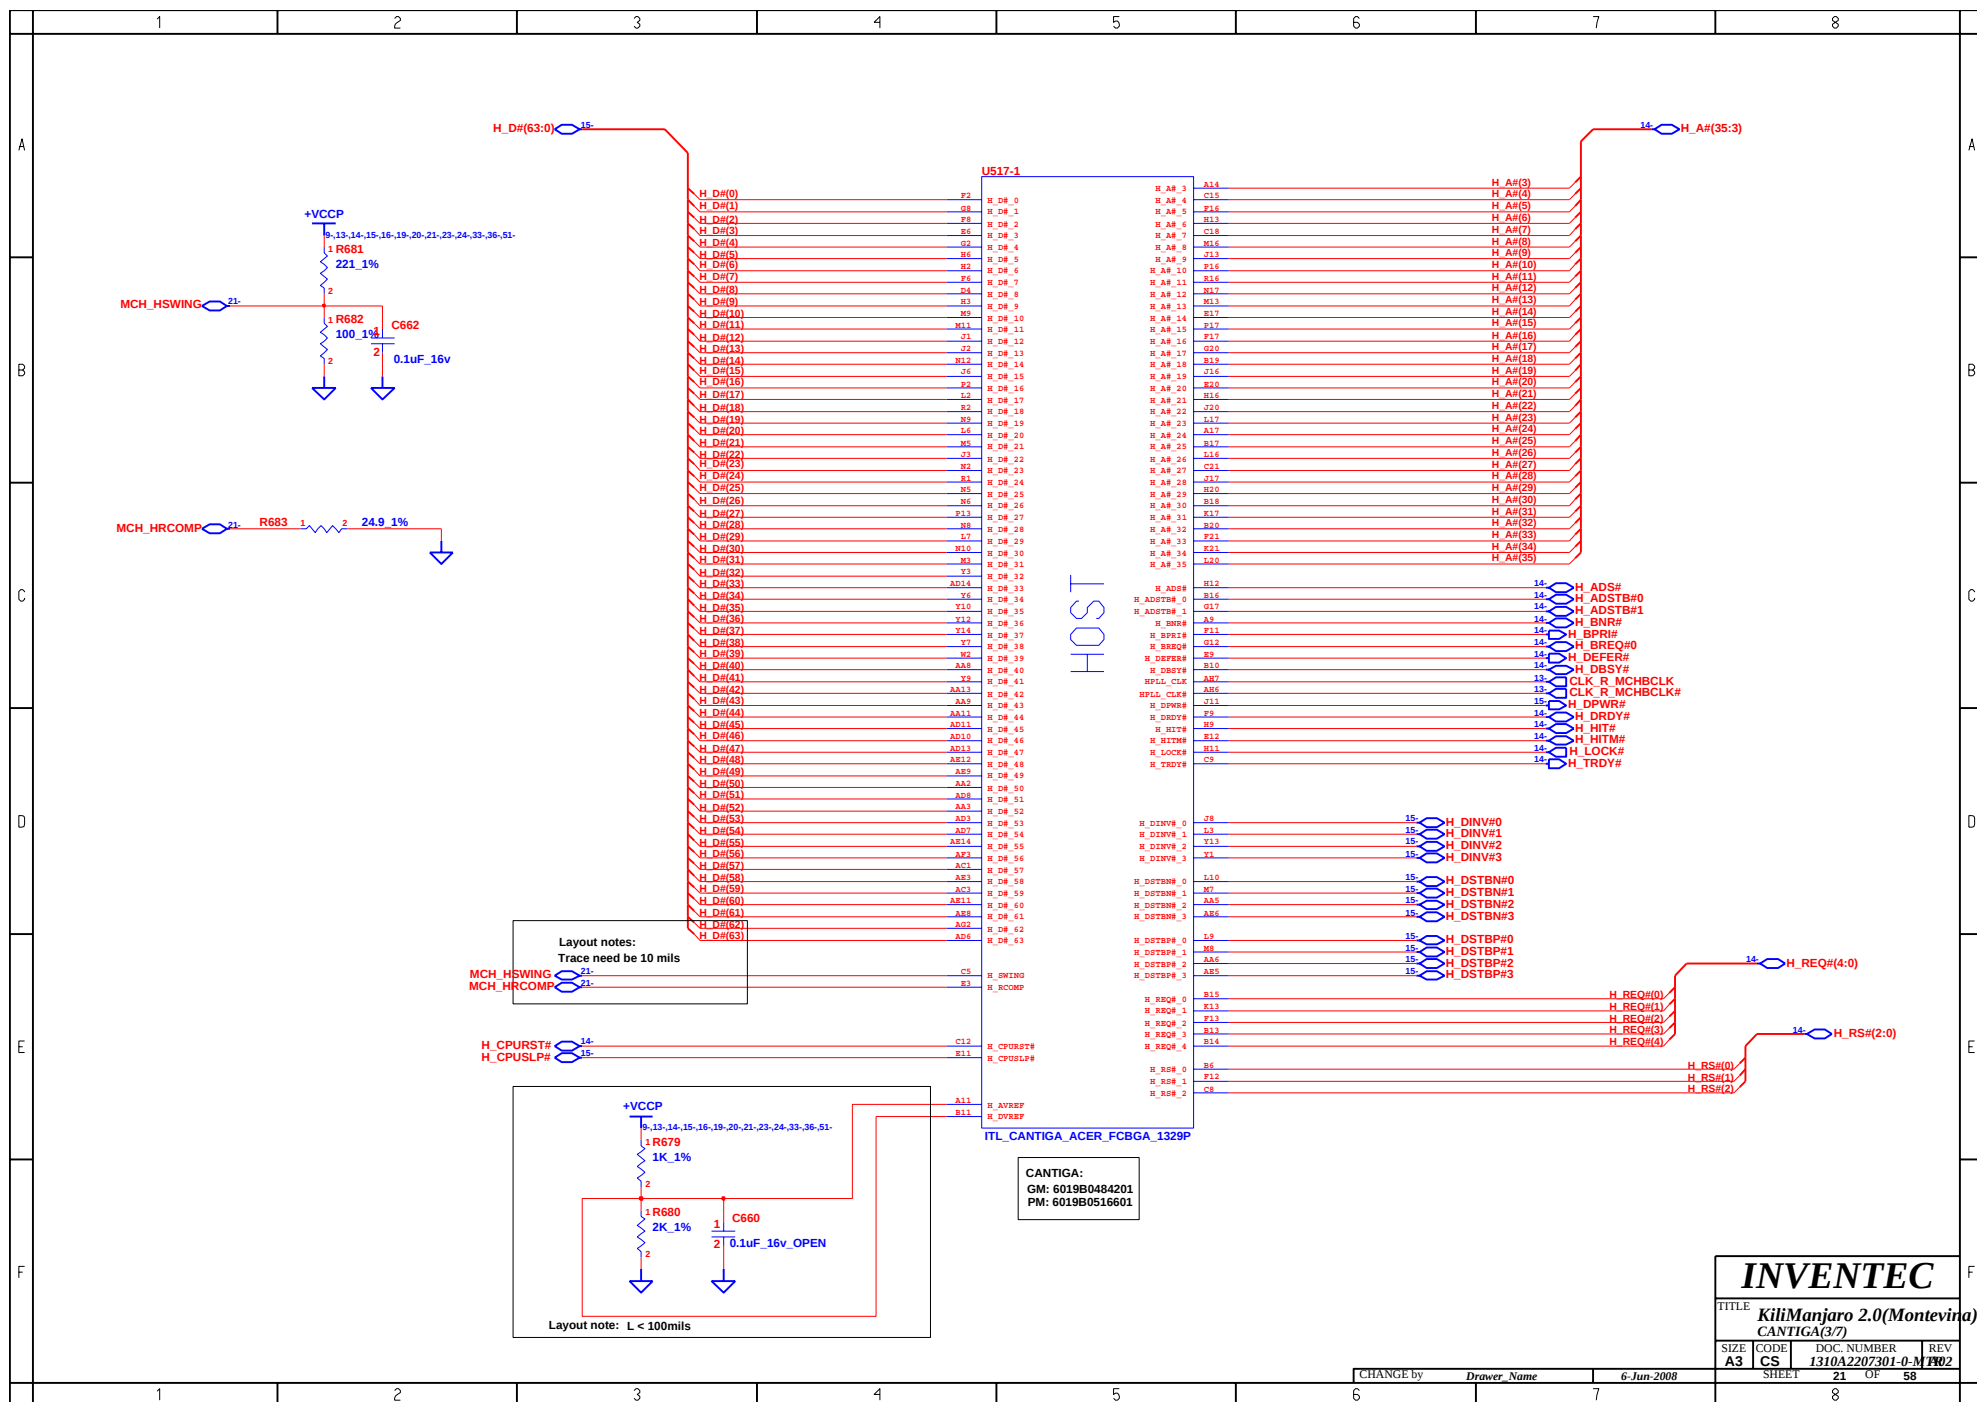


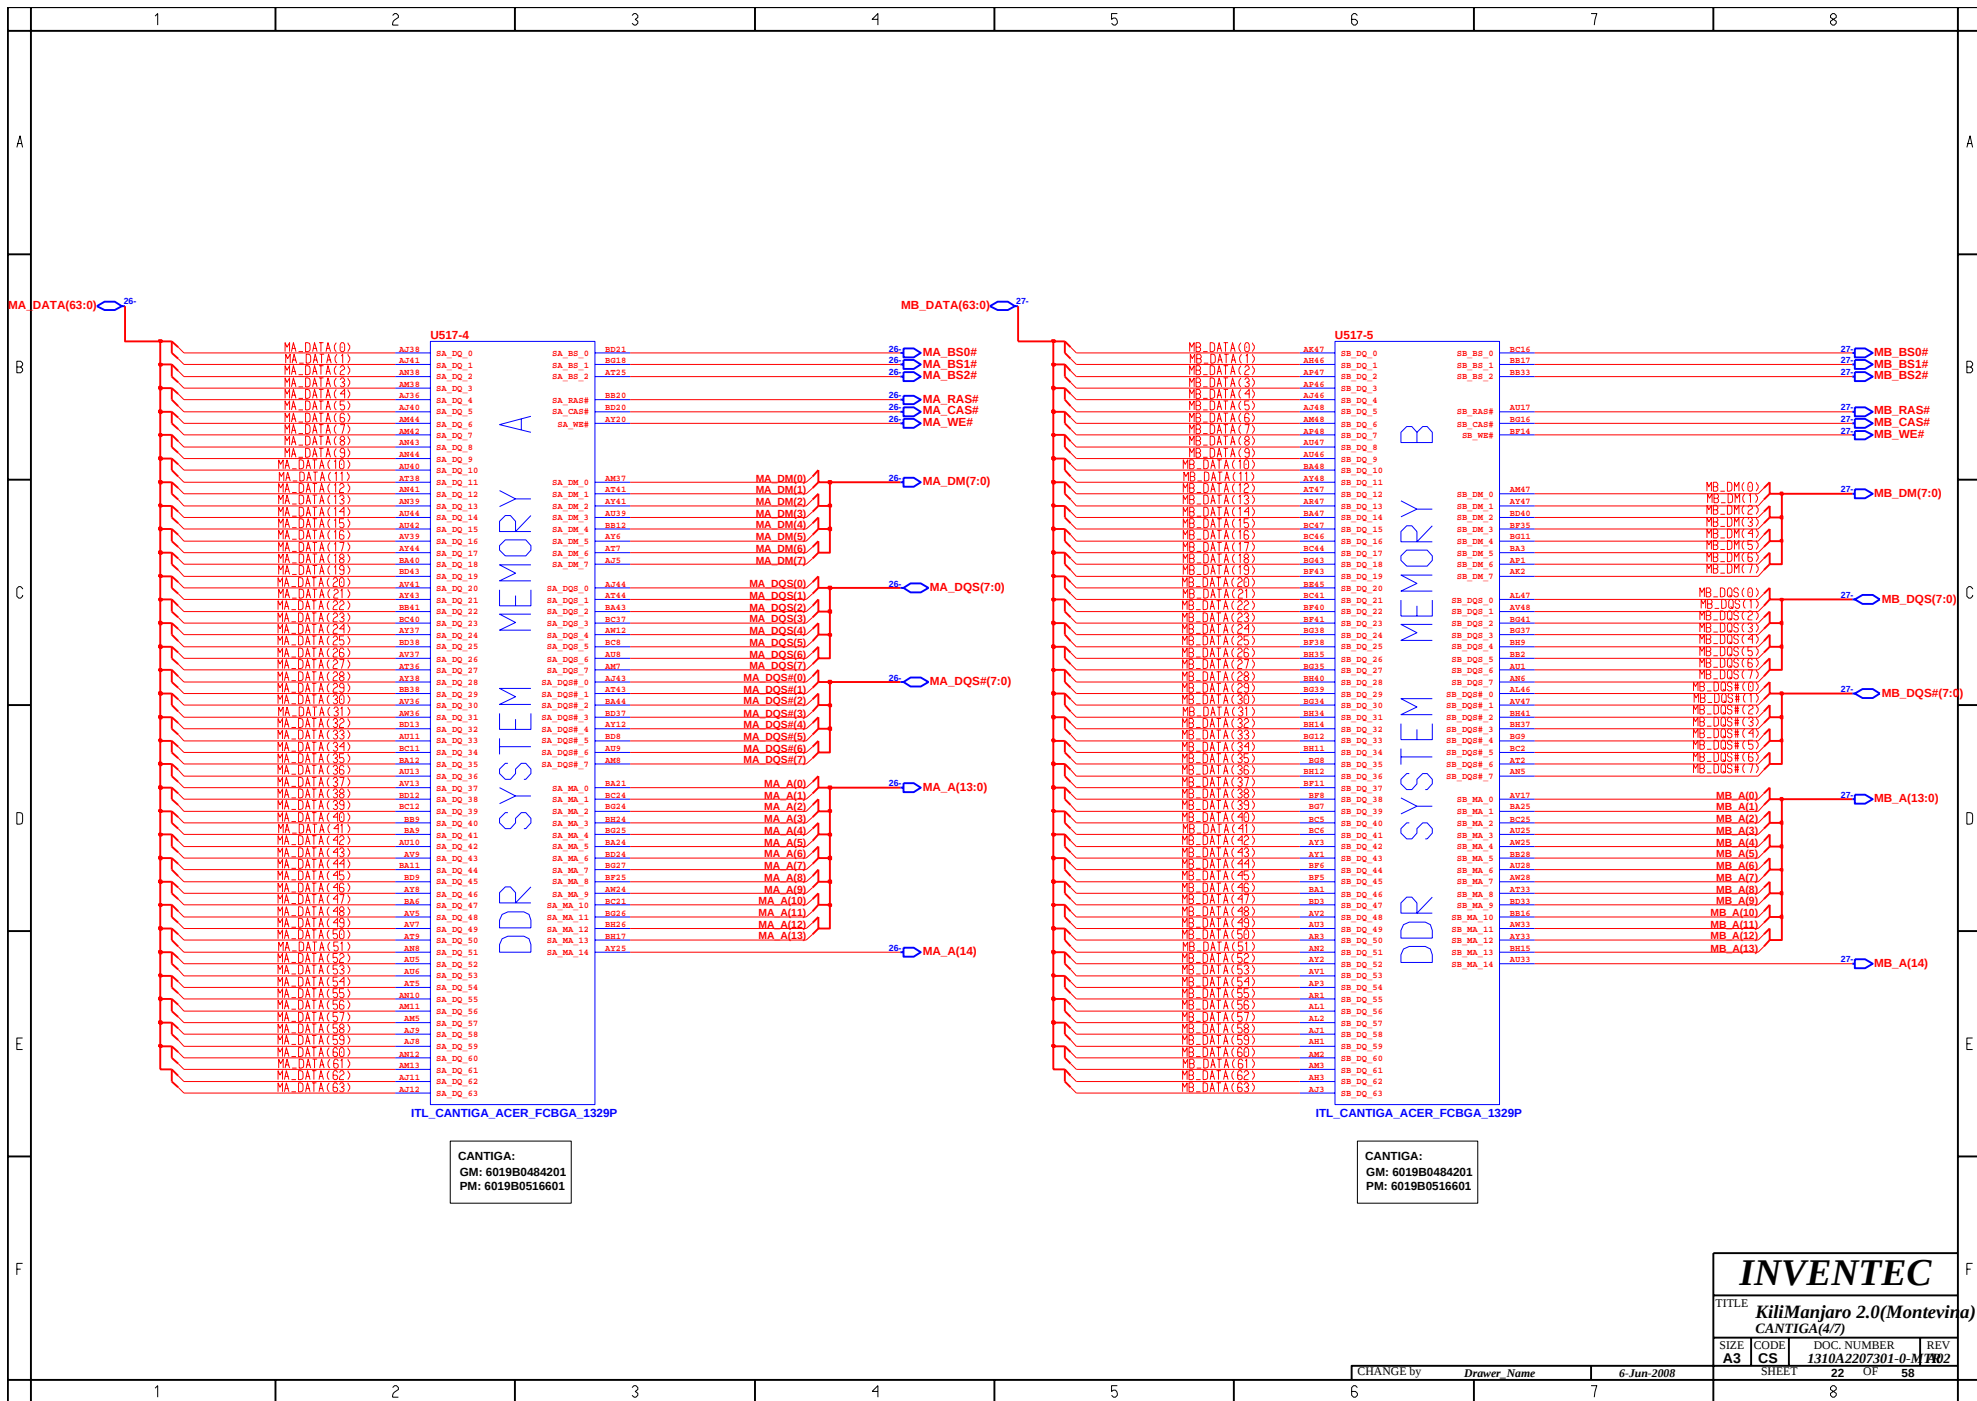


CANTIGA:
GM: 6019B0484201
PM: 6019B0516601

CANTIGA:
GM: 6019B0484201
PM: 6019B0516601

INVENTEC			
TITLE KiliManjaro 2.0(Montevina) CANTIGA(4/7)			
SIZE A3	CODE CS	DOC. NUMBER 1310A2207301-0-M	REV P02
CHANGE by		Drawn Name	6-Jun-2008
SHEET		22	OF 58

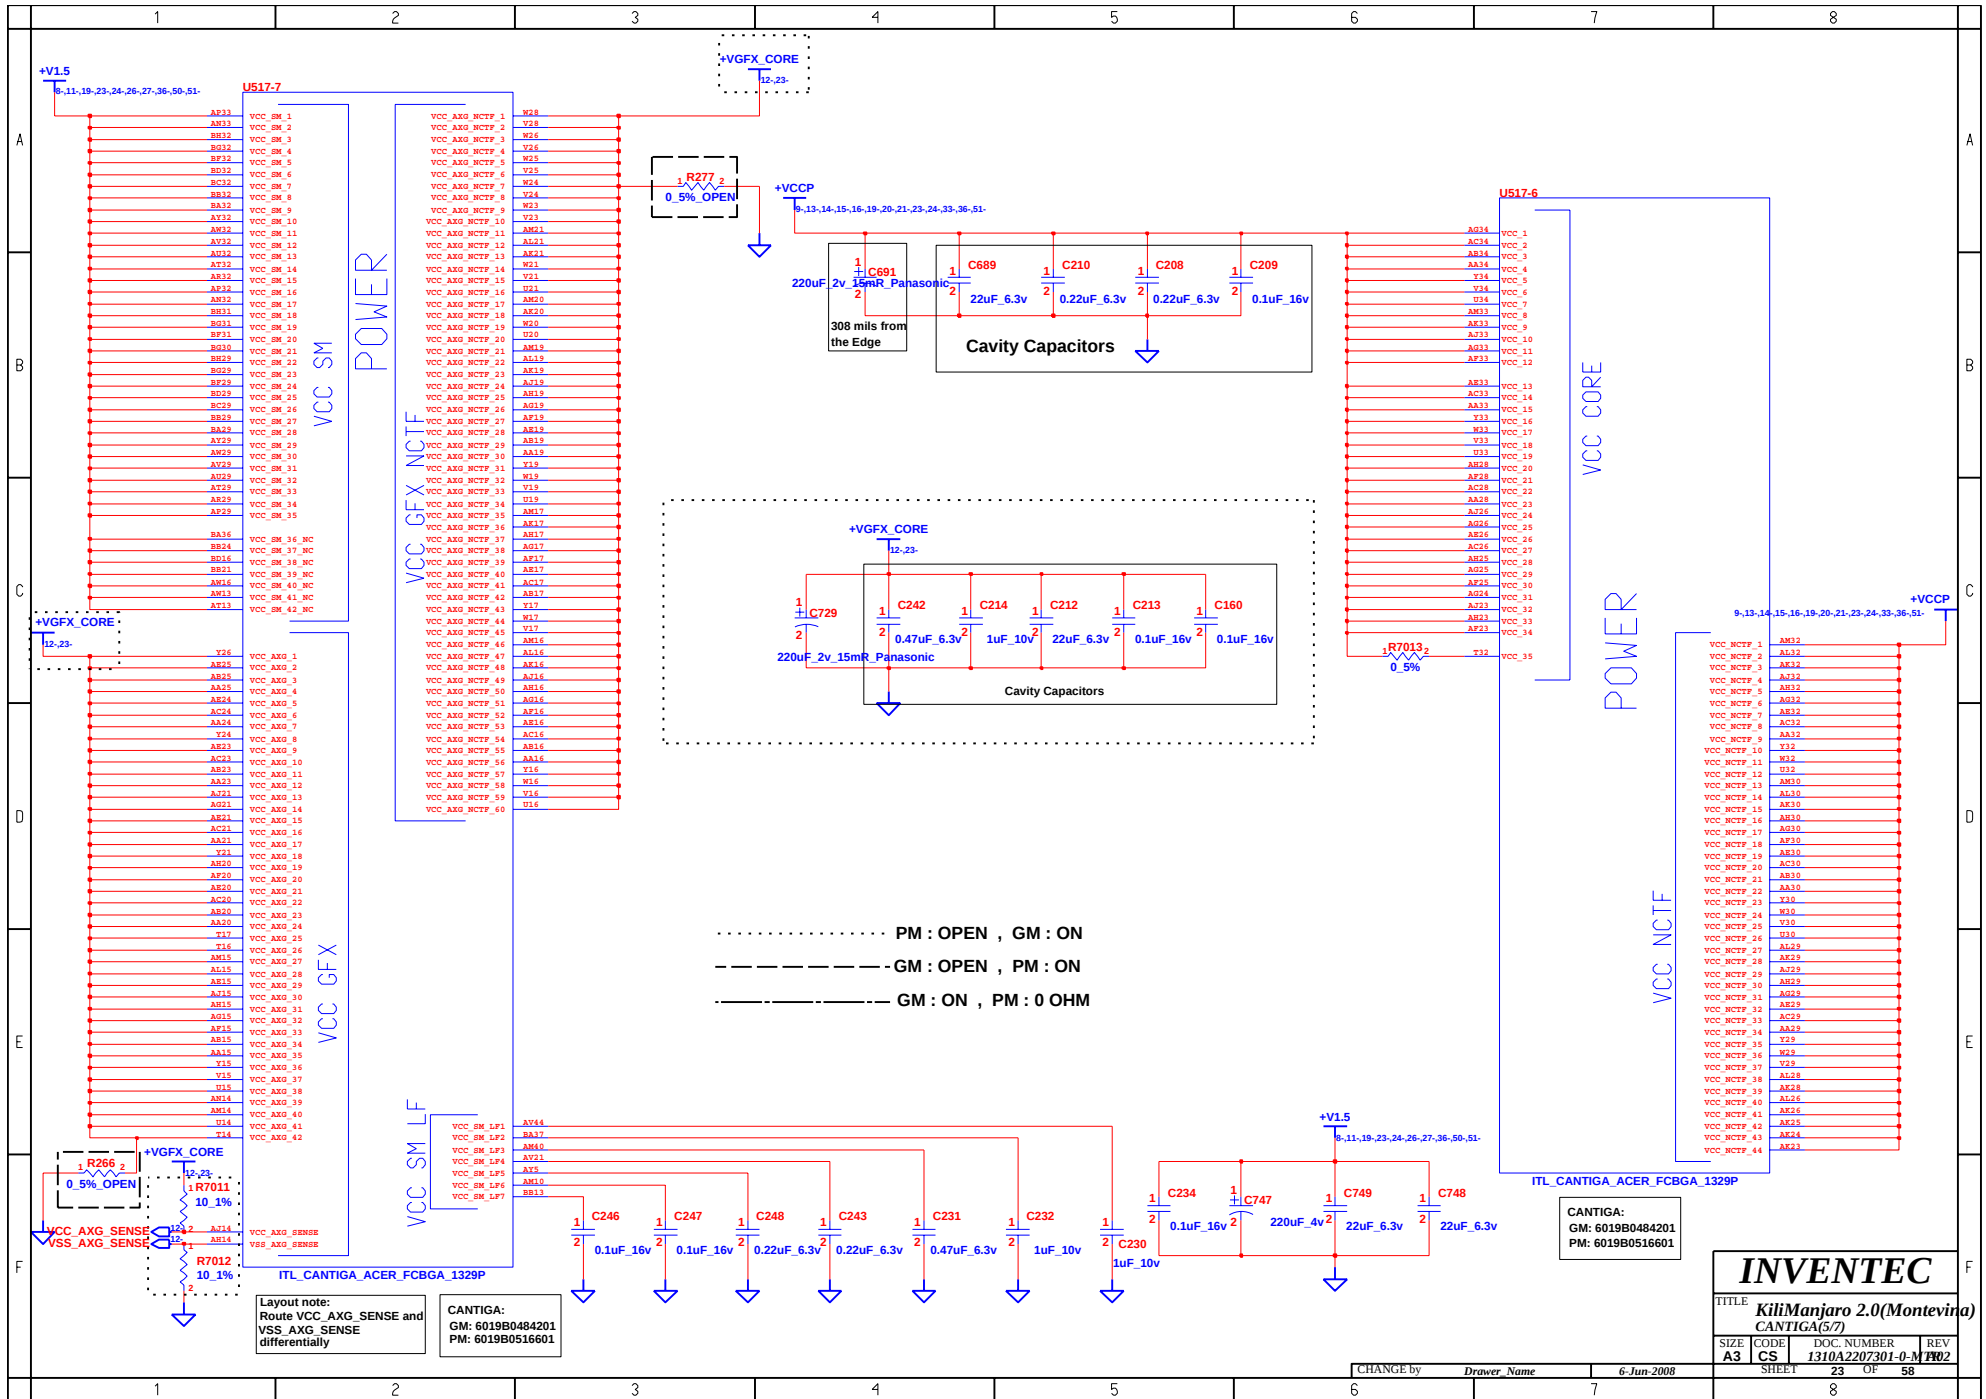

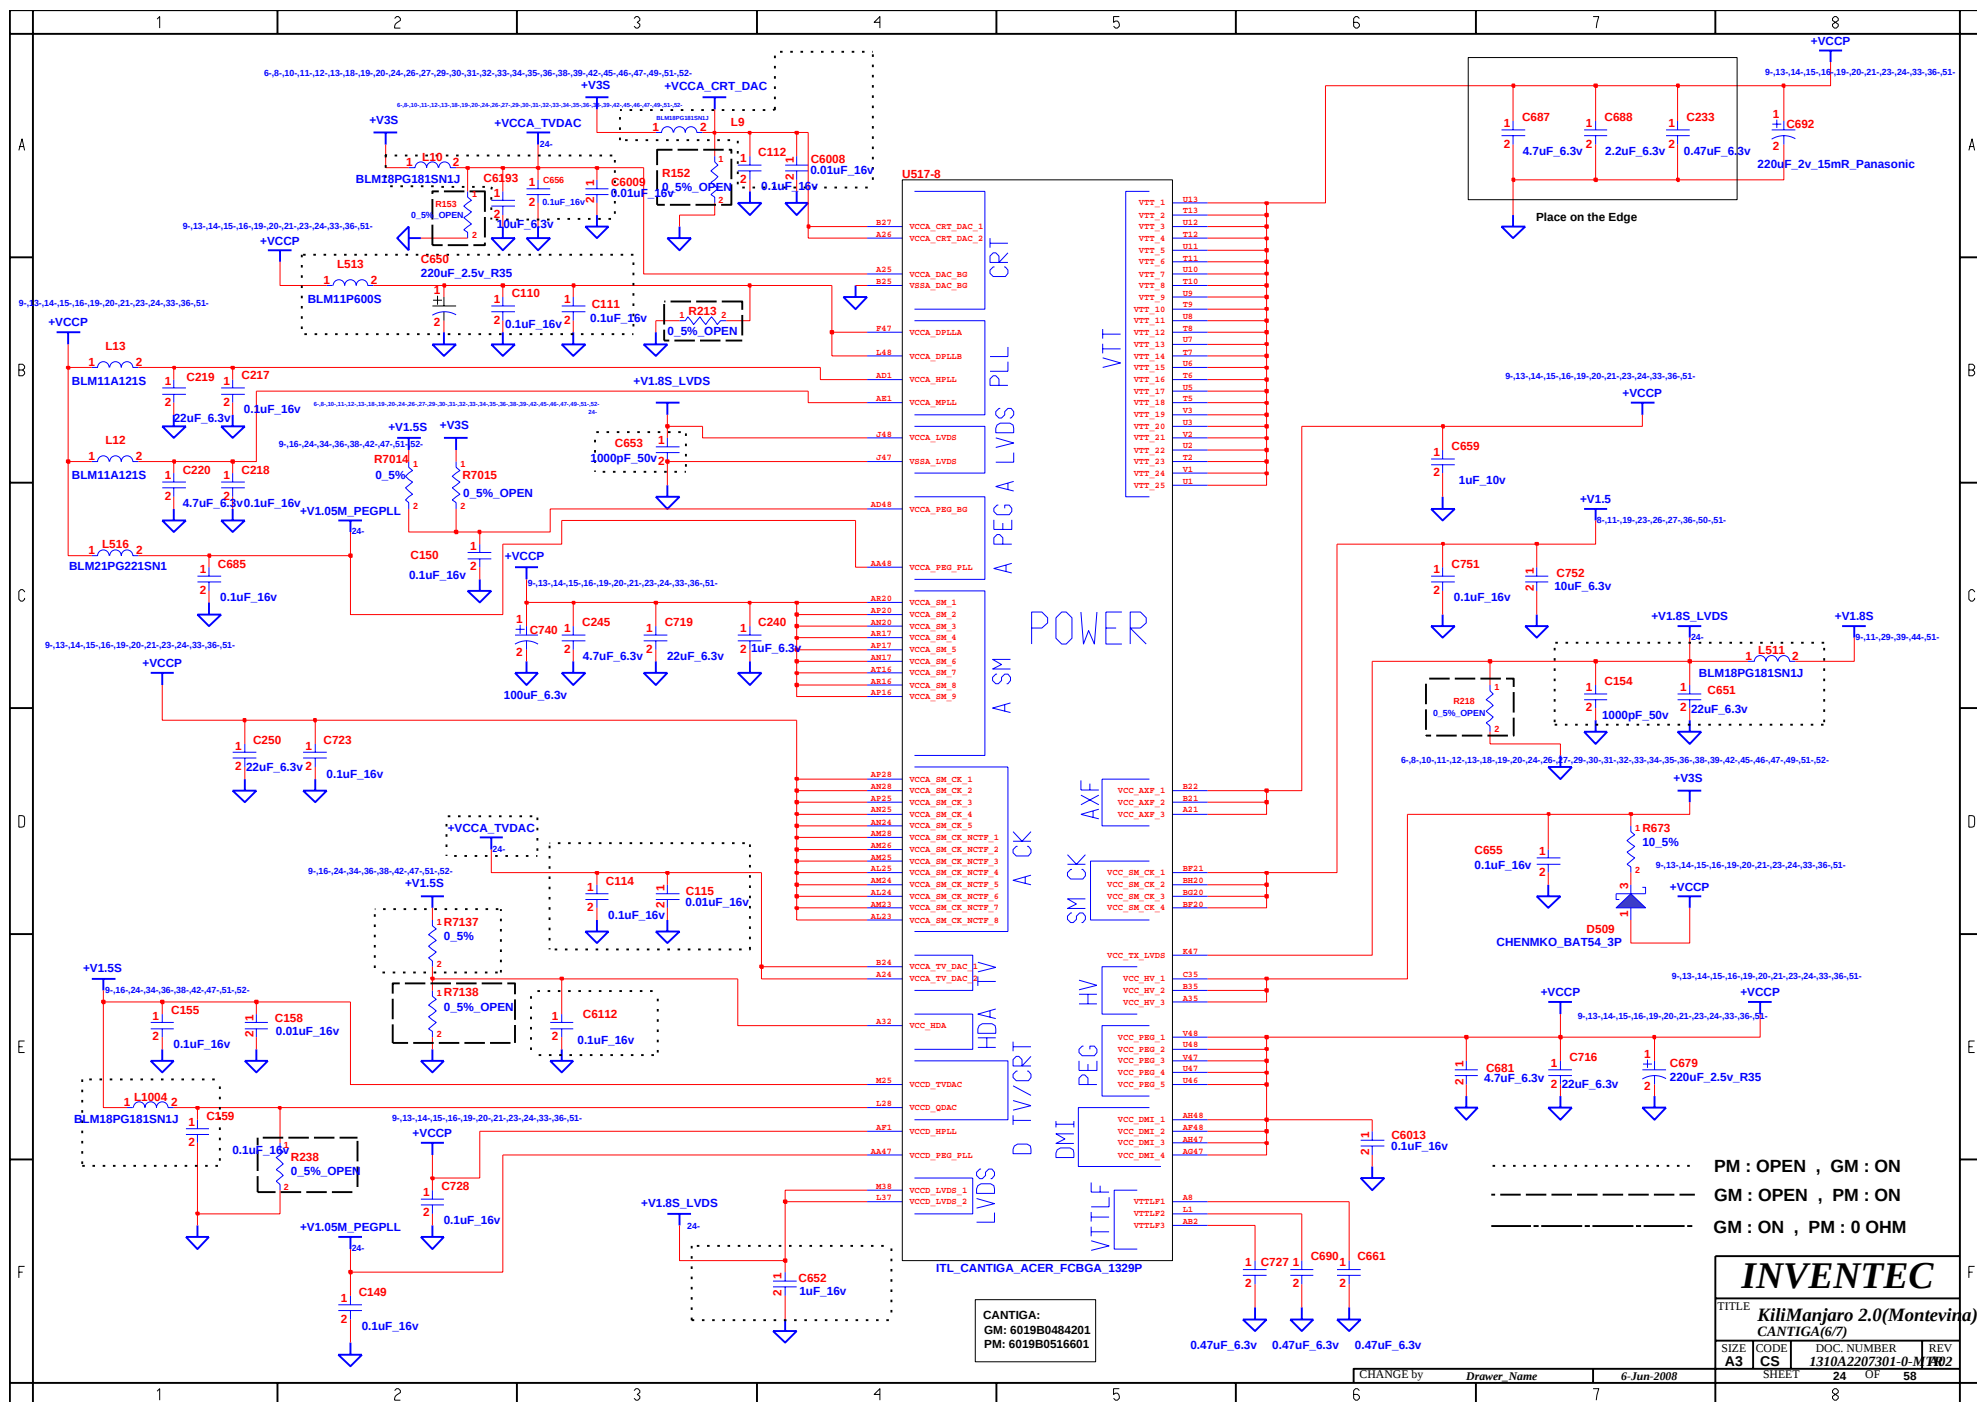

	1	2	3	4	5	6	7	8							
A		U517-9 AD48 V88_1 V88_100 AR48 V88_2 V88_101 AL48 V88_3 V88_102 BR47 V88_4 V88_103 AM17 V88_5 V88_104 AM47 V88_6 V88_105 AZ47 V88_7 V88_106 AD47 V88_8 V88_107 V88_9 V88_108 V88_109 AB47 V88_10 V88_110 V88_11 V88_111 V88_112 V88_12 V88_113 V88_114 V88_13 V88_115 V88_116 V88_14 V88_117 V88_118 V88_15 V88_119 V88_120 V88_16 V88_121 V88_122 V88_17 V88_123 V88_124 V88_18 V88_125 V88_126 V88_19 V88_127 V88_128 V88_20 V88_129 V88_130 V88_21 V88_131 V88_132 V88_22 V88_133 V88_134 V88_23 V88_135 V88_136 V88_24 V88_137 V88_138 V88_25 V88_139 V88_140 V88_26 V88_141 V88_142 V88_27 V88_143 V88_144 V88_28 V88_145 V88_146 V88_29 V88_147 V88_148 V88_30 V88_149 V88_150 V88_31 V88_151 V88_152 V88_32 V88_153 V88_154 V88_33 V88_155 V88_156 V88_34 V88_157 V88_158 V88_35 V88_159 V88_160 V88_36 V88_161 V88_162 V88_37 V88_163 V88_164 V88_38 V88_165 V88_166 V88_39 V88_167 V88_168 V88_40 V88_169 V88_170 V88_41 V88_171 V88_172 V88_42 V88_173 V88_174 V88_43 V88_175 V88_176 V88_44 V88_177 V88_178 V88_45 V88_179 V88_180 V88_46 V88_181 V88_182 V88_47 V88_183 V88_184 V88_48 V88_185 V88_186 V88_49 V88_187 V88_188 V88_50 V88_189 V88_190 V88_51 V88_191 V88_192 V88_52 V88_193 V88_194 V88_53 V88_195 V88_196 V88_54 V88_197 V88_198 V88_55 V88_199 V88_200 ITL_CANTIGA_ACER_FCBGA_1329P CANTIGA: GM: 6019B0484201 PM: 6019B0516601						U517-10 RG21 V88_199 V88_297 L12 V88_200 V88_298 AM21 V88_201 V88_299 AD21 V88_202 V88_300 AP21 V88_203 V88_301 AM21 V88_204 V88_302 AB21 V88_205 V88_303 AE21 V88_206 V88_304 AB21 V88_207 V88_305 R21 V88_208 V88_306 M21 V88_209 V88_307 V21 V88_210 V88_308 GA21 V88_211 V88_309 BC20 V88_212 V88_310 BA20 V88_213 V88_311 AM20 V88_214 V88_312 AT20 V88_215 V88_313 AJ20 V88_216 V88_314 AG20 V88_217 V88_315 Y20 V88_218 V88_316 N20 V88_219 V88_317 K20 V88_220 V88_318 F20 V88_221 V88_319 C20 V88_222 V88_320 A20 V88_223 V88_321 RG19 V88_224 V88_322 A18 V88_225 V88_323 RG17 V88_226 V88_324 BC17 V88_227 V88_325 AM17 V88_228 V88_326 AE17 V88_229 V88_327 AP17 V88_230 V88_328 M17 V88_231 V88_329 N17 V88_232 V88_330 C17 V88_233 V88_331 V88_234 V88_332 V88_333 BA16 V88_235 V88_334 AT16 V88_236 V88_335 AM16 V88_237 V88_336 N16 V88_238 V88_337 K16 V88_239 V88_338 Q16 V88_240 V88_339 R16 V88_241 V88_340 RG15 V88_242 V88_341 AC15 V88_243 V88_342 N15 V88_244 V88_343 AE15 V88_245 V88_344 RG14 V88_246 V88_345 BA14 V88_247 V88_346 AE14 V88_248 V88_347 C14 V88_249 V88_348 RG13 V88_250 V88_349 BC13 V88_251 V88_350 BA13 V88_252 V88_351 V88_253 V88_352 V88_353 AM13 V88_254 V88_354 AE13 V88_255 V88_355 N13 V88_256 V88_356 L13 V88_257 V88_357 Q13 V88_258 V88_358 E13 V88_259 V88_359 BF12 V88_260 V88_360 AV12 V88_261 V88_361 AT12 V88_262 V88_362 AM12 V88_263 V88_363 V88_264 V88_364 V88_365 AA12 V88_266 V88_366 V12 V88_267 V88_367 A12 V88_268 V88_368 BD11 V88_269 V88_369 BB11 V88_270 V88_370 AT11 V88_271 V88_371 AM11 V88_272 V88_372 AB11 V88_273 V88_373 V88_274 V88_374 V88_375 V11 V88_276 V88_376 N11 V88_277 V88_377 Q11 V88_278 V88_378 C11 V88_279 V88_379 RG10 V88_280 V88_380 AT10 V88_281 V88_381 AG10 V88_282 V88_382 AE10 V88_283 V88_383 BA10 V88_284 V88_384 M10 V88_285 V88_385 BF2 V88_286 V88_386 BA2 V88_287 V88_387 AM9 V88_288 V88_388 AM9 V88_289 V88_389 AG9 V88_290 V88_390 Q9 V88_291 V88_391 B9 V88_292 V88_392 BB8 V88_293 V88_393 BB8 V88_294 V88_394 AT8 V88_295 V88_395 V88_296 V88_396 V88_397 V88_298 V88_398 V88_399 V88_300 V88_400 V88_401 V88_301 V88_402 V88_403 V88_302 V88_404 V88_405 V88_303 V88_406 V88_407 V88_304 V88_408 V88_409 V88_305 V88_410 V88_411 V88_306 V88_412 V88_413 V88_307 V88_414 V88_415 V88_308 V88_416 V88_417 V88_309 V88_418 V88_419 V88_310 V88_420 V88_421 V88_311 V88_422 V88_423 V88_312 V88_424 V88_425 V88_313 V88_426 V88_427 V88_314 V88_428 V88_429 V88_315 V88_430 V88_431 V88_316 V88_432 V88_433 V88_317 V88_434 V88_435 V88_318 V88_436 V88_437 V88_319 V88_438 V88_439 V88_320 V88_440 V88_441 V88_321 V88_442 V88_443 V88_322 V88_444 V88_445 V88_323 V88_446 V88_447 V88_324 V88_448 V88_449 V88_325 V88_450 V88_451 V88_326 V88_452 V88_453 V88_327 V88_454 V88_455 V88_328 V88_456 V88_457 V88_329 V88_458 V88_459 V88_330 V88_460 V88_461 V88_331 V88_462 V88_463 V88_332 V88_464 V88_465 V88_333 V88_466 V88_467 V88_334 V88_468 V88_469 V88_335 V88_470 V88_471 V88_336 V88_472 V88_473 V88_337 V88_474 V88_475 V88_338 V88_476 V88_477 V88_339 V88_478 V88_479 V88_340 V88_480 V88_481 V88_341 V88_482 V88_483 V88_342 V88_484 V88_485 V88_343 V88_486 V88_487 V88_344 V88_488 V88_489 V88_345 V88_490 V88_491 V88_346 V88_492 V88_493 V88_347 V88_494 V88_495 V88_348 V88_496 V88_497 V88_349 V88_498 V88_499 V88_350 V88_500 V88_501 ITL_CANTIGA_ACER_FCBGA_1329P CANTIGA: GM: 6019B0484201 PM: 6019B0516601							
B															
C															
D															
E															
F															


INVENTEC

TITLE
KiliManjaro 2.0(Montevina)

CANTIGA(7/7)


SIZE CODE DOC. NUMBER REV
A3 CS 1310A2207301-0-M 702


SHEET 25 OF 58

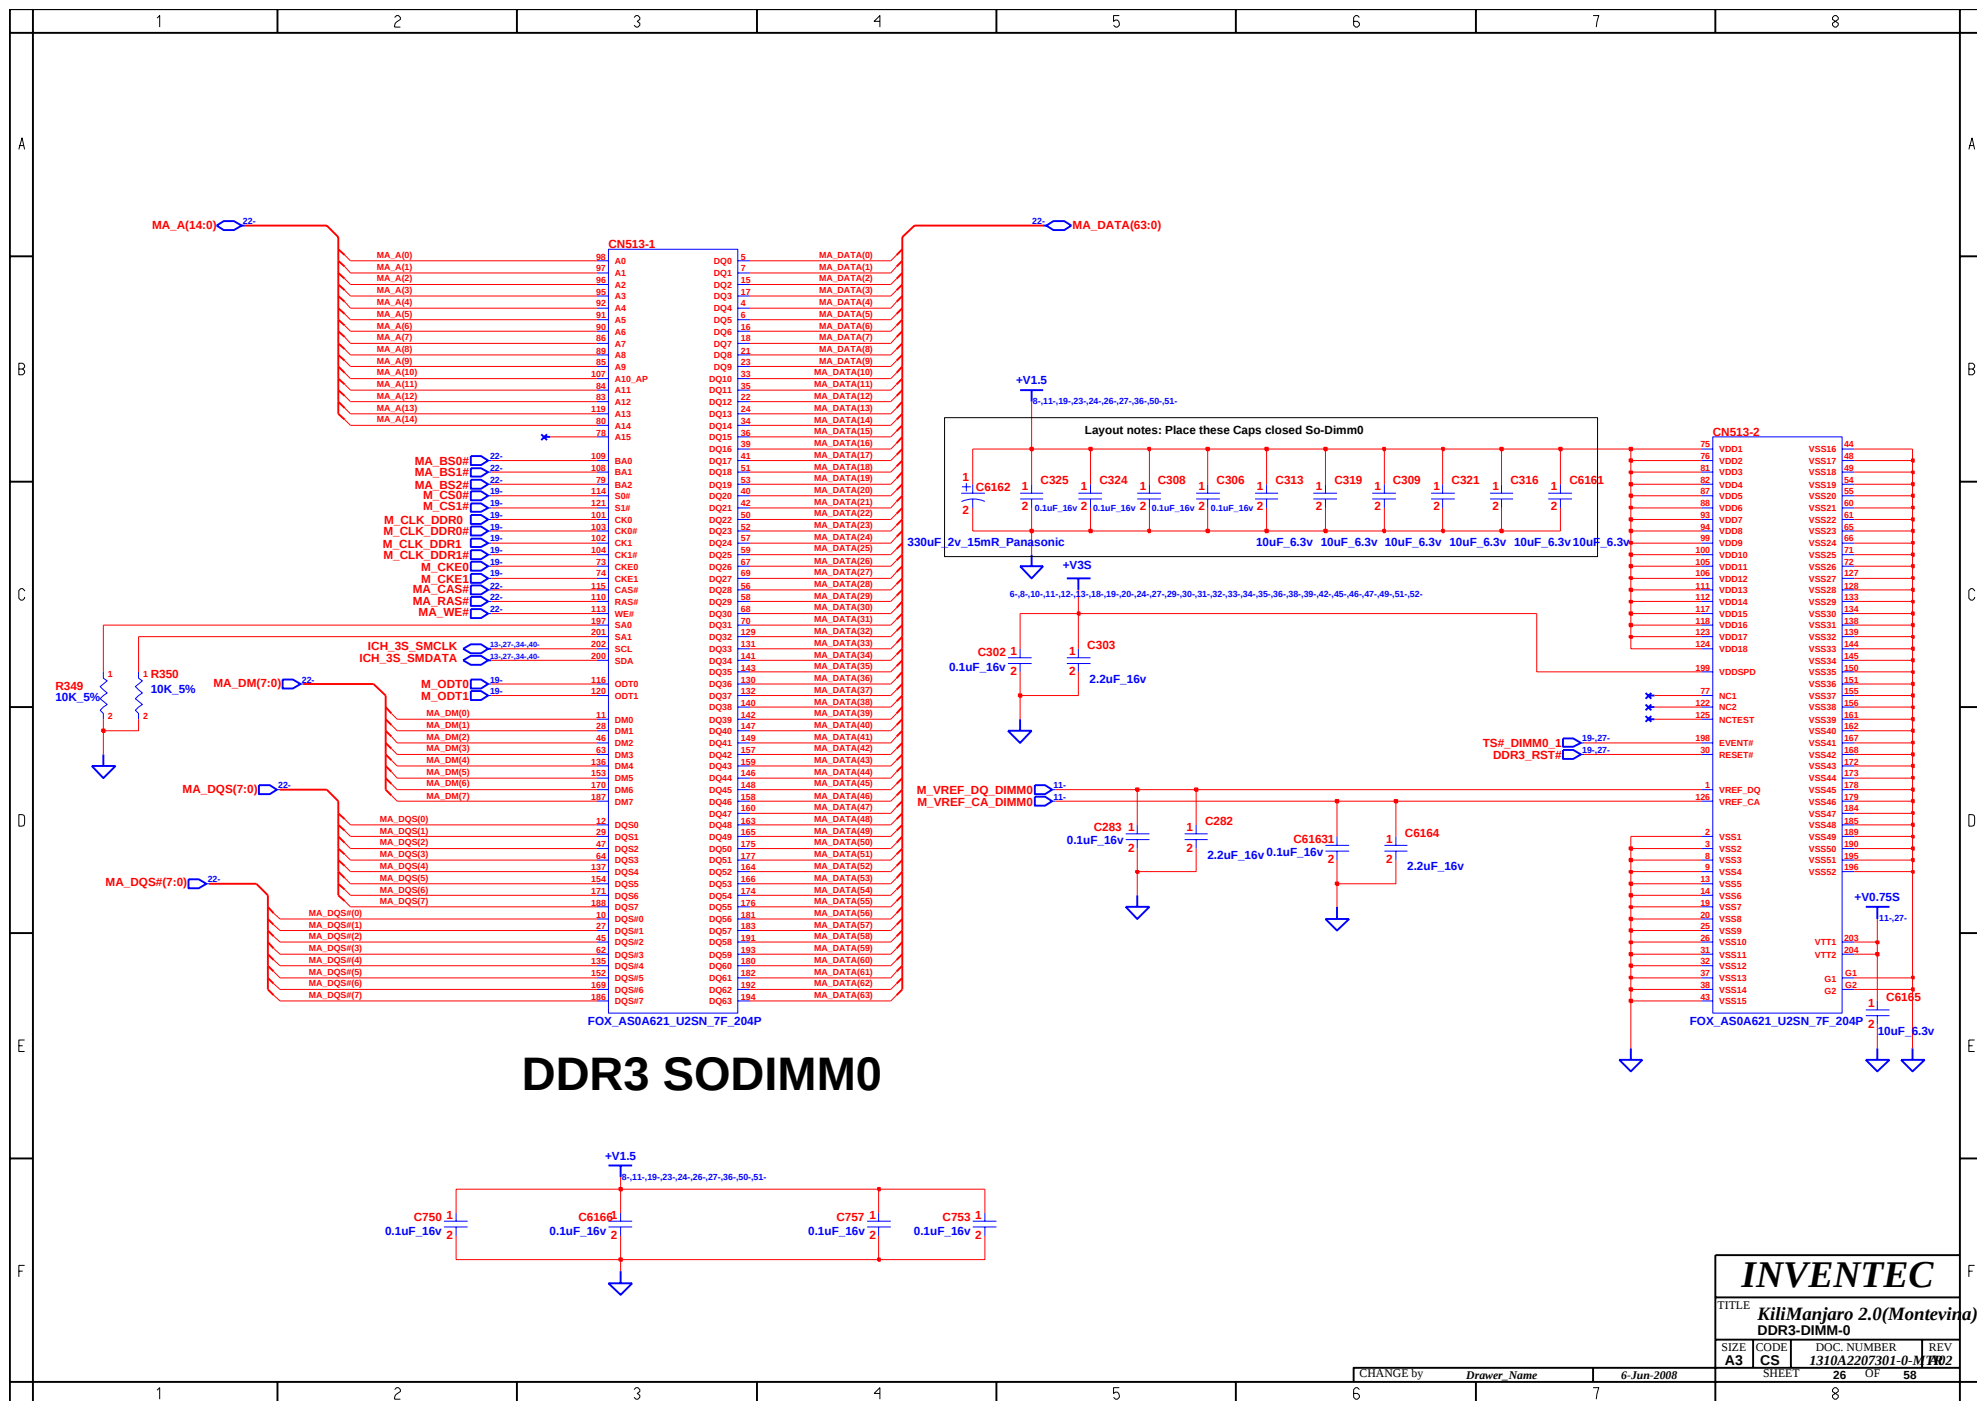



BLANK


INVENTEC			
TITLE KiliManjaro 2.0(Montevina)			
DDR2-DAMPING			
SIZE	CODE	DOC. NUMBER	REV
A3	CS	1310A2207301-0-M	#02
CHANGE by		Draver Name	6-Jun-2008
SHEET		28	OF 58

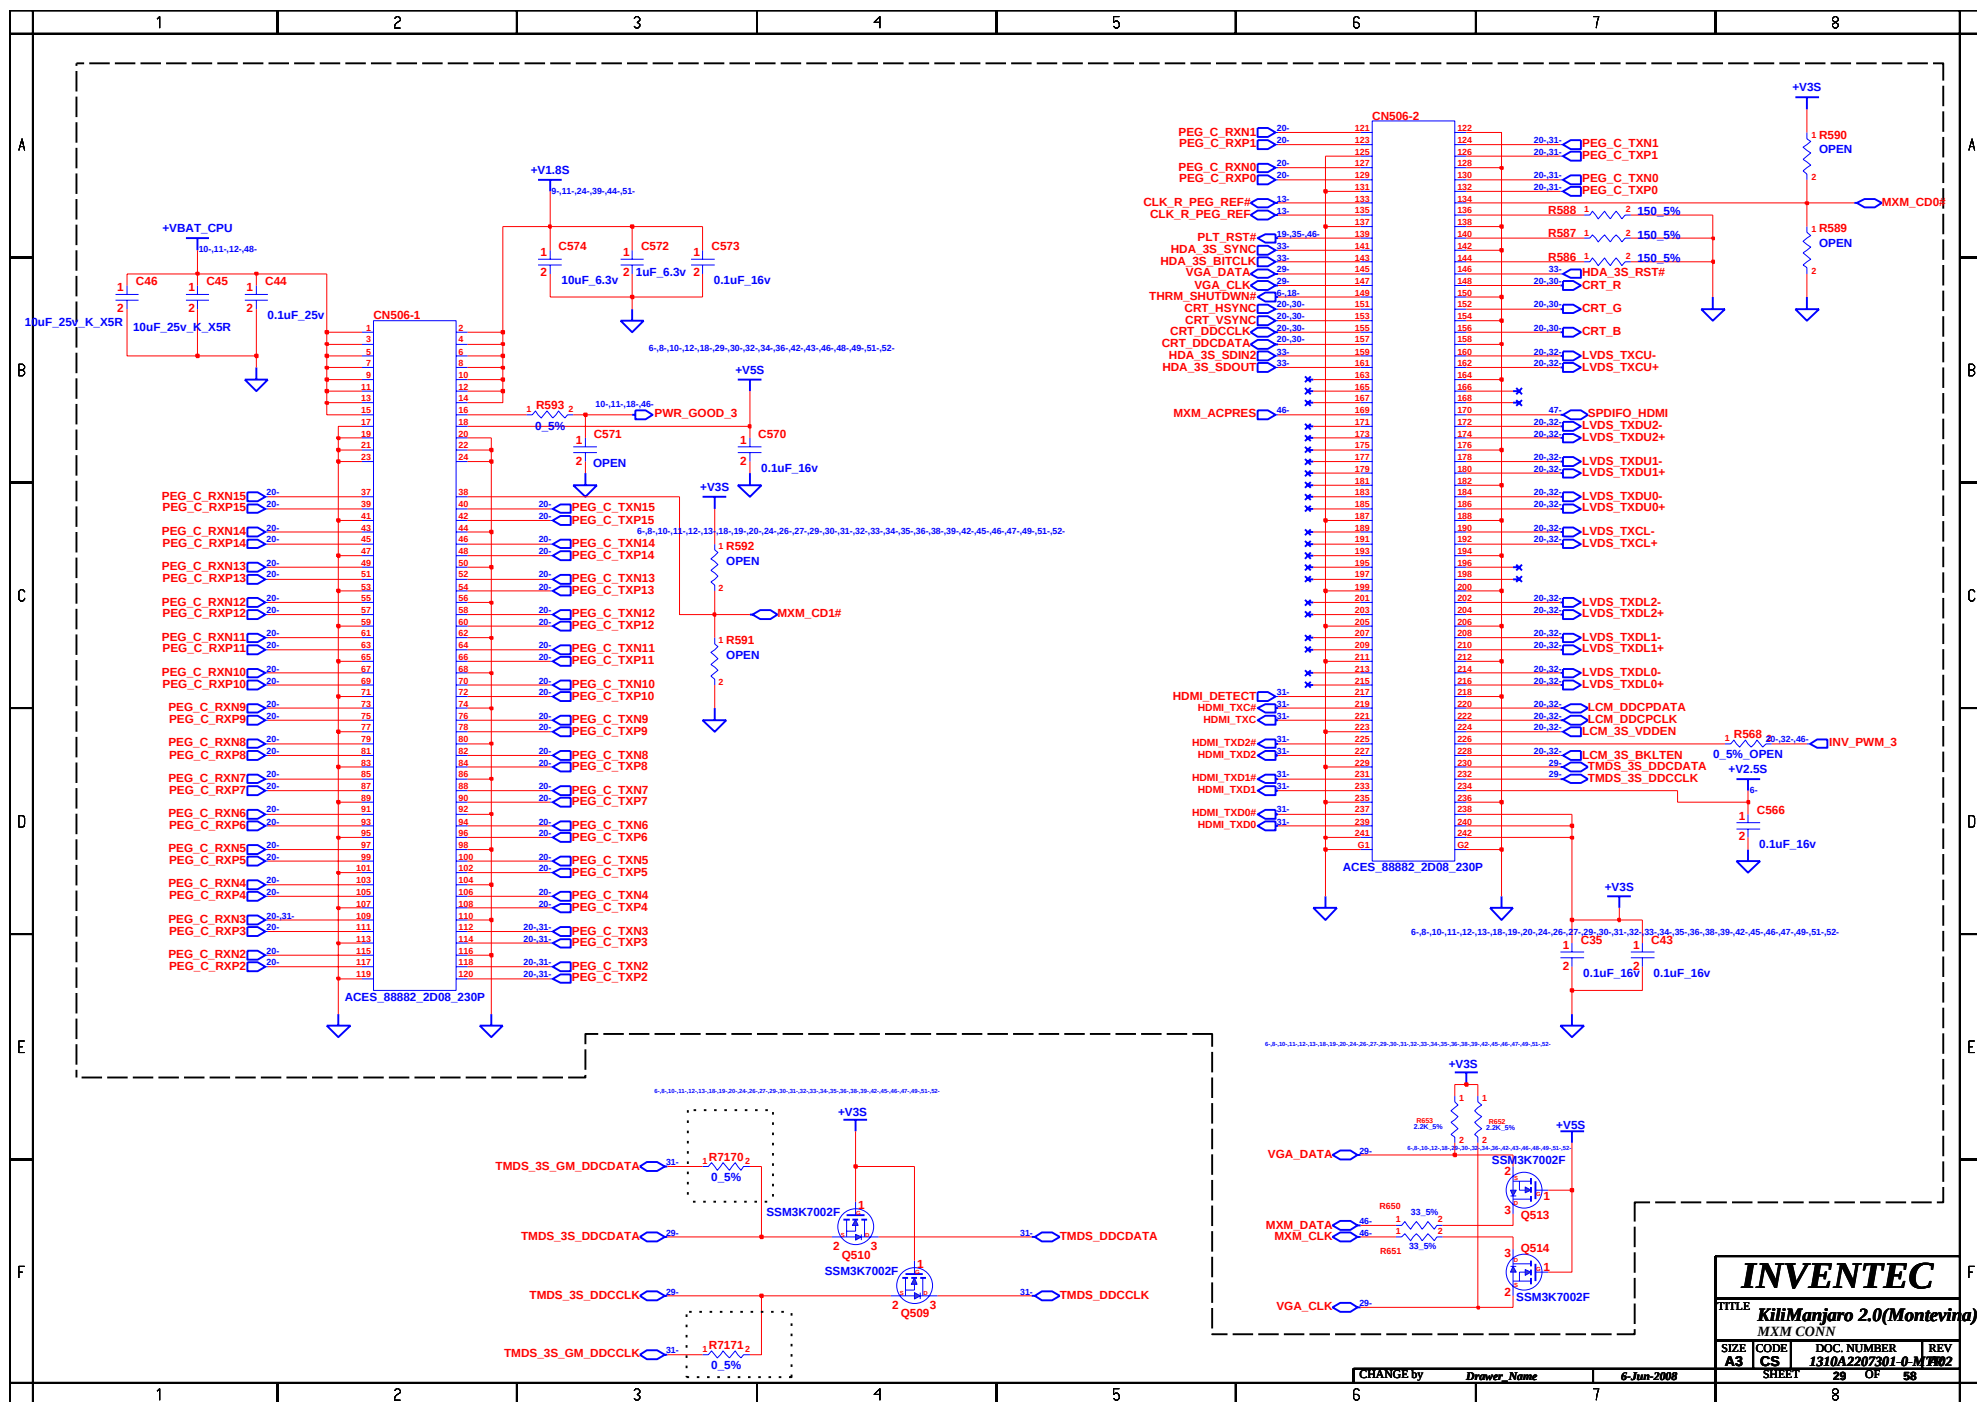


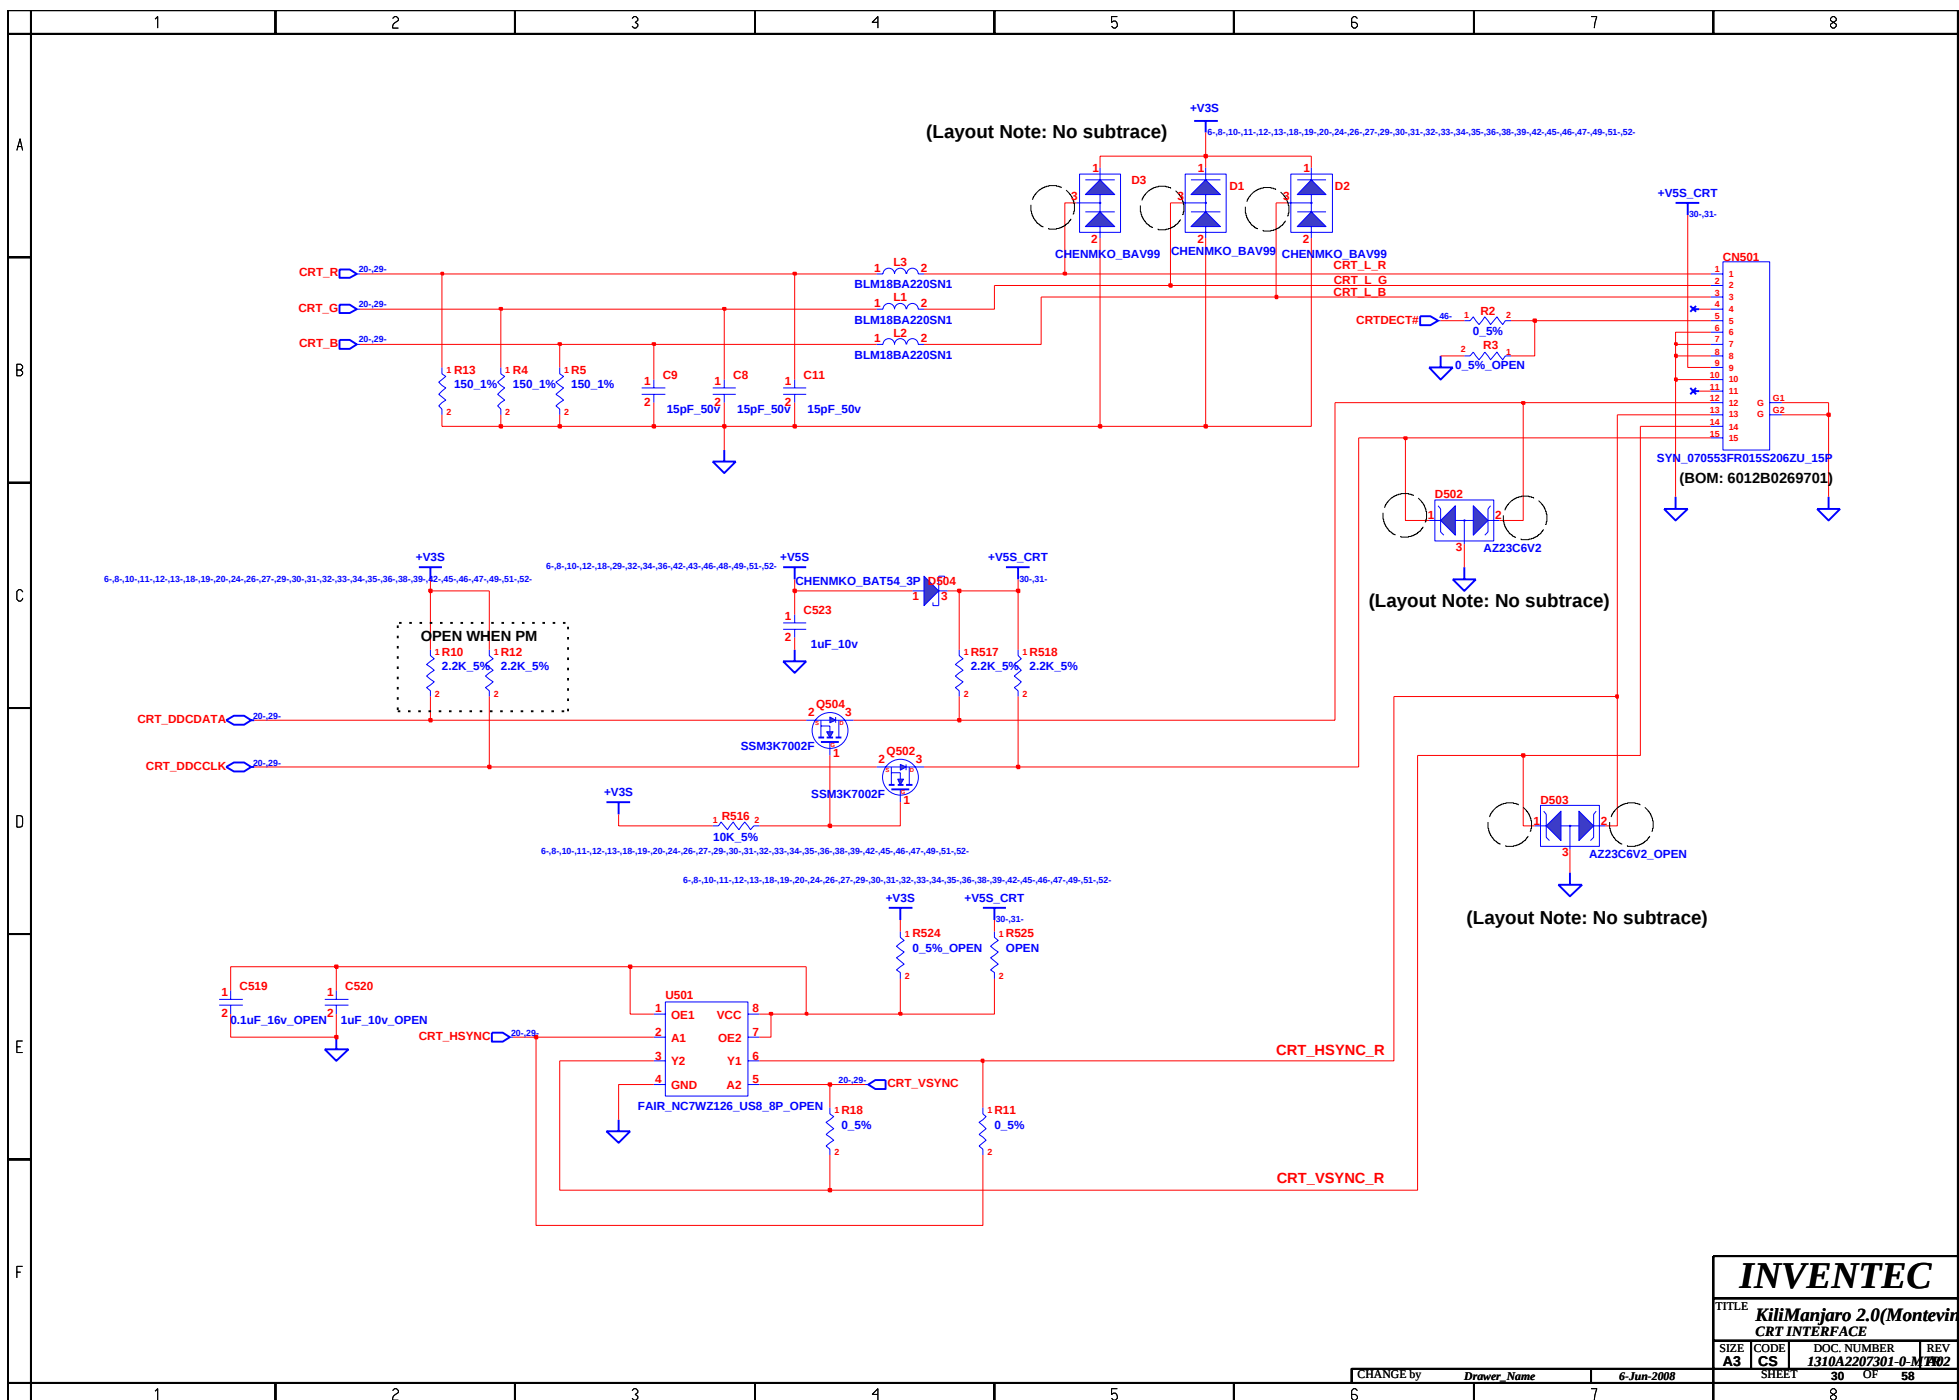


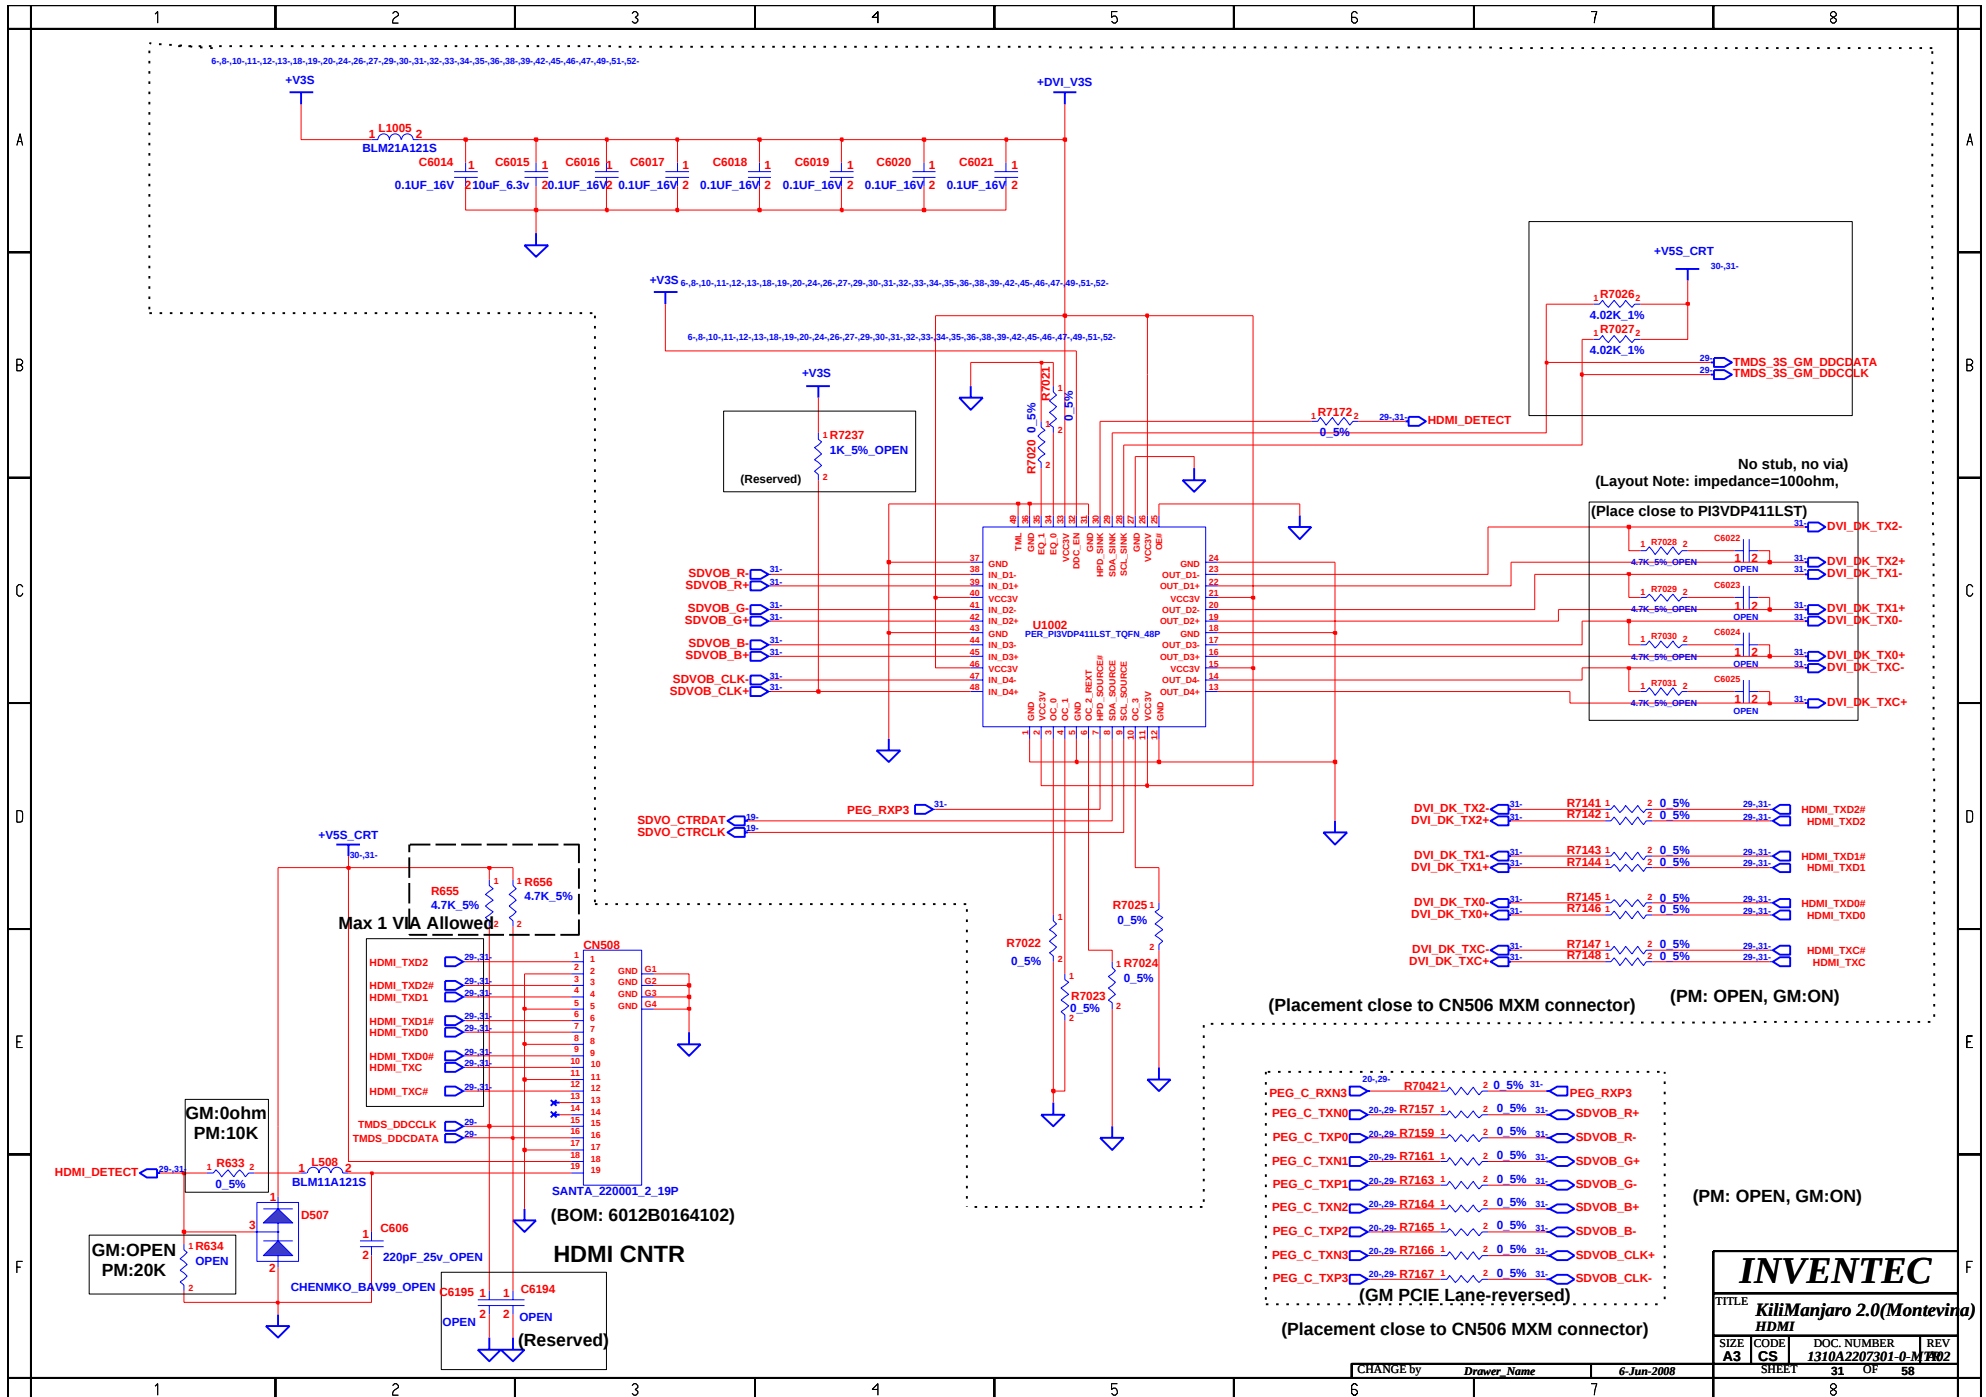


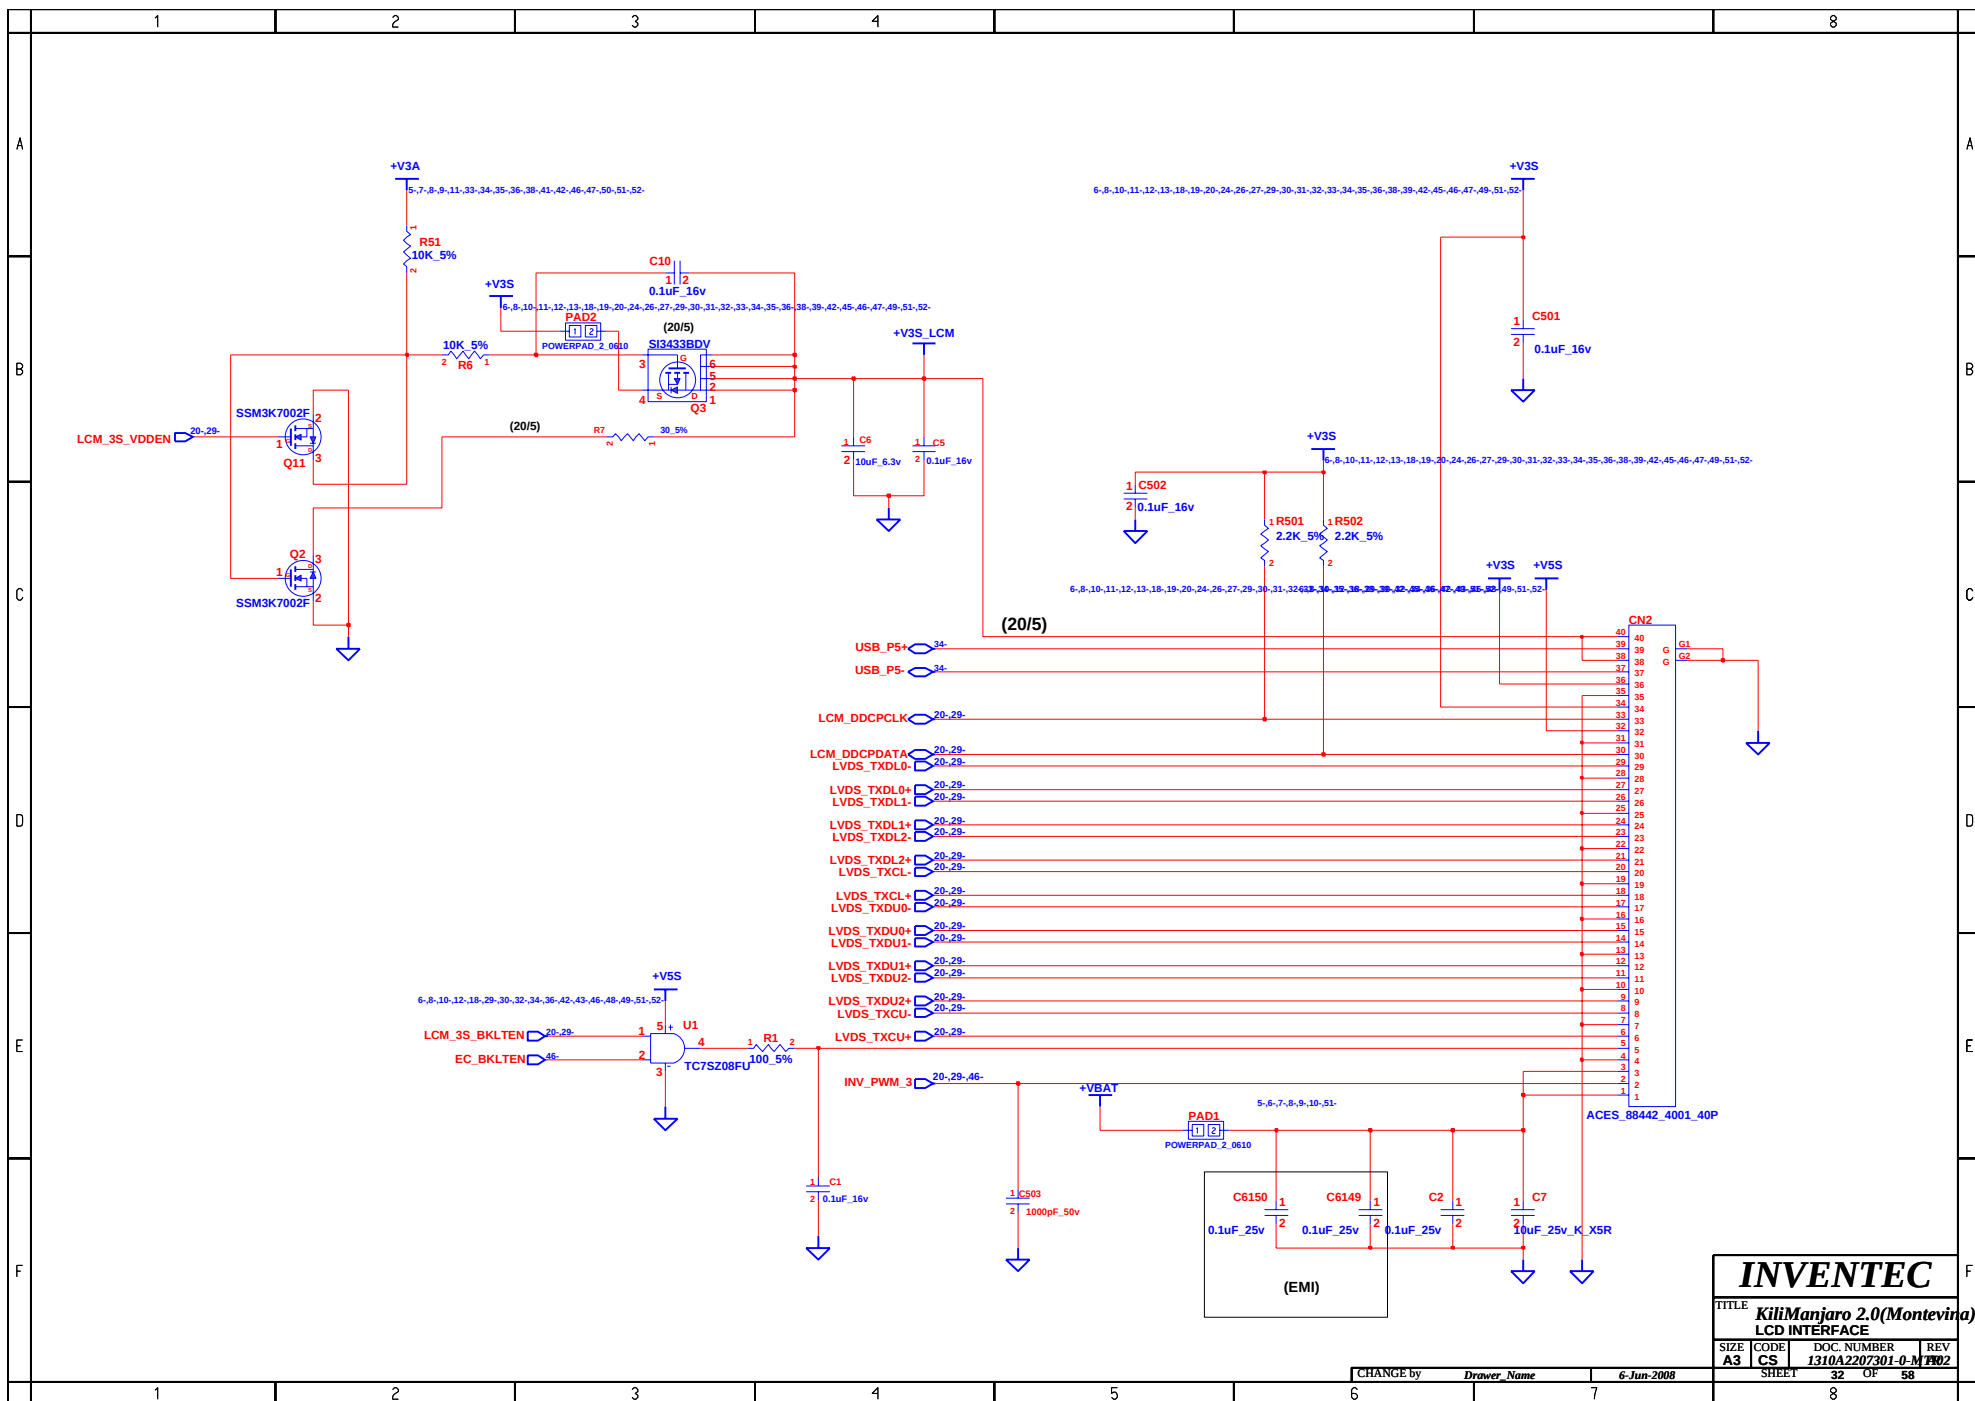

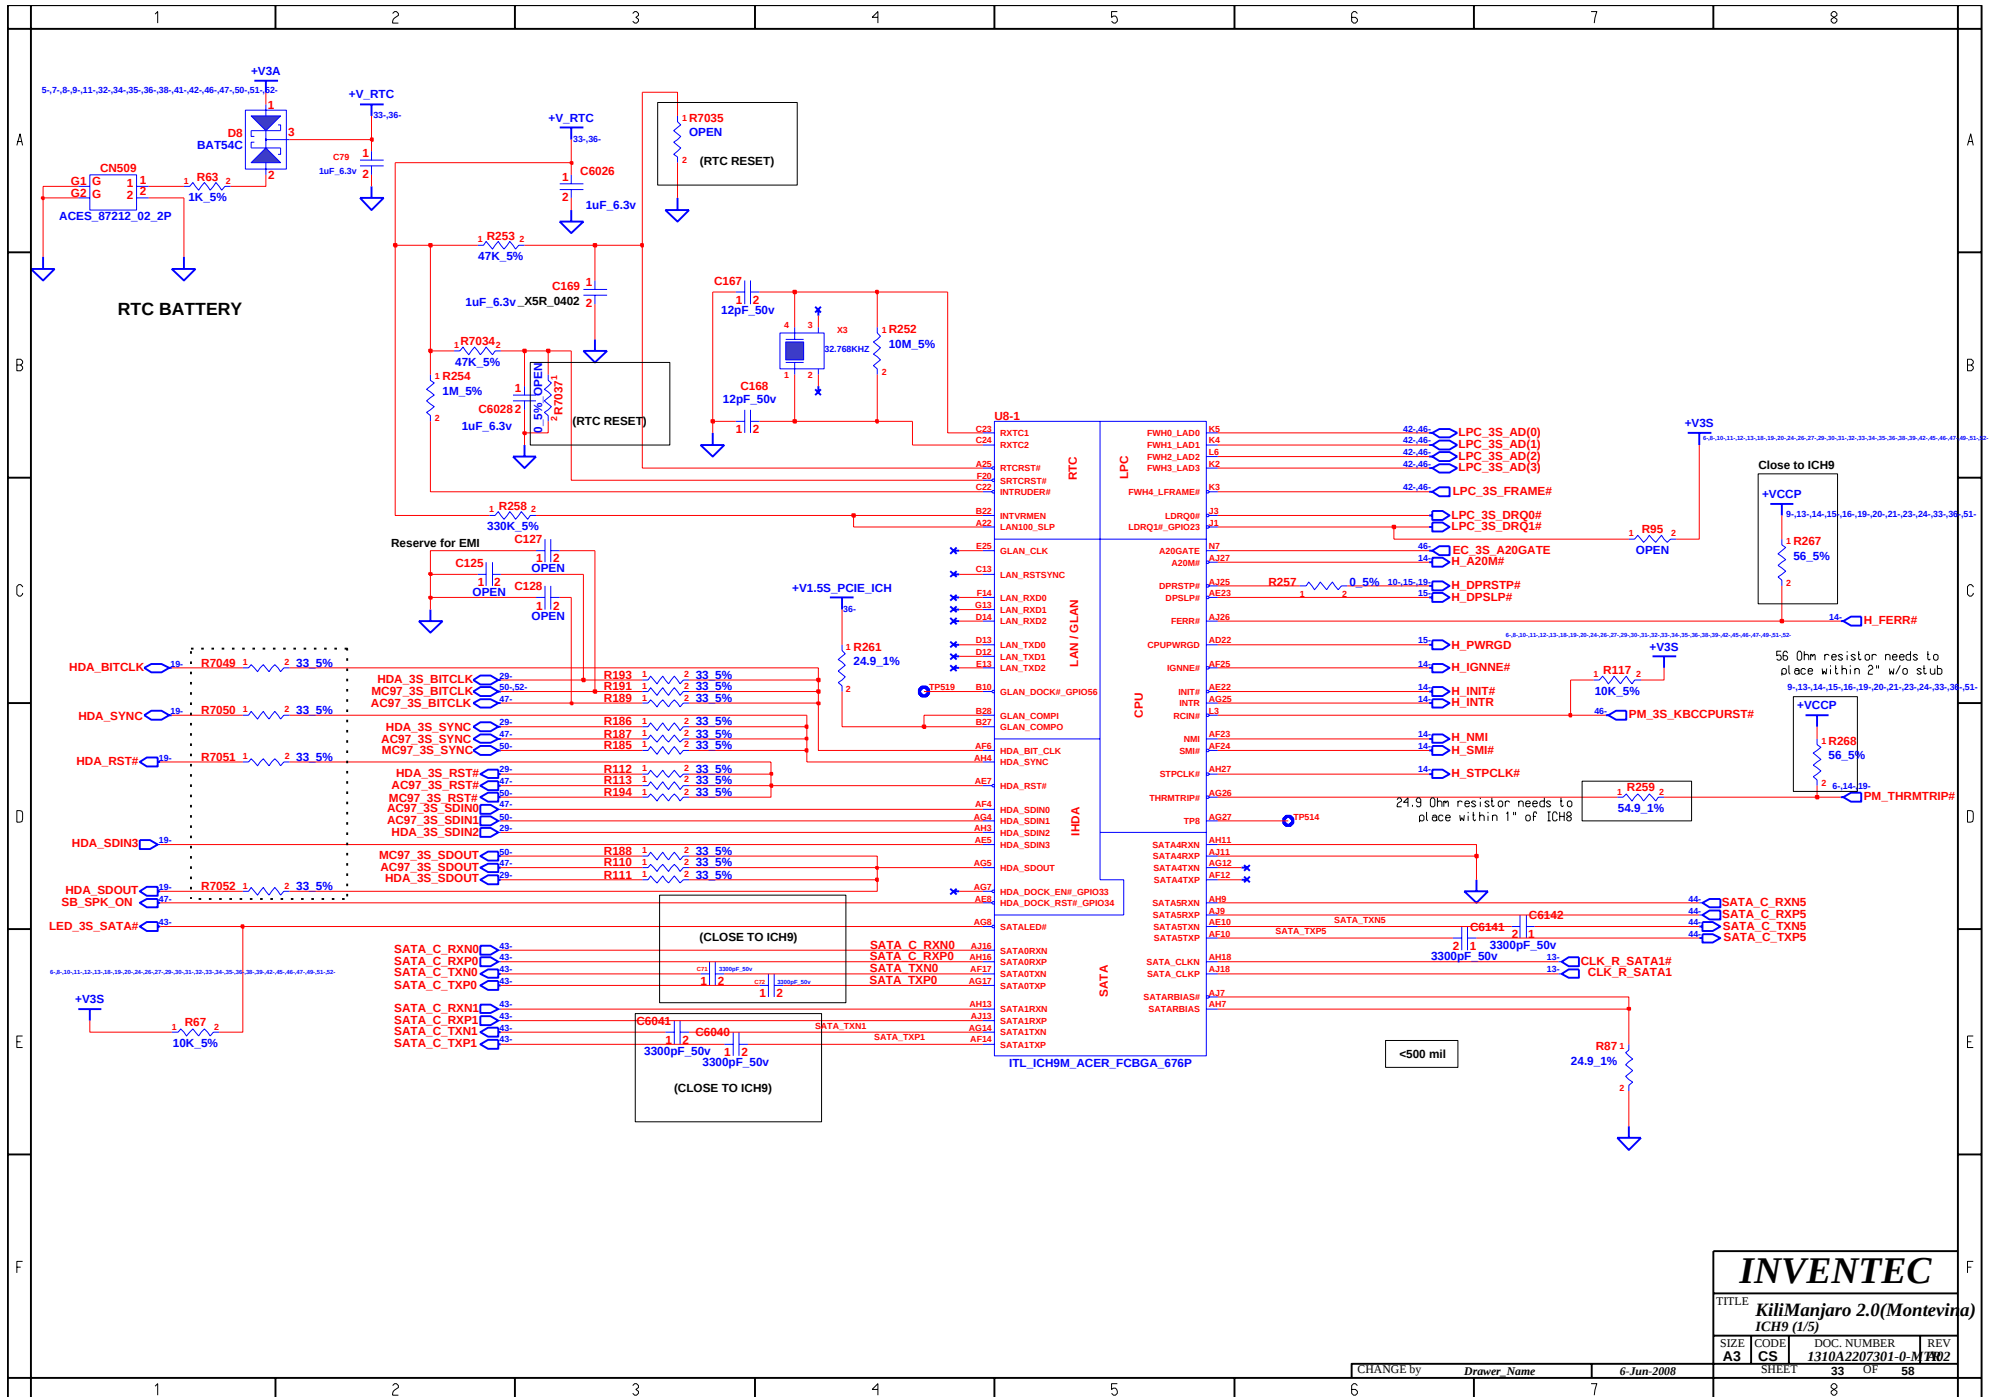

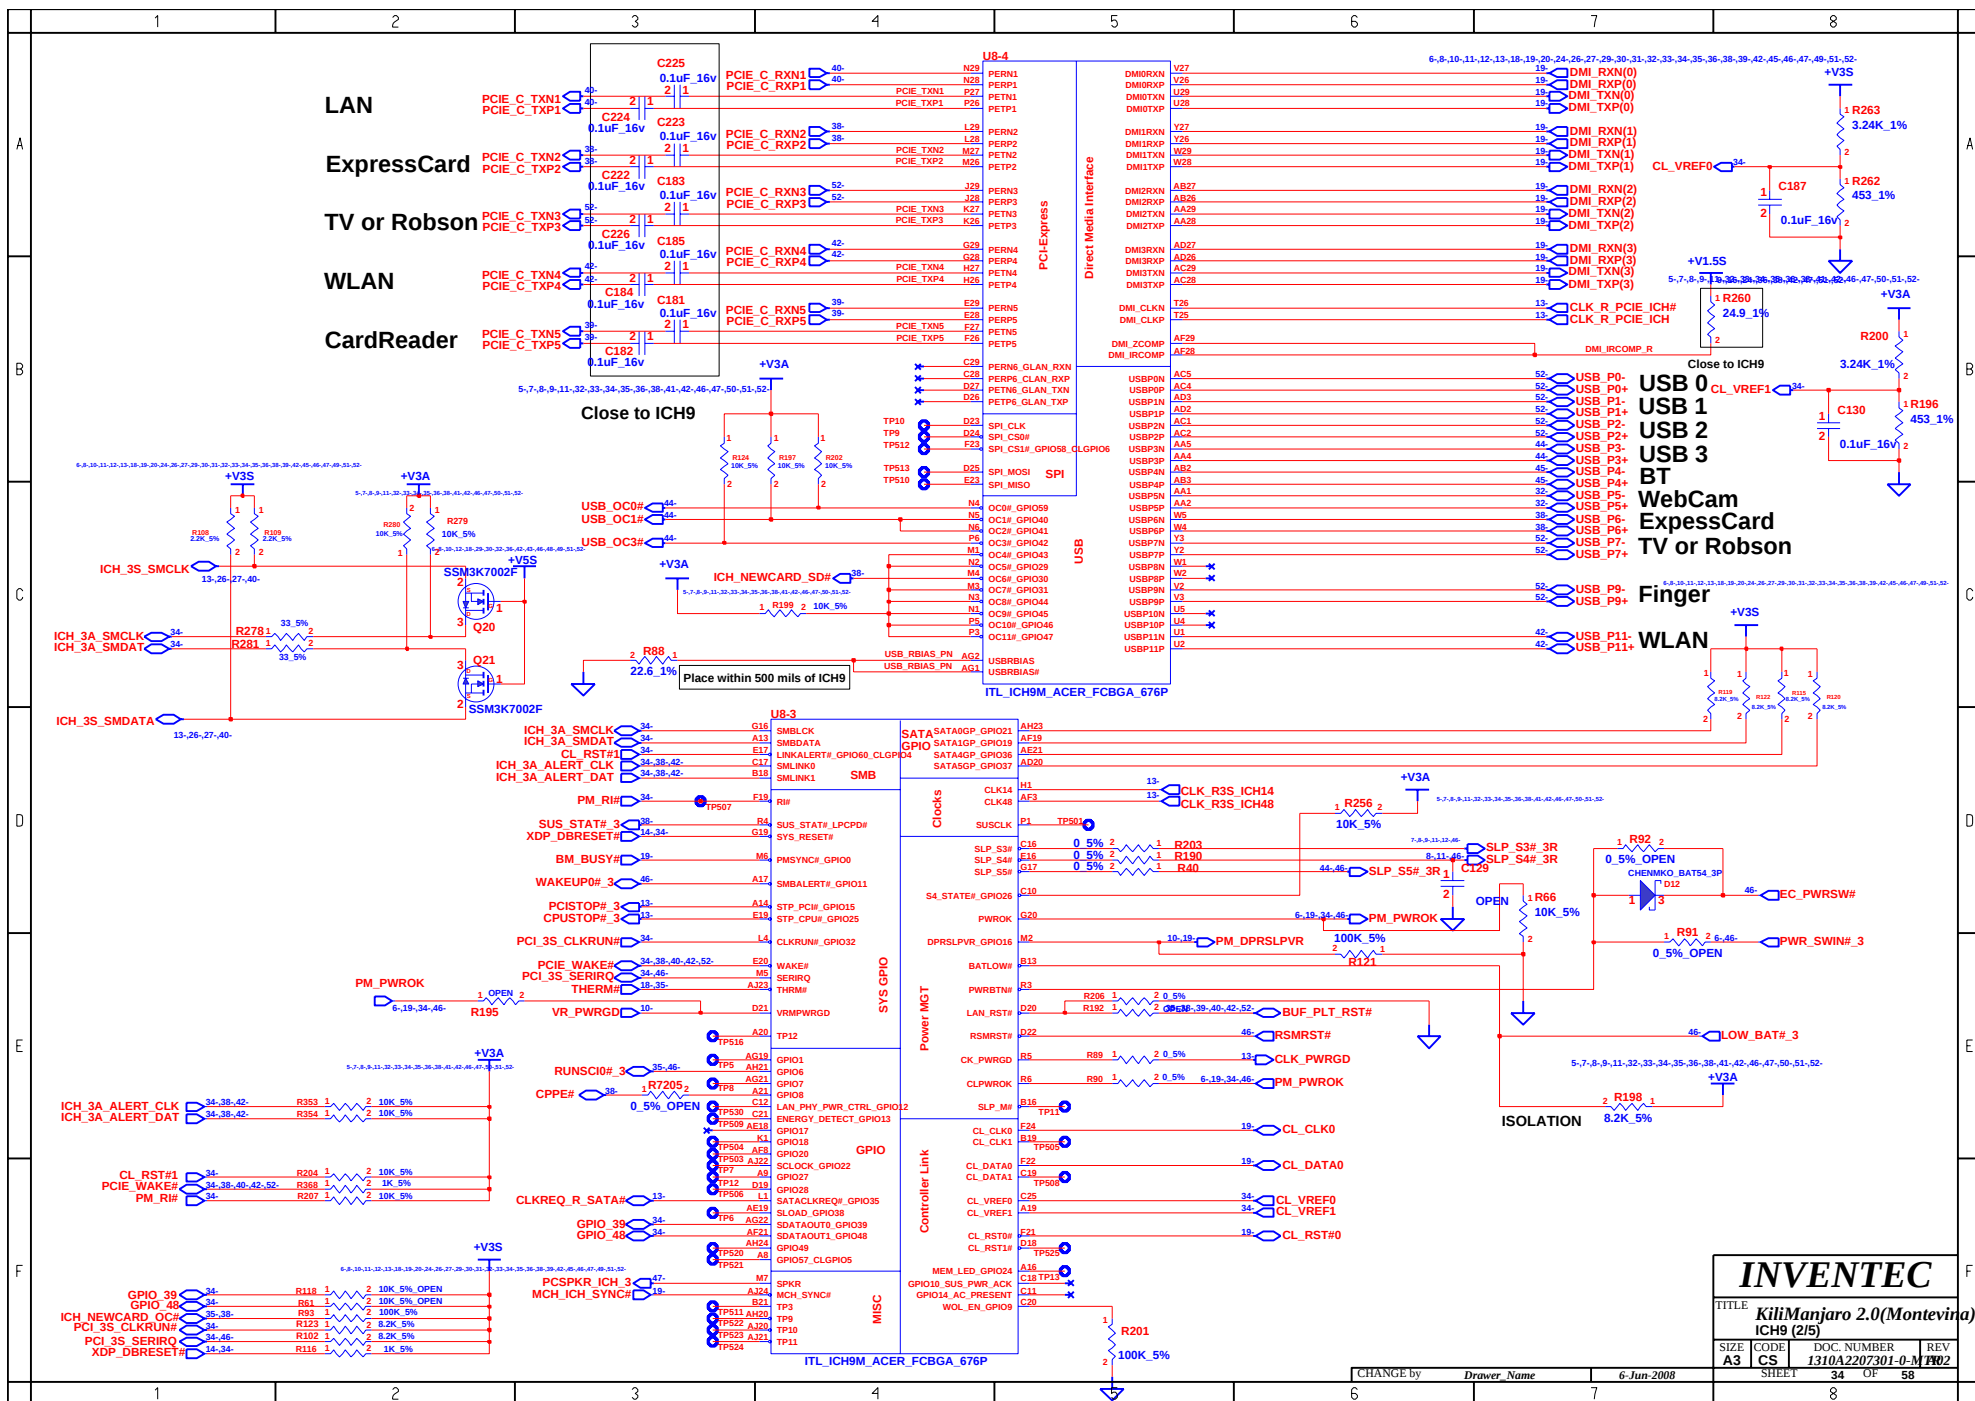

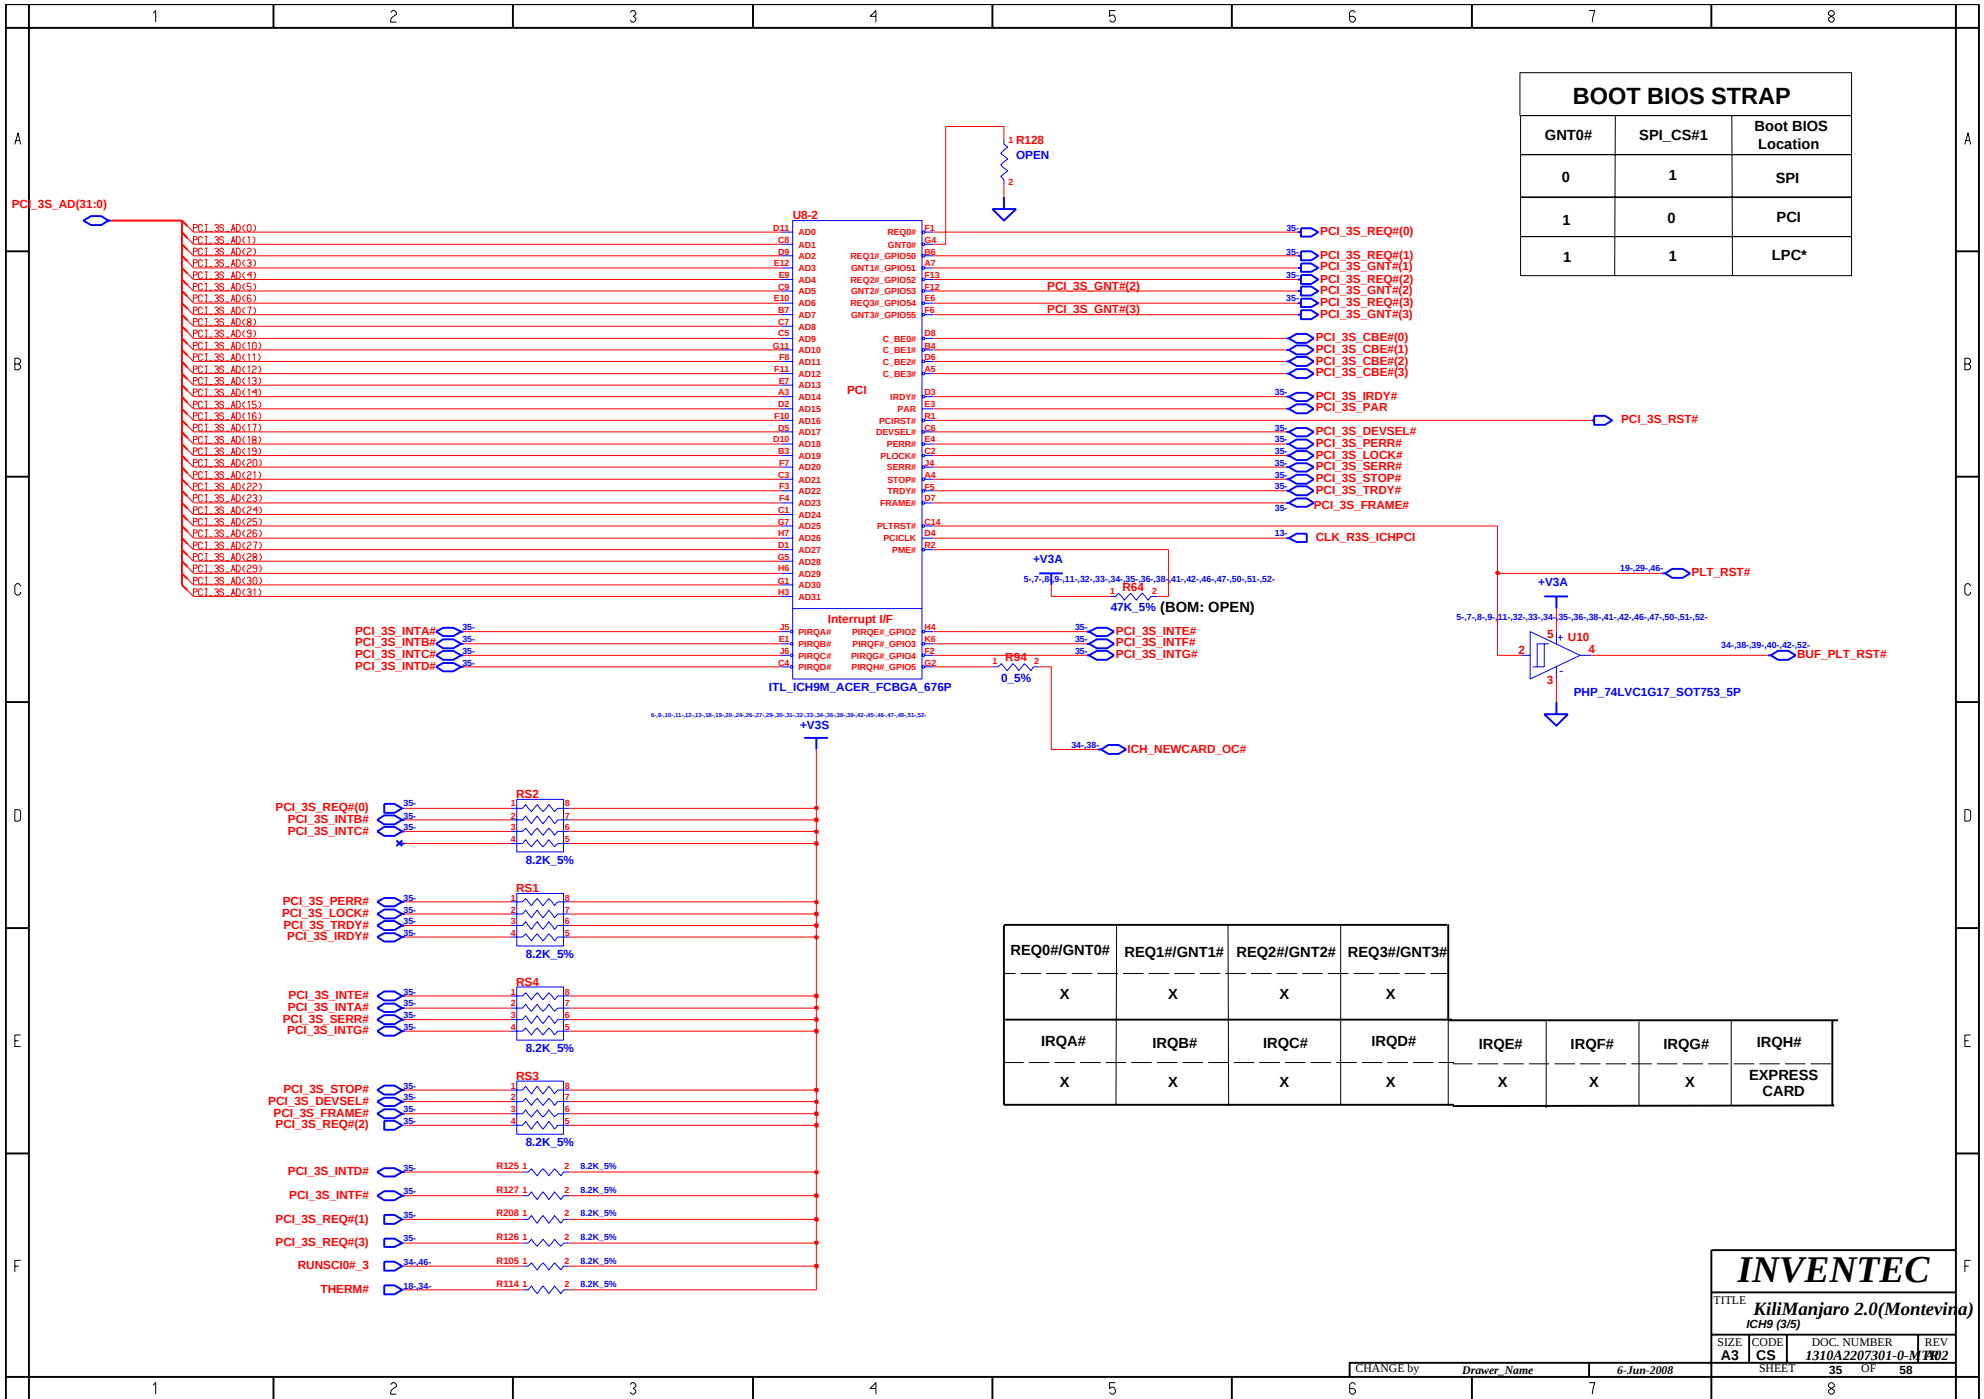

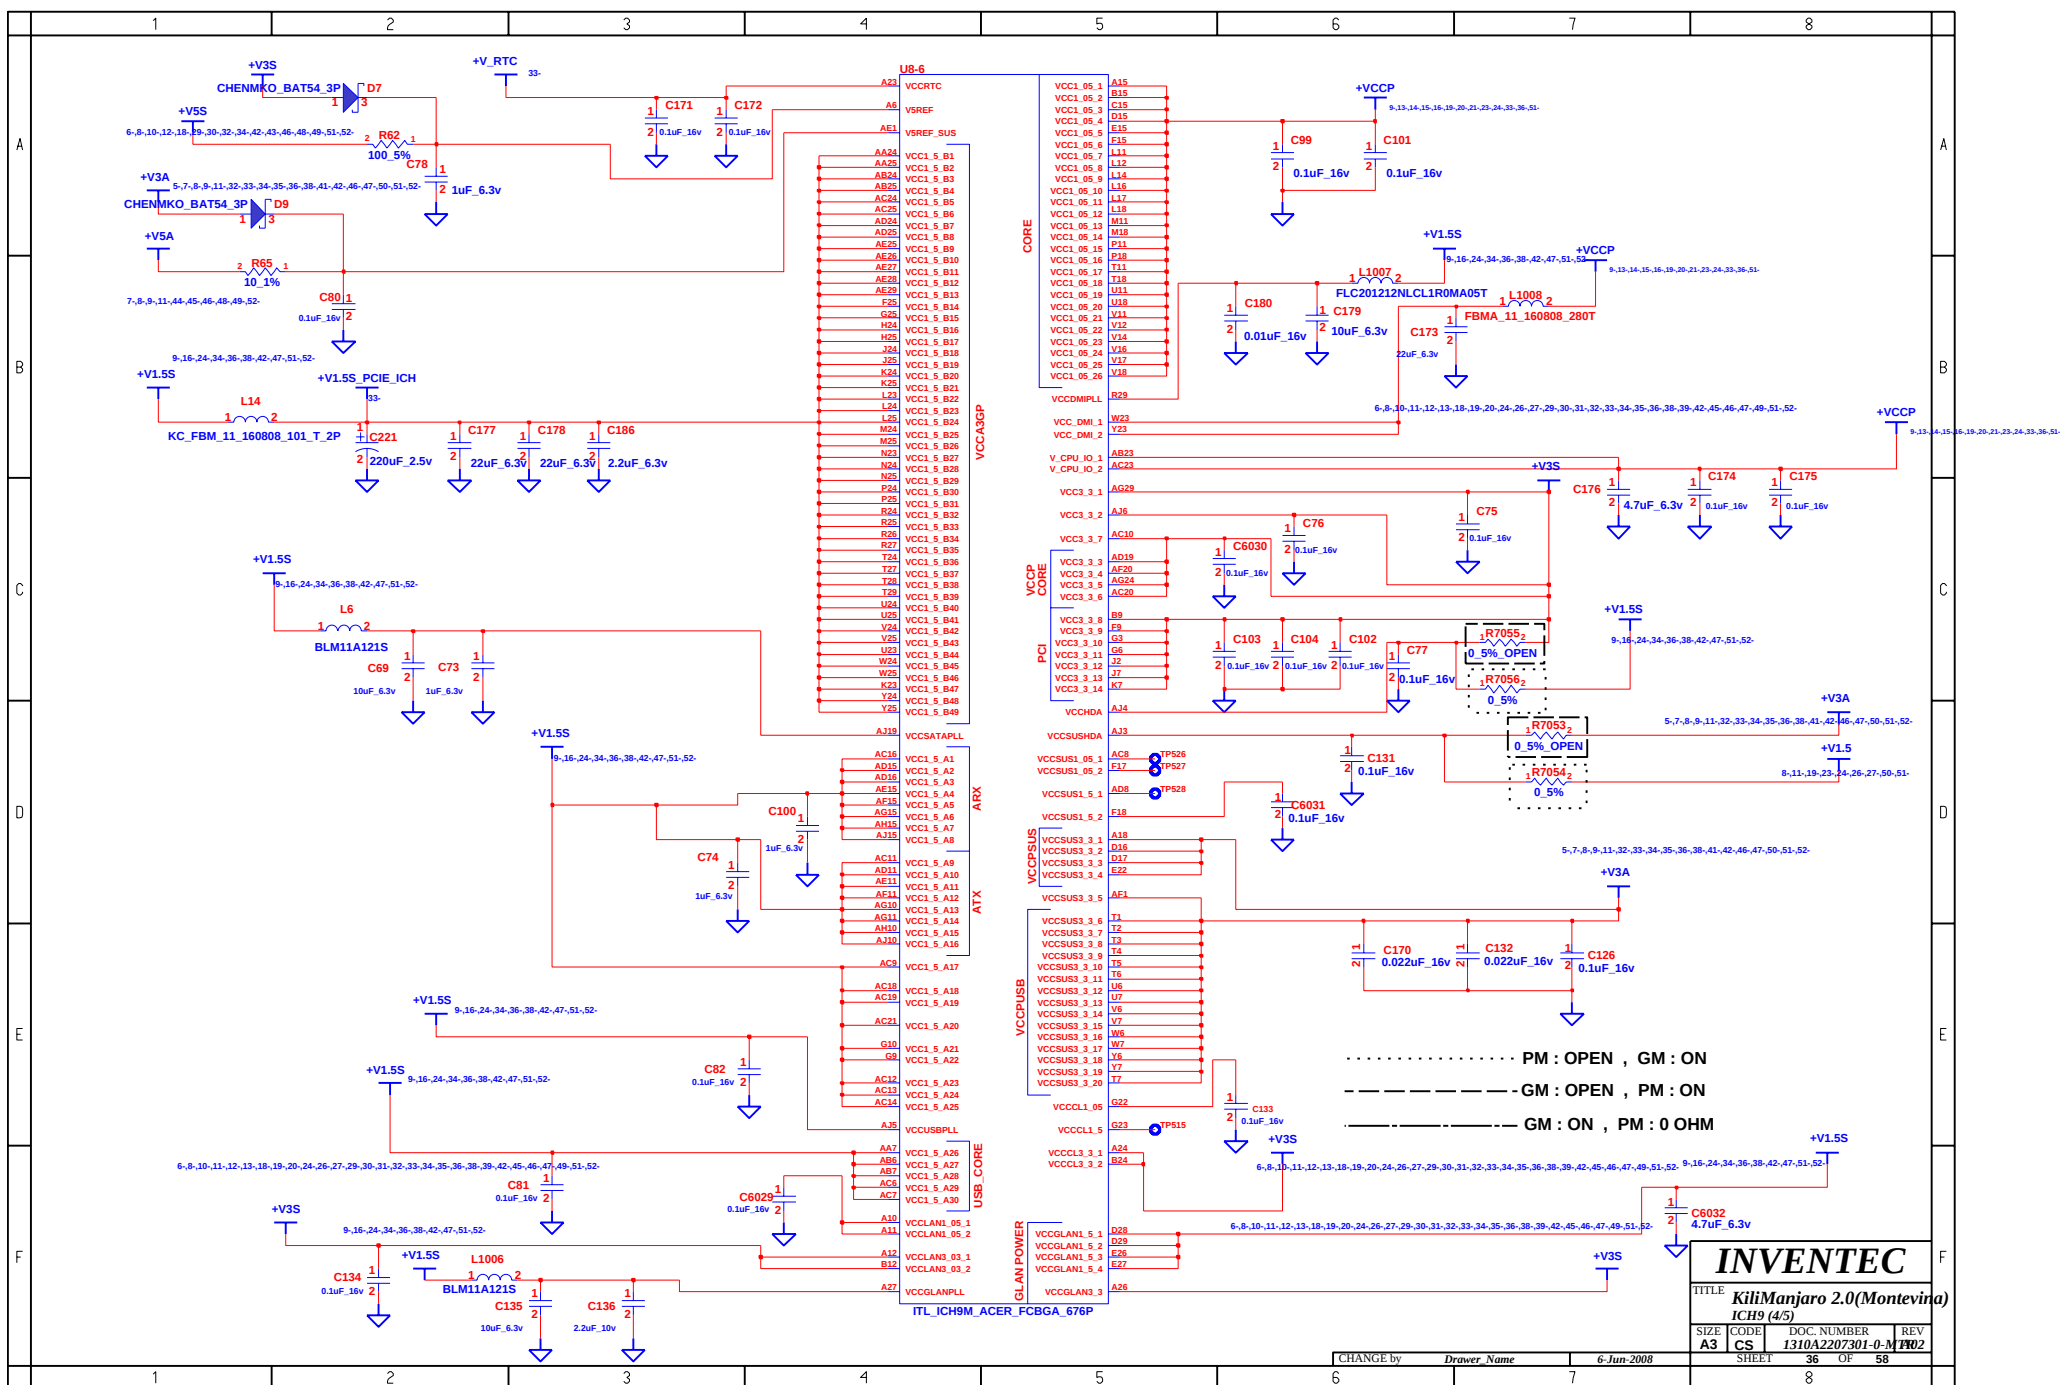

	1	2	3	4	5	6	7	8	
A	U8-5 AA26 VSS001 VSS107 H5 AA27 VSS002 VSS108 J23 AA31 VSS003 VSS109 J26 AA6 VSS004 VSS110 J27 AB1 VSS005 VSS111 AC22 AA22 VSS006 VSS112 K28 AB28 VSS007 VSS113 K29 AB29 VSS008 VSS114 L13 AB4 VSS009 VSS115 L15 AB5 VSS010 VSS116 L2 AC17 VSS011 VSS117 L27 AC26 VSS012 VSS118 L28 AC27 VSS013 VSS119 L5 AC3 VSS014 VSS120 L7 AD1 VSS015 VSS121 M12 AD10 VSS016 VSS122 M13 AD12 VSS017 VSS123 M14 AD13 VSS018 VSS124 M15 AD14 VSS019 VSS125 M16 AD17 VSS020 VSS126 M17 AD18 VSS021 VSS127 M23 AD21 VSS022 VSS128 M28 AD28 VSS023 VSS129 M29 AD29 VSS024 VSS130 N11 AD4 VSS025 VSS131 N12 AD6 VSS026 VSS132 N13 AD6 VSS027 VSS133 N14 AD7 VSS028 VSS134 N15 AD9 VSS029 VSS135 N16 AE12 VSS030 VSS136 N17 AE13 VSS031 VSS137 N18 AE14 VSS032 VSS138 N26 AE16 VSS033 VSS139 N27 AE17 VSS034 VSS140 P12 AE2 VSS035 VSS141 P13 AE20 VSS036 VSS142 P14 AE24 VSS037 VSS143 P15 AE3 VSS038 VSS144 P16 AE4 VSS039 VSS145 P17 AE6 VSS040 VSS146 P2 AE9 VSS041 VSS147 P21 AF13 VSS042 VSS148 P28 AF16 VSS043 VSS149 P29 AF18 VSS044 VSS150 P4 AF22 VSS045 VSS151 P7 AH06 VSS046 VSS152 R11 AF26 VSS047 VSS153 R12 AF27 VSS048 VSS154 R13 AF5 VSS049 VSS155 R14 AF7 VSS050 VSS156 R15 AF9 VSS051 VSS157 R16 AG13 VSS052 VSS158 R17 AG16 VSS053 VSS159 R18 AG18 VSS054 VSS160 R29 AG20 VSS055 VSS161 T12 AG23 VSS056 VSS162 T13 AG3 VSS057 VSS163 T14 AG6 VSS058 VSS164 T15 AG9 VSS059 VSS165 T16 AH12 VSS060 VSS166 T17 AH14 VSS061 VSS167 T21 AH17 VSS062 VSS168 B26 AH19 VSS063 VSS169 U12 AH2 VSS064 VSS170 U13 AH22 VSS065 VSS171 U14 AH25 VSS066 VSS172 U15 AH28 VSS067 VSS173 U16 AH5 VSS068 VSS174 U17 AH8 VSS069 VSS175 AD23 AJ12 VSS070 VSS176 U28 AJ14 VSS071 VSS177 U27 AJ17 VSS072 VSS178 U3 AJ8 VSS073 VSS179 V1 B11 VSS074 VSS180 V13 B14 VSS075 VSS181 V15 B17 VSS076 VSS182 V23 B2 VSS077 VSS183 V28 B20 VSS078 VSS184 V29 B23 VSS079 VSS185 V4 B5 VSS080 VSS186 V5 B8 VSS081 VSS187 W26 C26 VSS082 VSS188 W27 C27 VSS083 VSS189 W3 E11 VSS084 VSS190 V1 E14 VSS085 VSS191 V28 E18 VSS086 VSS192 V29 E2 VSS087 VSS193 V4 E21 VSS088 VSS194 Y5 E24 VSS089 VSS195 AG28 E3 VSS090 VSS196 AH6 E8 VSS091 VSS197 AF2 F16 VSS092 VSS198 B25 F28 VSS093 F29 VSS094 VSS_NCTF1 A1 G12 VSS095 VSS_NCTF2 A2 G14 VSS096 VSS_NCTF3 A28 G18 VSS097 VSS_NCTF4 A29 G21 VSS098 VSS_NCTF5 AH1 G24 VSS099 VSS_NCTF6 AH29 G26 VSS100 VSS_NCTF7 AJ1 G27 VSS101 VSS_NCTF8 AJ2 G8 VSS102 VSS_NCTF9 AJ28 H2 VSS103 VSS_NCTF10 AJ29 H23 VSS104 VSS_NCTF11 B1 H28 VSS105 VSS_NCTF12 B29 H29 VSS106 ITL_ICHM_ACER_FCBGA_676P								
B									B
C									C
D									D
E									E
F									F

CHANGE by				Drawer Name				6-Jun-2008			
SHEET				37				OF 58			


INVENTEC			
TITLE KiliManjaro 2.0(Montevina)			
ICH9 (S/S)			
SIZE A3	CODE CS	DOC. NUMBER 1310A2207301-0-M	REV 102


U8-5

AA26 VSS001 VSS107 H5
AA27 VSS002 VSS108 J23
AA3 VSS003 VSS109 J26
AA6 VSS004 VSS110 J27
AB1 VSS005 VSS111 AC22
AA23 VSS006 VSS112 K28
AB28 VSS007 VSS113 K29
AB29 VSS008 VSS114 L13
AB4 VSS009 VSS115 L15
AB5 VSS010 VSS116 L2
AC17 VSS011 VSS117 L26
AC26 VSS012 VSS118 L27
AC27 VSS013 VSS119 L5
AC3 VSS014 VSS120 L7
AD1 VSS015 VSS121 M12
AD10 VSS016 VSS122 M13
AD12 VSS017 VSS123 M14
AD13 VSS018 VSS124 M15
AD14 VSS019 VSS125 M16
AD17 VSS020 VSS126 M17
AD18 VSS021 VSS127 M23
AD21 VSS022 VSS128 M28
AD28 VSS023 VSS129 M29
AD29 VSS024 VSS130 M11
AD4 VSS025 VSS131 M12
AD5 VSS026 VSS132 M13
AD6 VSS027 VSS133 M14
AD7 VSS028 VSS134 M15
AD9 VSS029 VSS135 M16
AE14 VSS030 VSS136 M17
AE13 VSS031 VSS137 M18
AE14 VSS032 VSS138 M26
AE16 VSS033 VSS139 M27
AE17 VSS034 VSS140 P12
AE2 VSS035 VSS141 P13
AE20 VSS036 VSS142 P14
AE24 VSS037 VSS143 P15
AE3 VSS038 VSS144 P16
AE4 VSS039 VSS145 P17
AE6 VSS040 VSS146 P2
AE9 VSS041 VSS147 P23
AF13 VSS042 VSS148 P28
AF16 VSS043 VSS149 P29
AF18 VSS044 VSS150 P4
AF2 VSS045 VSS151 P7
AH26 VSS046 VSS152 R11
AF26 VSS047 VSS153 R12
AF27 VSS048 VSS154 R13
AF5 VSS049 VSS155 R14
AF7 VSS050 VSS156 R15
AF9 VSS051 VSS157 R16
AG13 VSS052 VSS158 R17
AG16 VSS053 VSS159 R18
AG18 VSS054 VSS160 R28
AG20 VSS055 VSS161 T12
AG23 VSS056 VSS162 T13
AG3 VSS057 VSS163 T14
AG6 VSS058 VSS164 T15
AG9 VSS059 VSS165 T16
AH12 VSS060 VSS166 T17
AH14 VSS061 VSS167 T23
AH17 VSS062 VSS168 B26
AH18 VSS063 VSS169 U12
AH2 VSS064 VSS170 U13
AH22 VSS065 VSS171 U14
AH25 VSS066 VSS172 U15
AH26 VSS067 VSS173 U16
AH5 VSS068 VSS174 AD23
AH8 VSS069 VSS175 U17
AJ12 VSS070 VSS176 U26
AJ14 VSS071 VSS177 U27
AJ17 VSS072 VSS178 U3
AJ8 VSS073 VSS179 V1
B11 VSS074 VSS180 V13
B14 VSS075 VSS181 V15
B17 VSS076 VSS182 V23
B2 VSS077 VSS183 V28
B20 VSS078 VSS184 V29
B23 VSS079 VSS185 V4
B5 VSS080 VSS186 V5
B8 VSS081 VSS187 W26
C26 VSS082 VSS188 W27
C27 VSS083 VSS189 W3
E11 VSS084 VSS190 V1
E14 VSS085 VSS191 Y28
E18 VSS086 VSS192 Y29
E2 VSS087 VSS193 V4
E21 VSS088 VSS194 V5
E24 VSS089 VSS195 AG28
E9 VSS090 VSS196 AH6
F8 VSS091 VSS197 AF2
F16 VSS092 VSS198 B25
F28 VSS093
F29 VSS094 VSS_NCTF3 A1
G12 VSS095 VSS_NCTF3 A2
G14 VSS096 VSS_NCTF3 A28
G18 VSS097 VSS_NCTF4 A29
G24 VSS098 VSS_NCTF5 AH1
G25 VSS099 VSS_NCTF4 AH29
G26 VSS100 VSS_NCTF7 A1
G27 VSS101 VSS_NCTF8 A32
G8 VSS102 VSS_NCTF9 A328
H2 VSS103 VSS_NCTF10 A329
H23 VSS104 VSS_NCTF11 B1
H28 VSS105 VSS_NCTF12 B29
H29 VSS106

ITL_ICH9M_ACER_FCBGA_676P


INVENTEC			
TITLE <i>KiliManjaro 2.0(Montevina)</i>			
ICH9 (5/5)			
SIZE A3	CODE CS	DOC. NUMBER <i>1310A2207301-0-M</i>	REV #02
SHEET 37		OF 58	

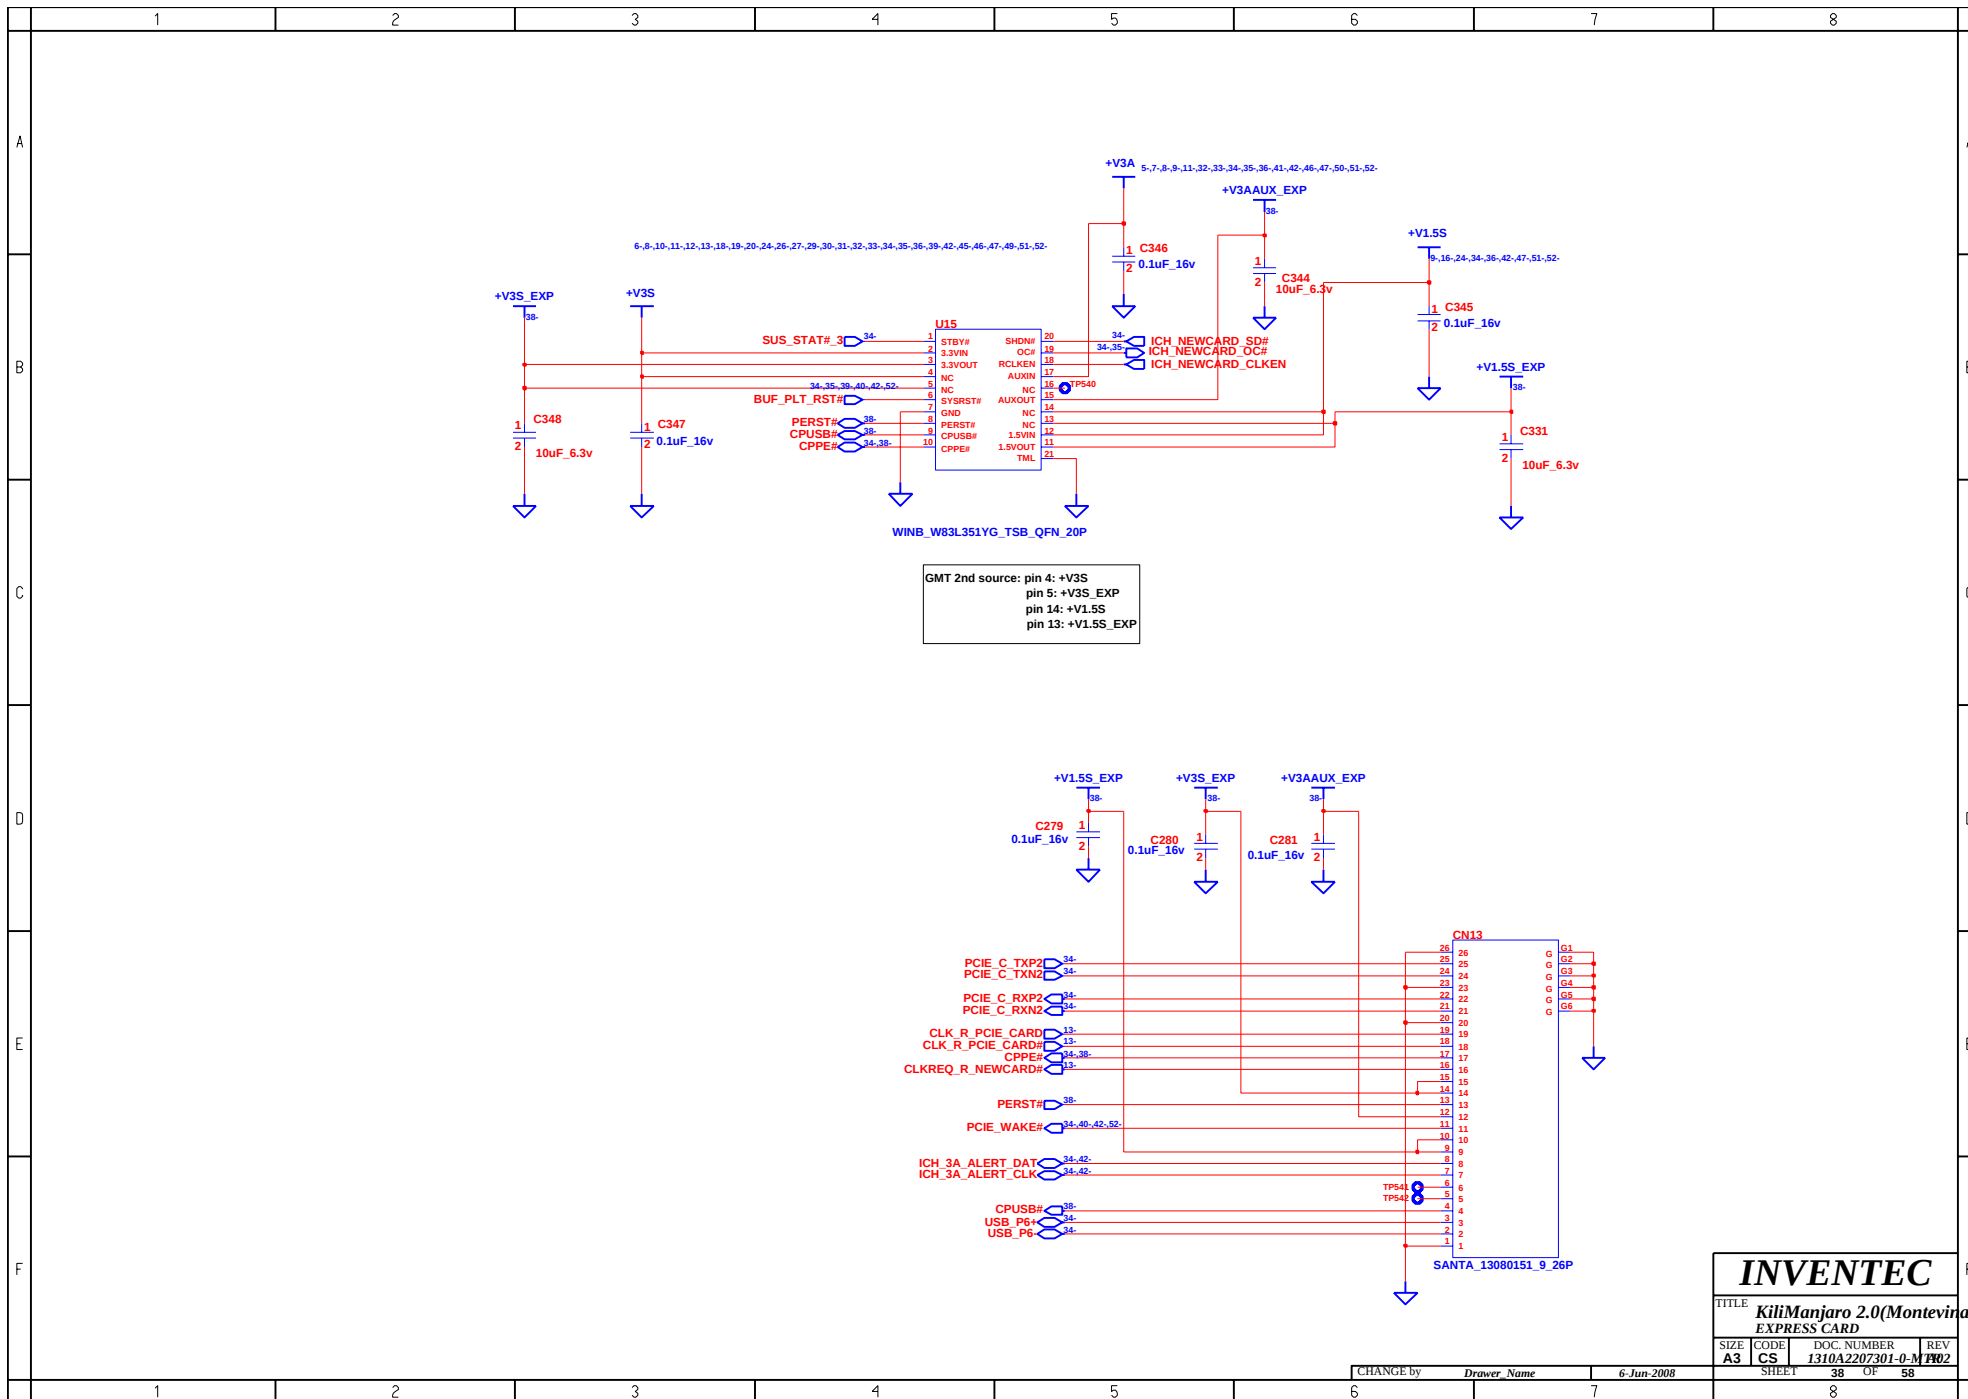

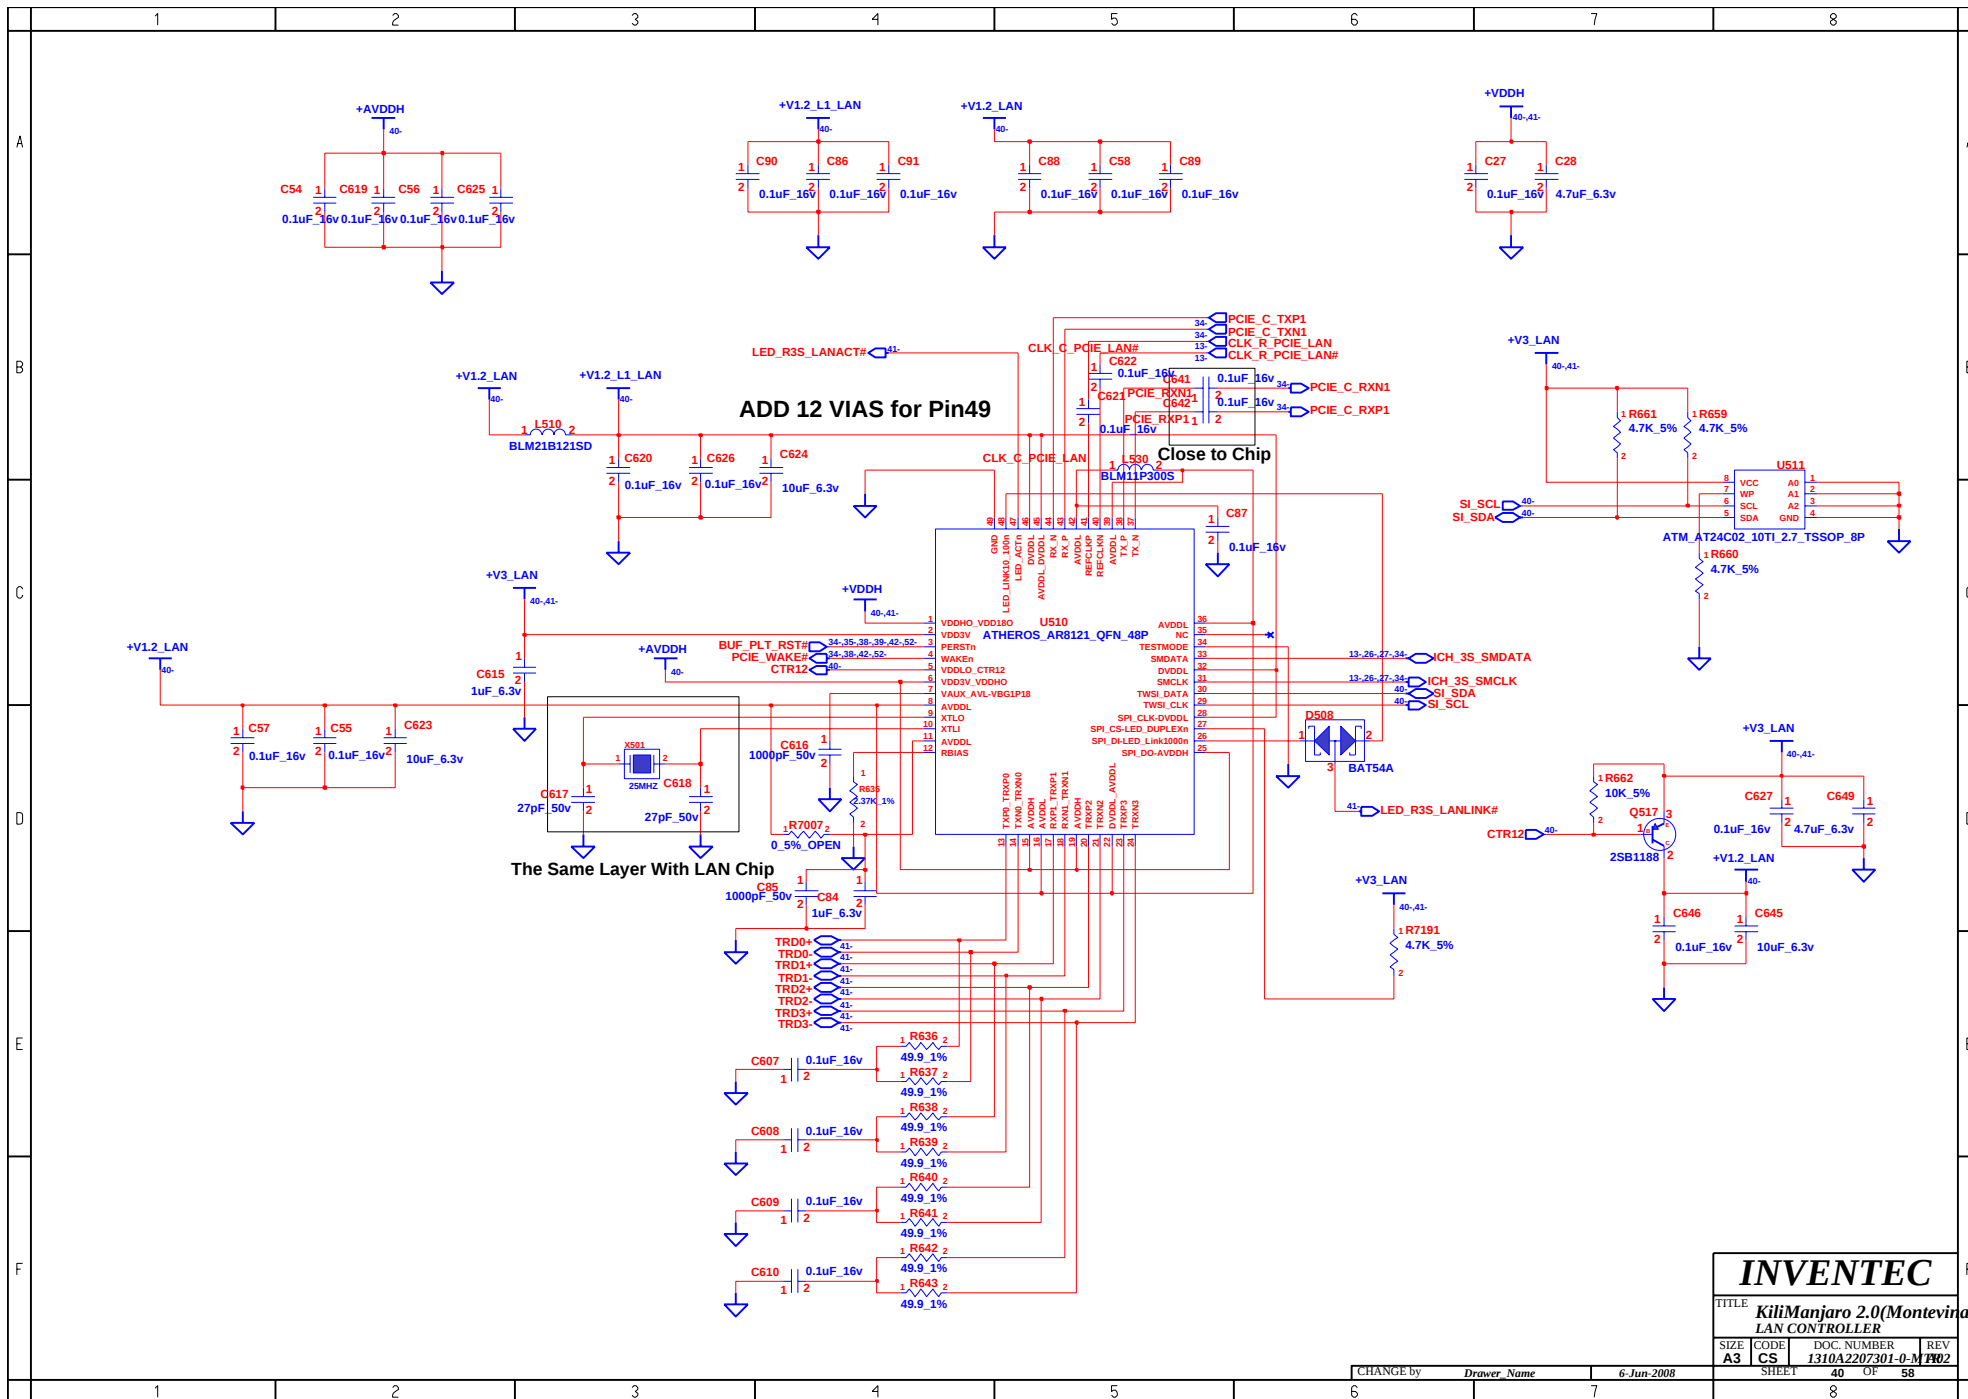


INVENTEC			
TITLE: KiliManjaro 2.0(Montevina)			
LAN CONTROLLER			
SIZE: A3	CODE: CS	DOC. NUMBER: 1310A2207301-0-M	REV: 02
SHEET: 40		OF: 58	


CHANGE by: Drawer Name 6-Jun-2008

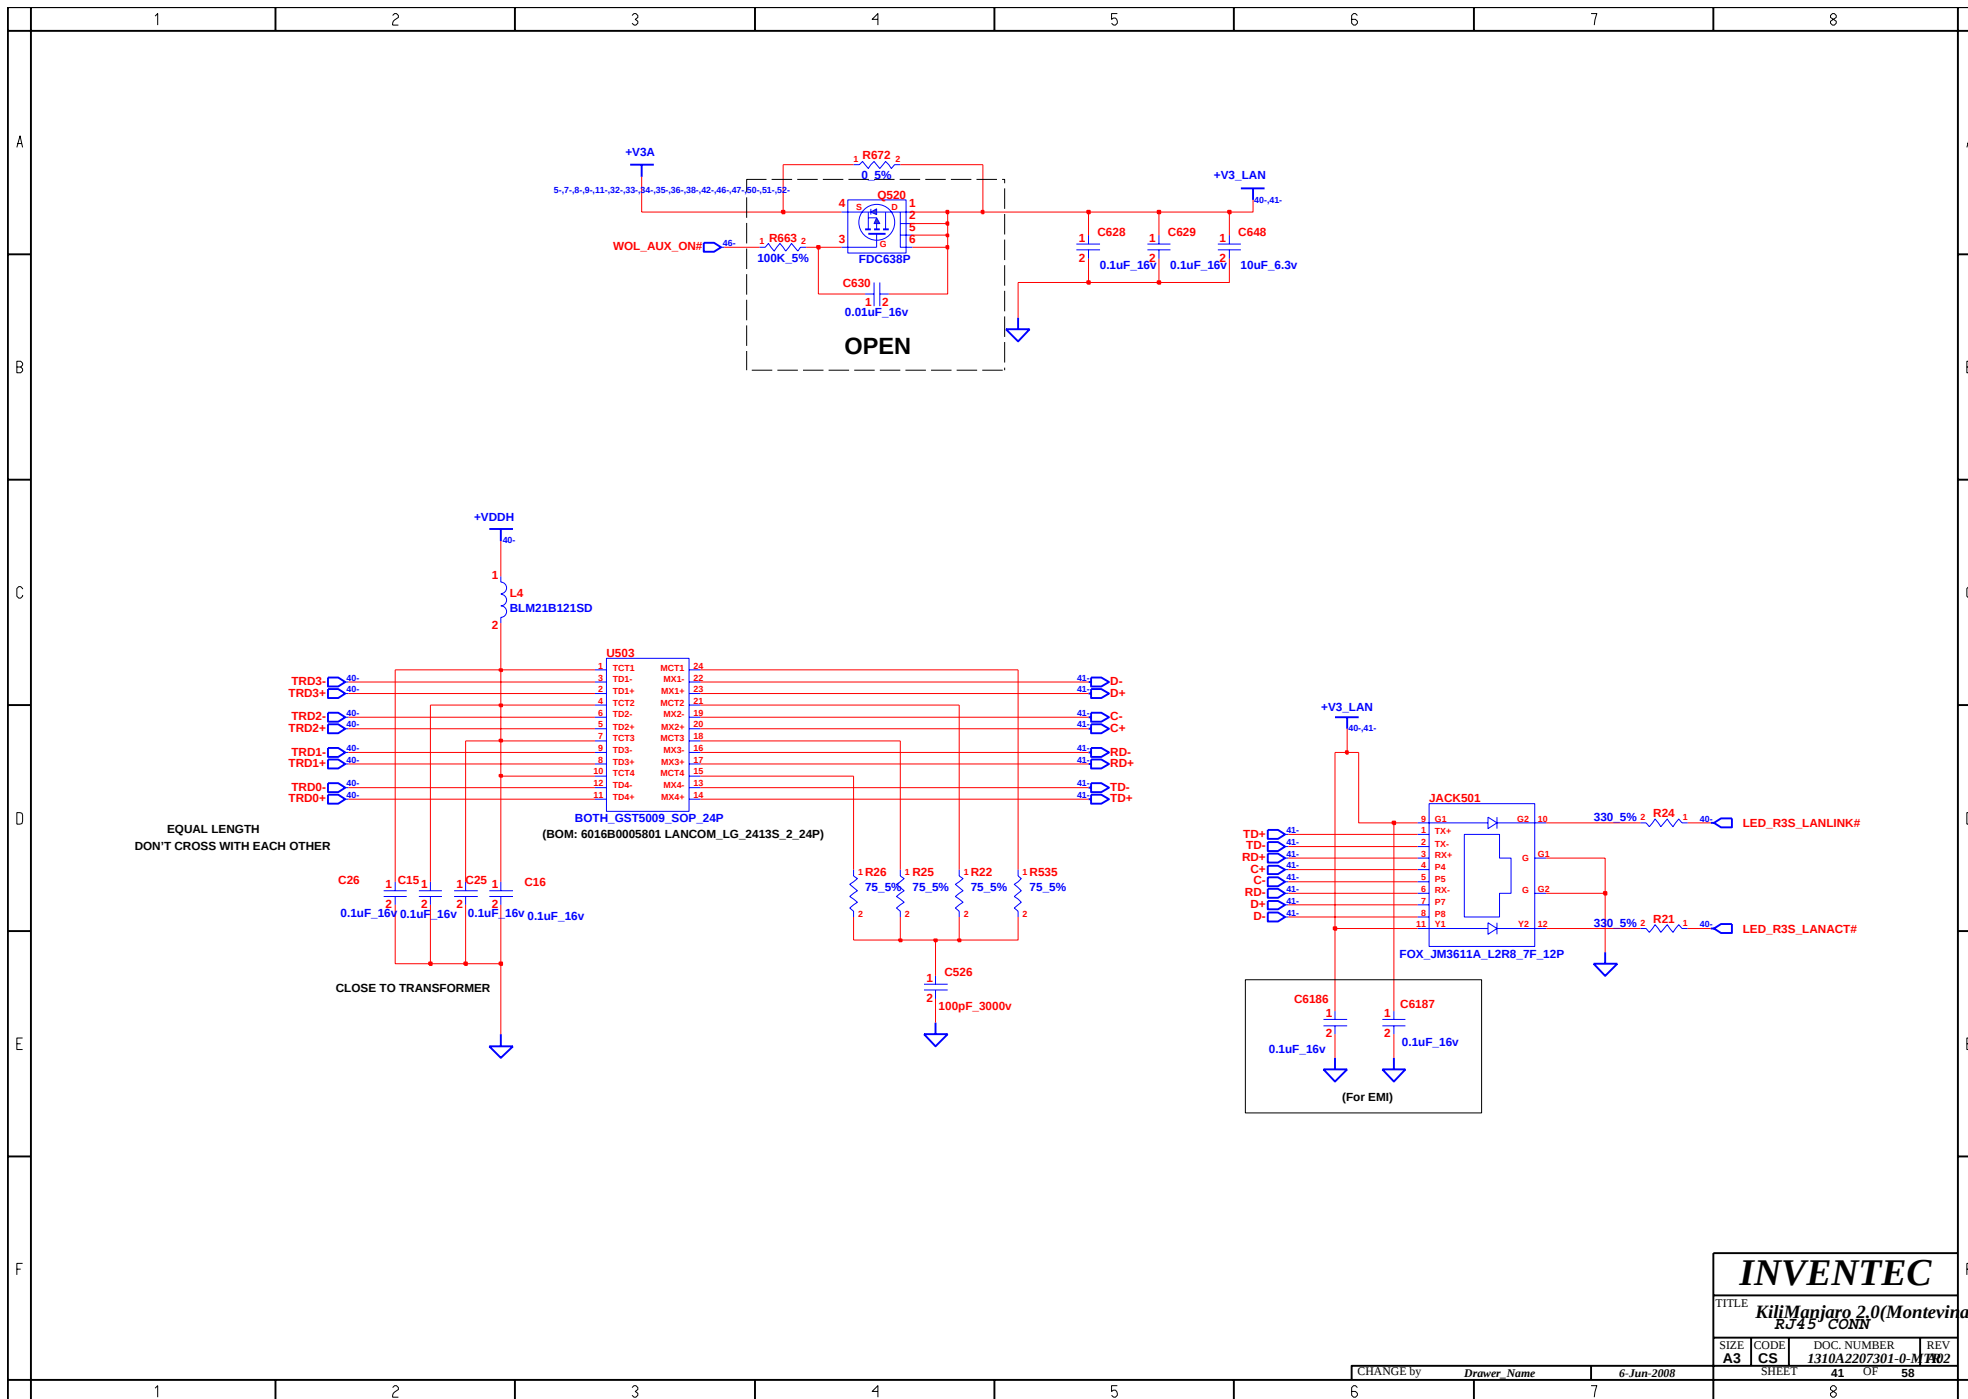



INVENTEC			
TITLE: KiliManjaro 2.0(Montevina) RJ45_CONN			
SIZE: A3	CODE: CS	DOC. NUMBER: 1310A2207301-0-M	REV: 02
CHANGE by: Draiver Name		6-Jun-2008	
SHEET: 41		OF: 58	

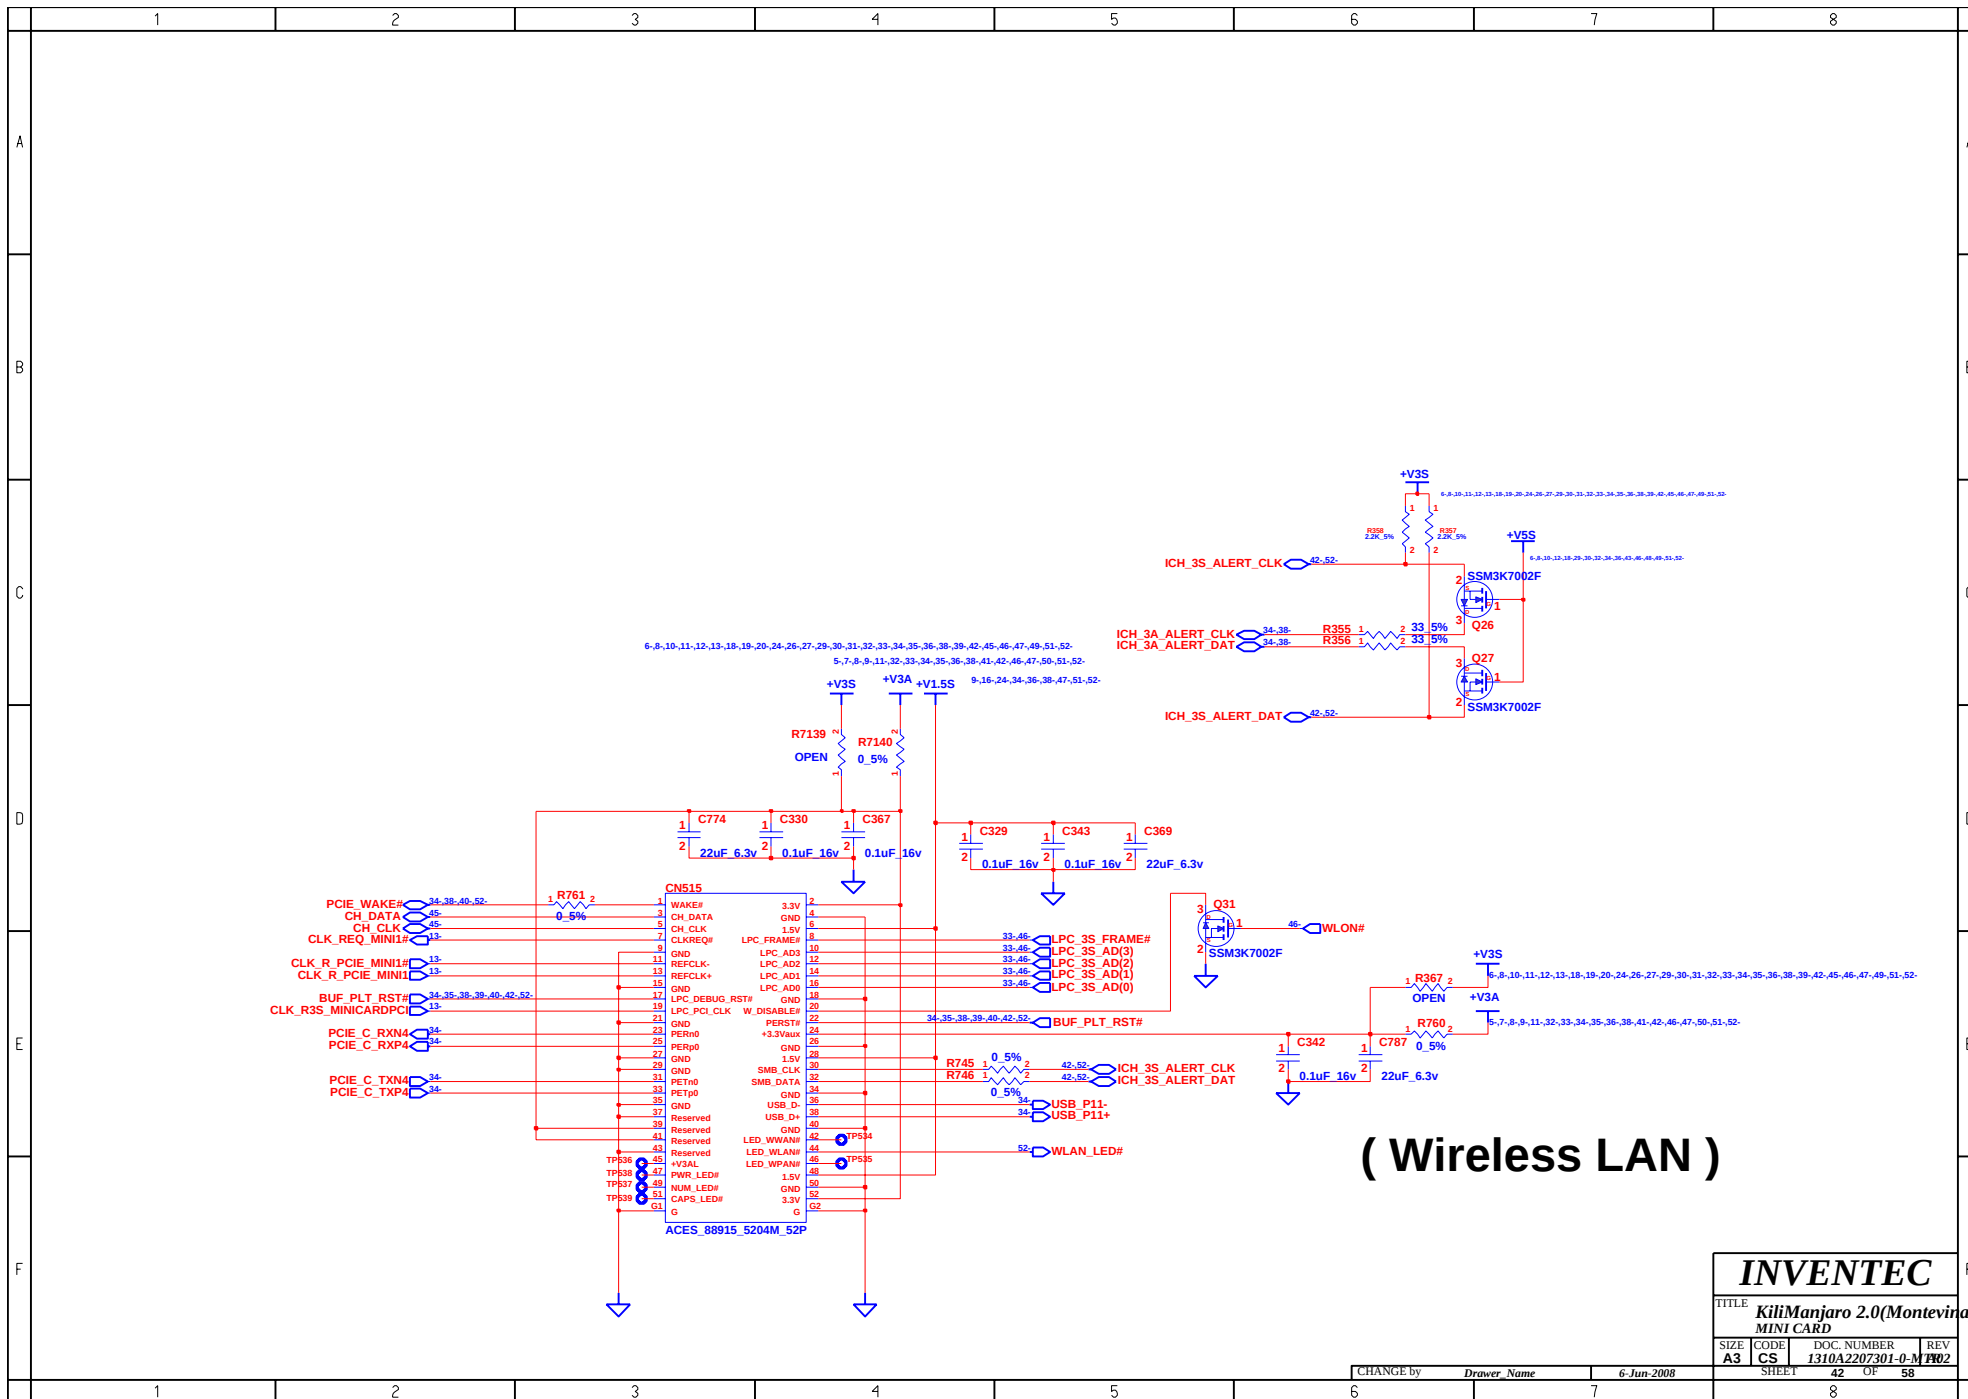



INVENTEC			
TITLE KiliManjaro 2.0(Montevina)			
MINI CARD			
SIZE A3	CODE CS	DOC. NUMBER 1310AZ207301-0-M	REV R02
CHANGE by Drawer Name		6-Jun-2008	
SHEET		42 OF 58	

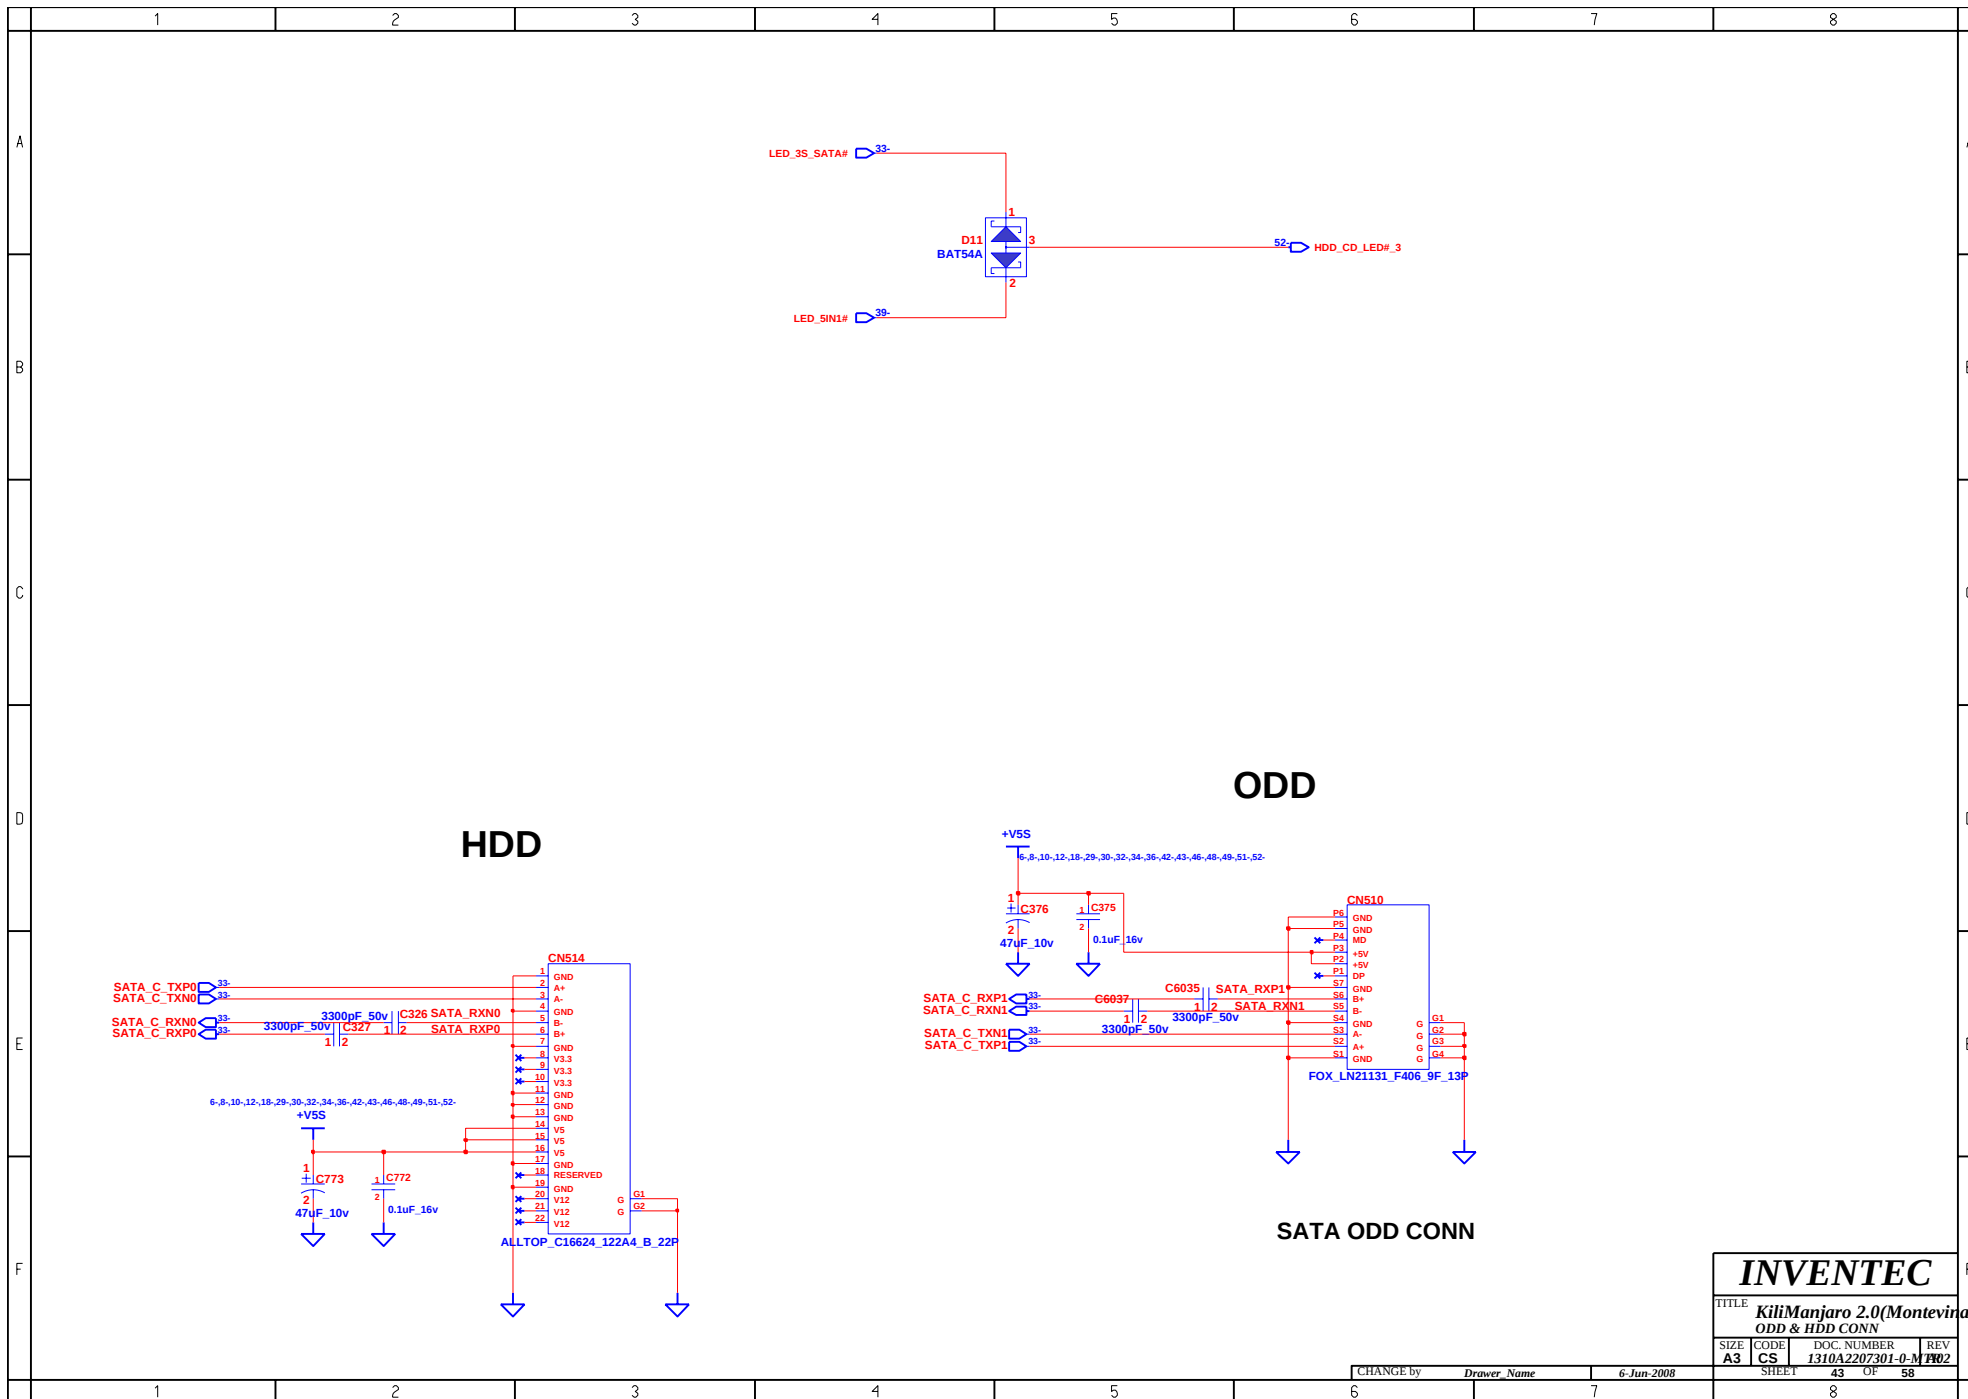


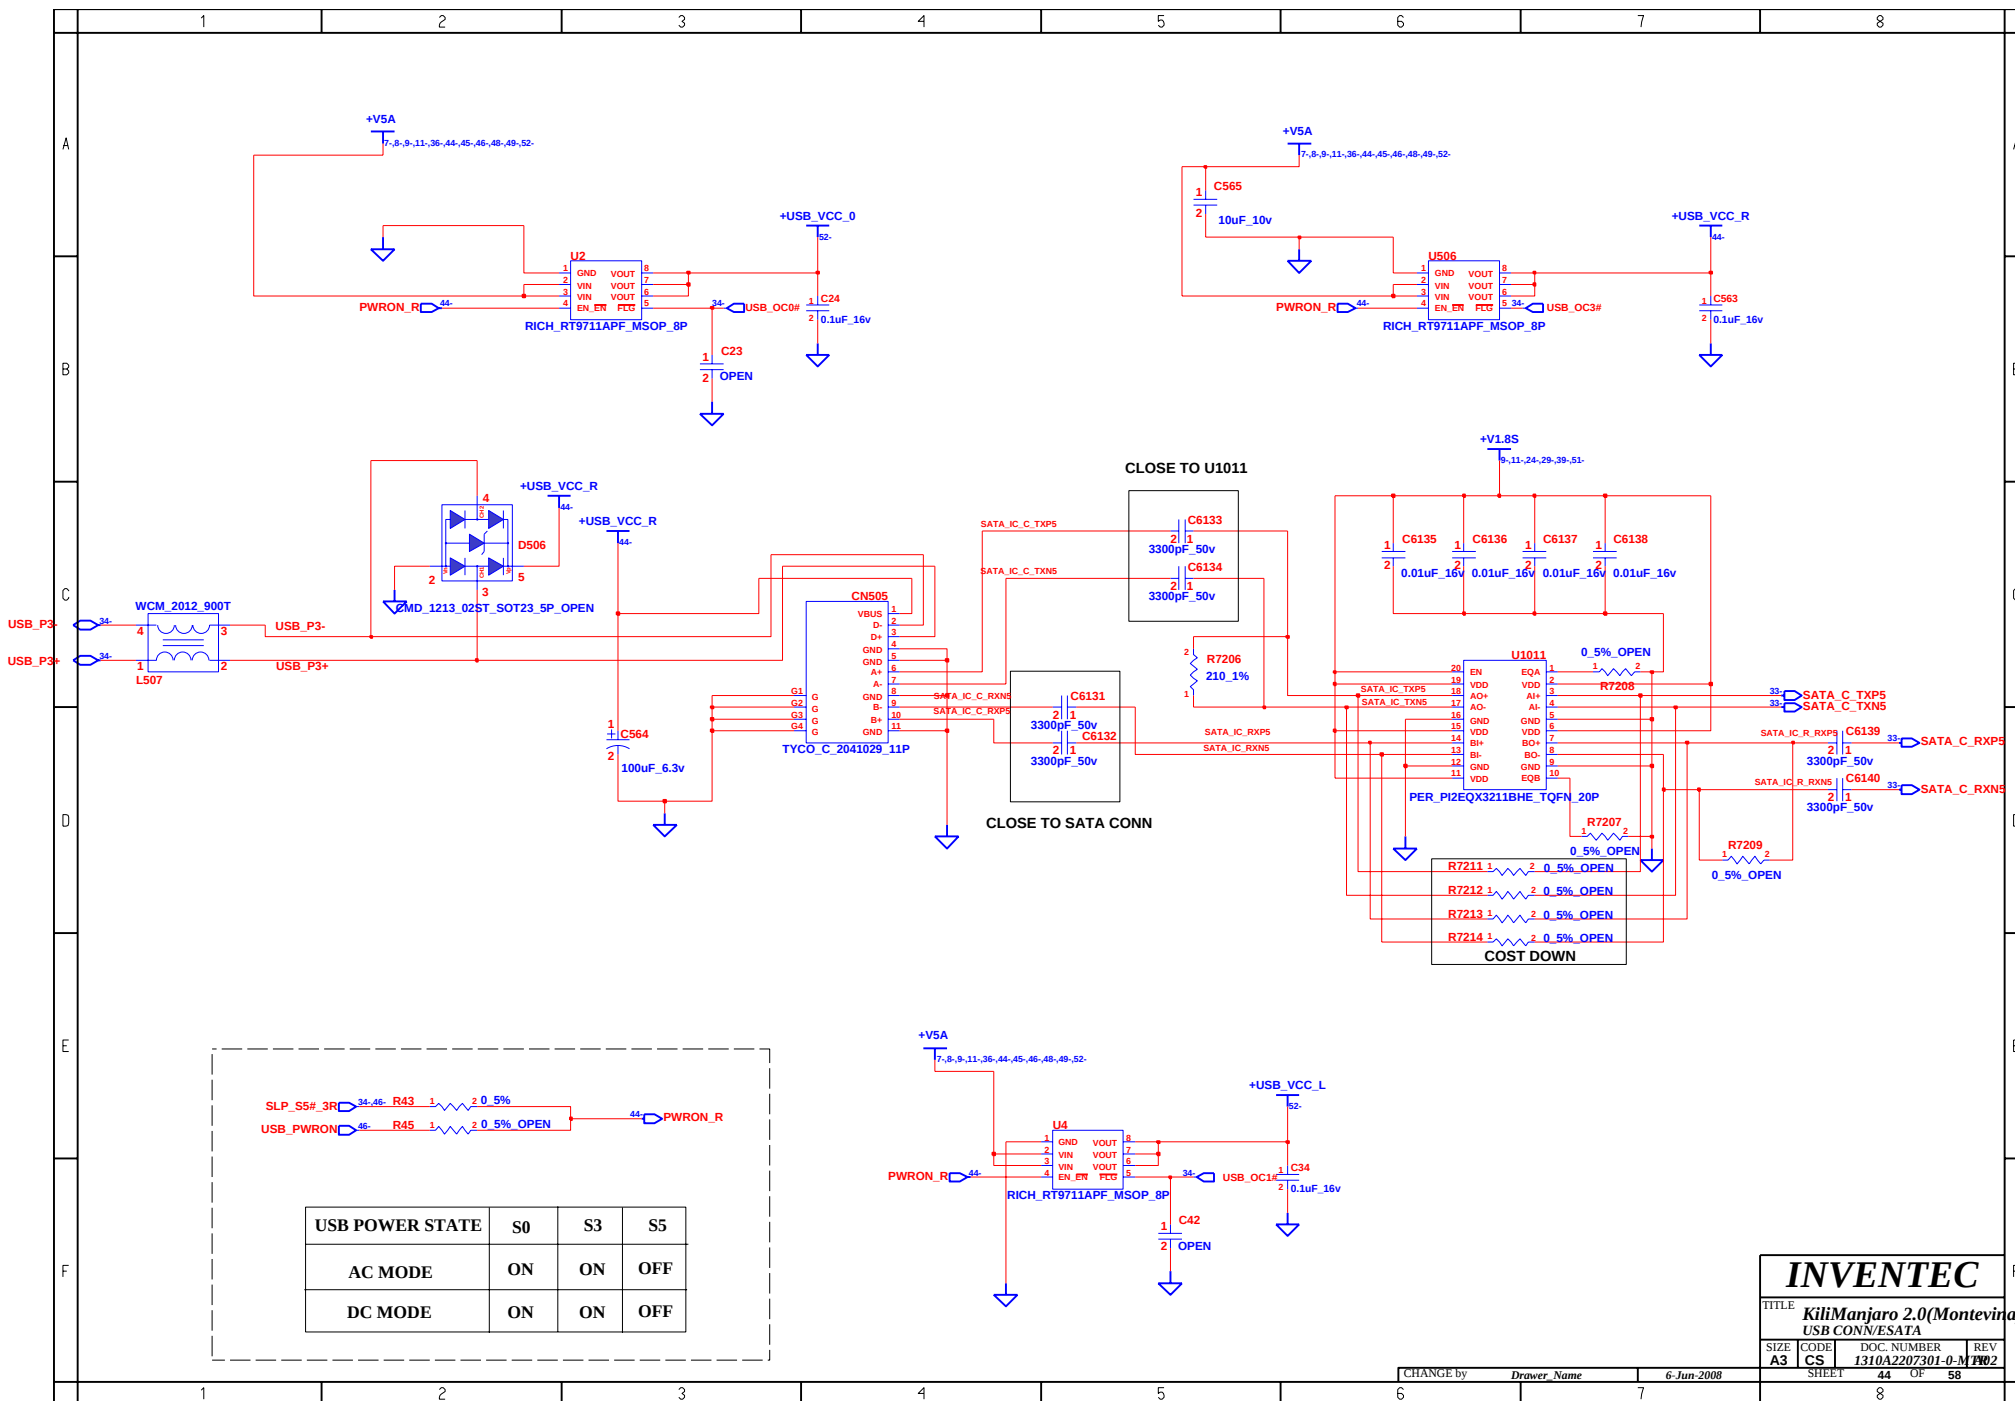


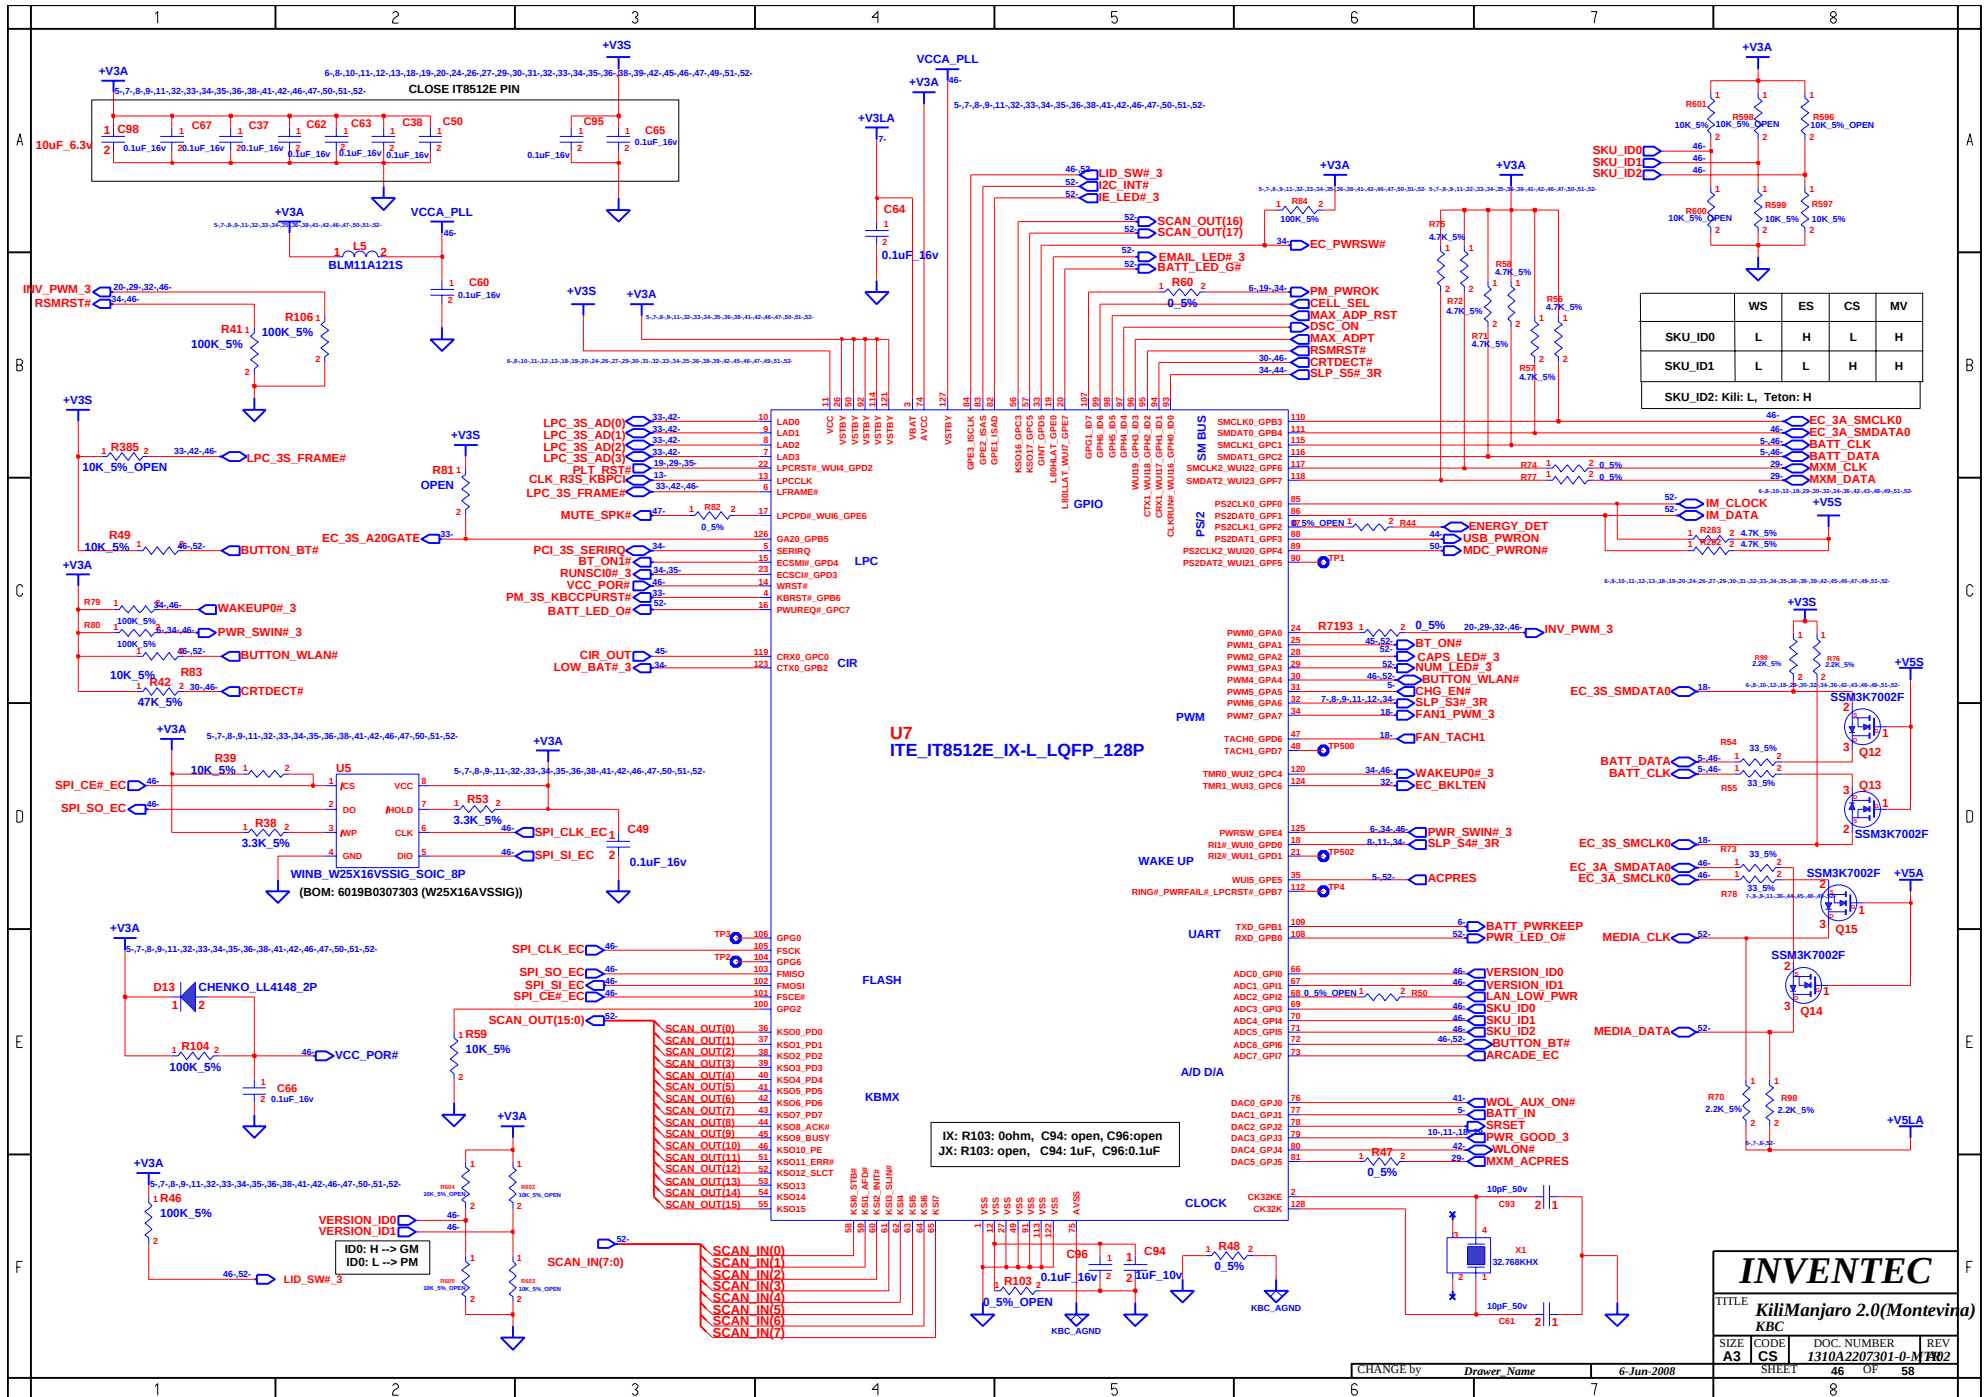

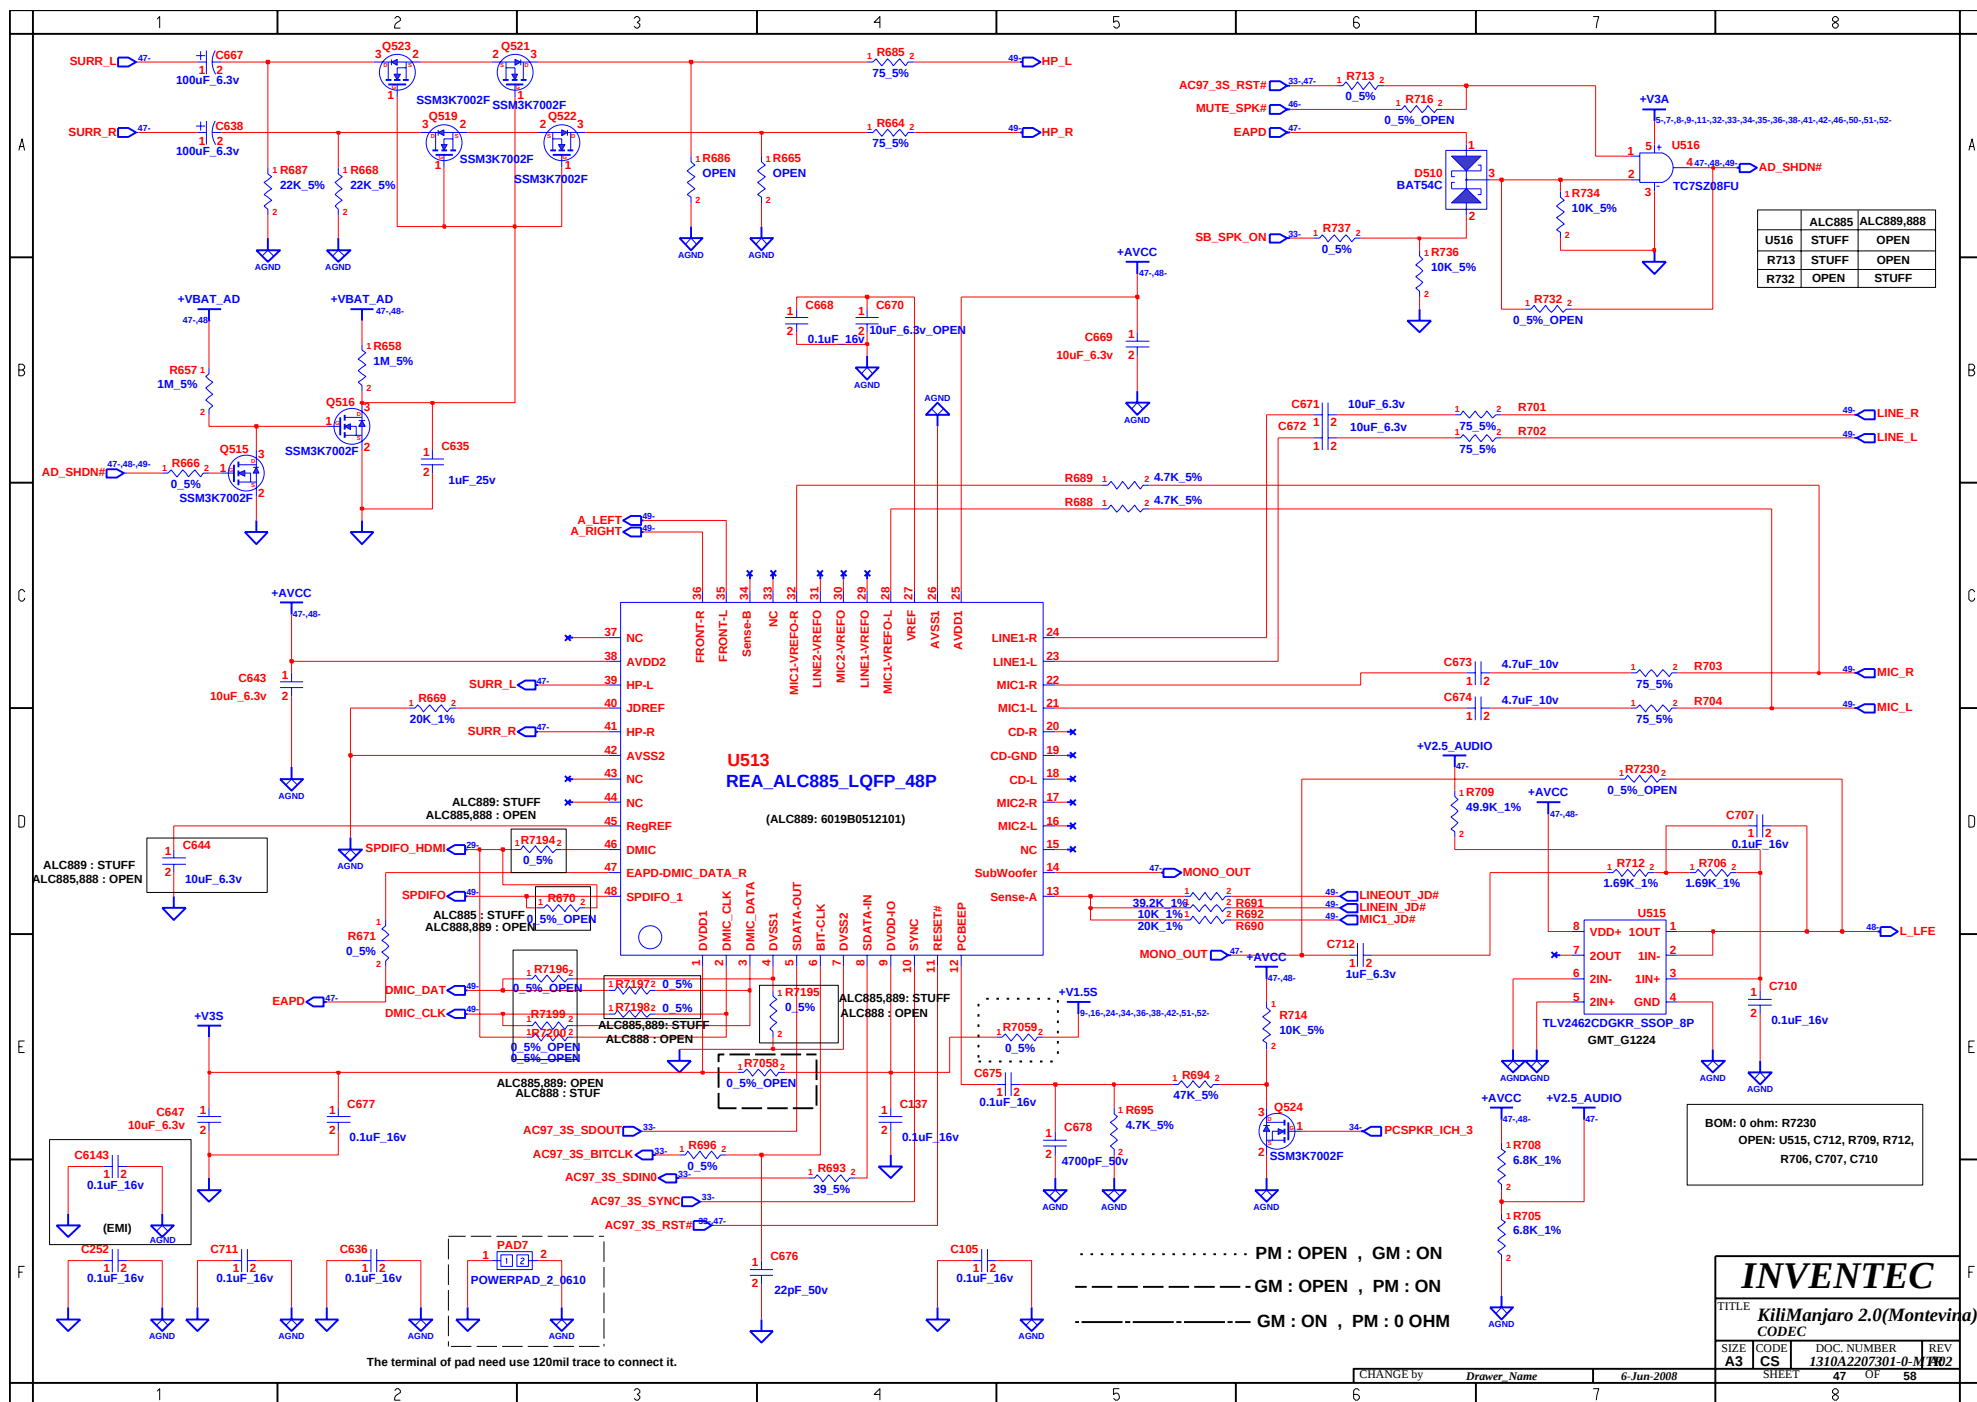


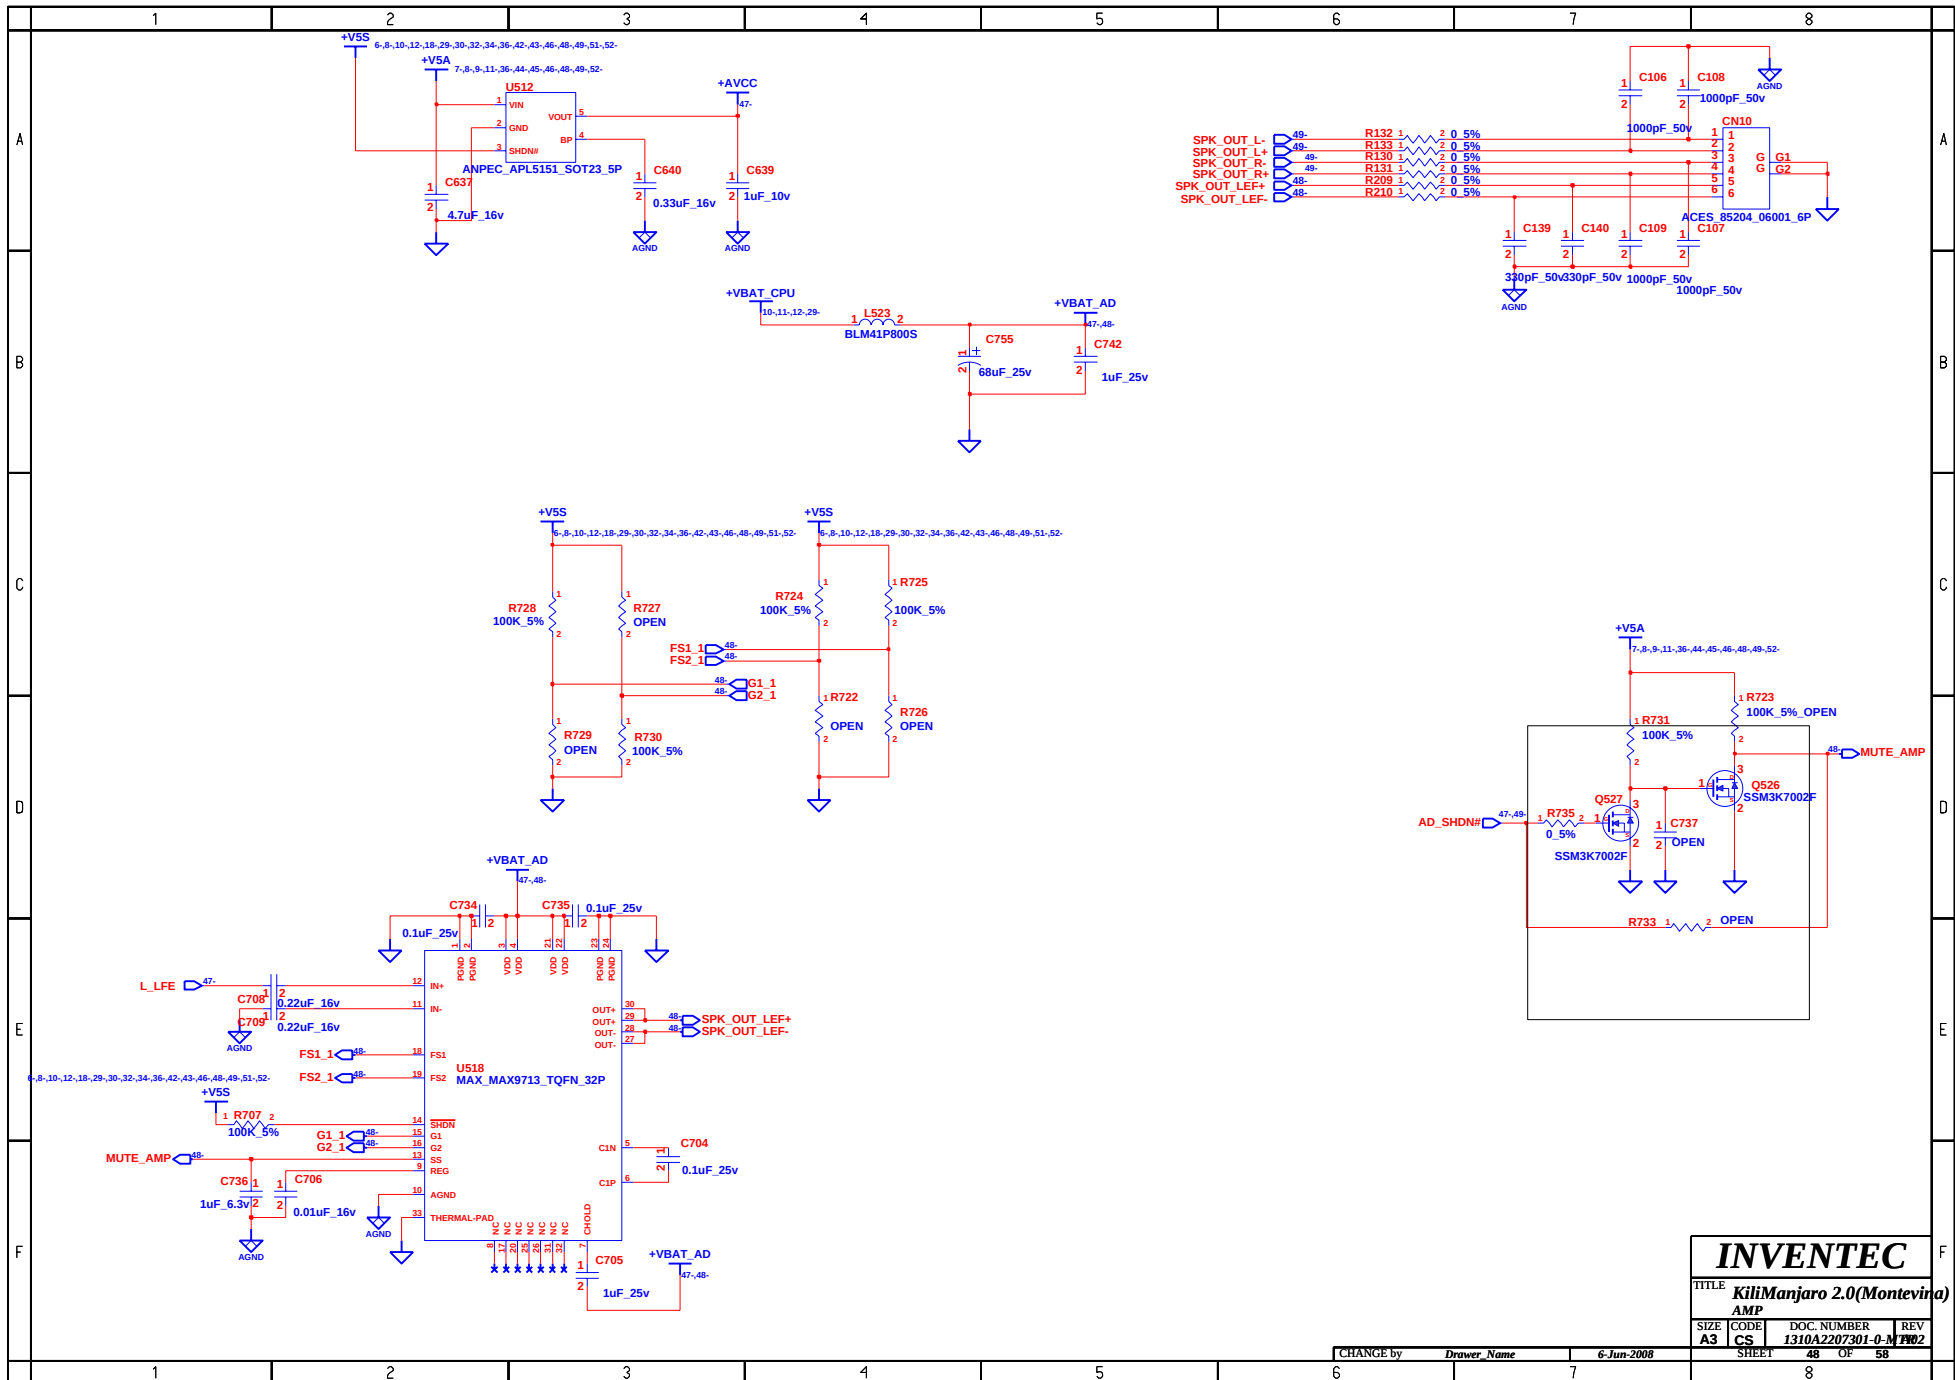


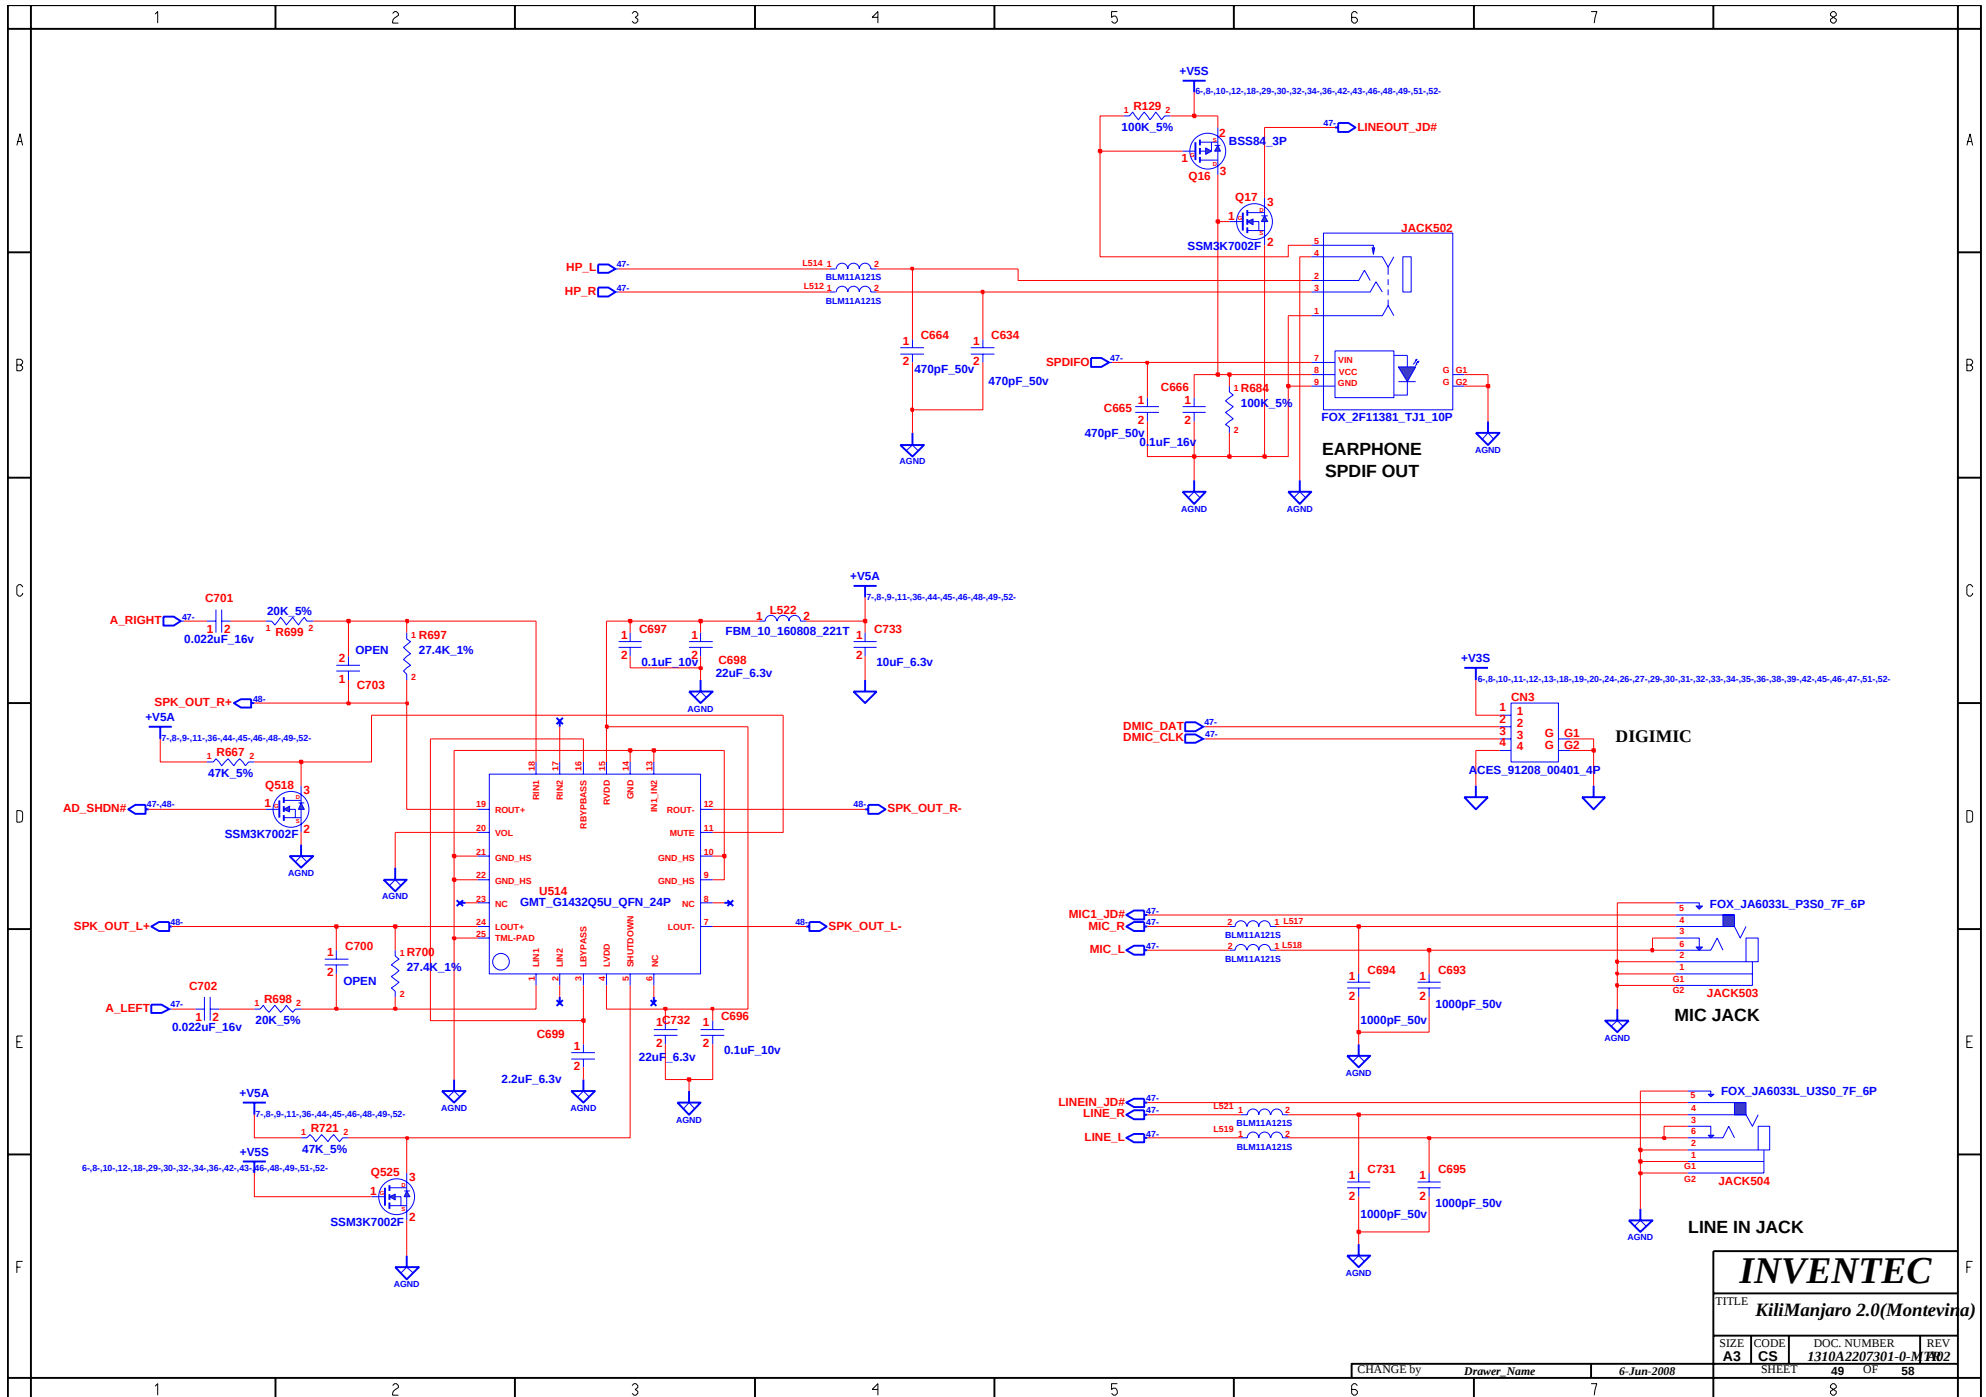



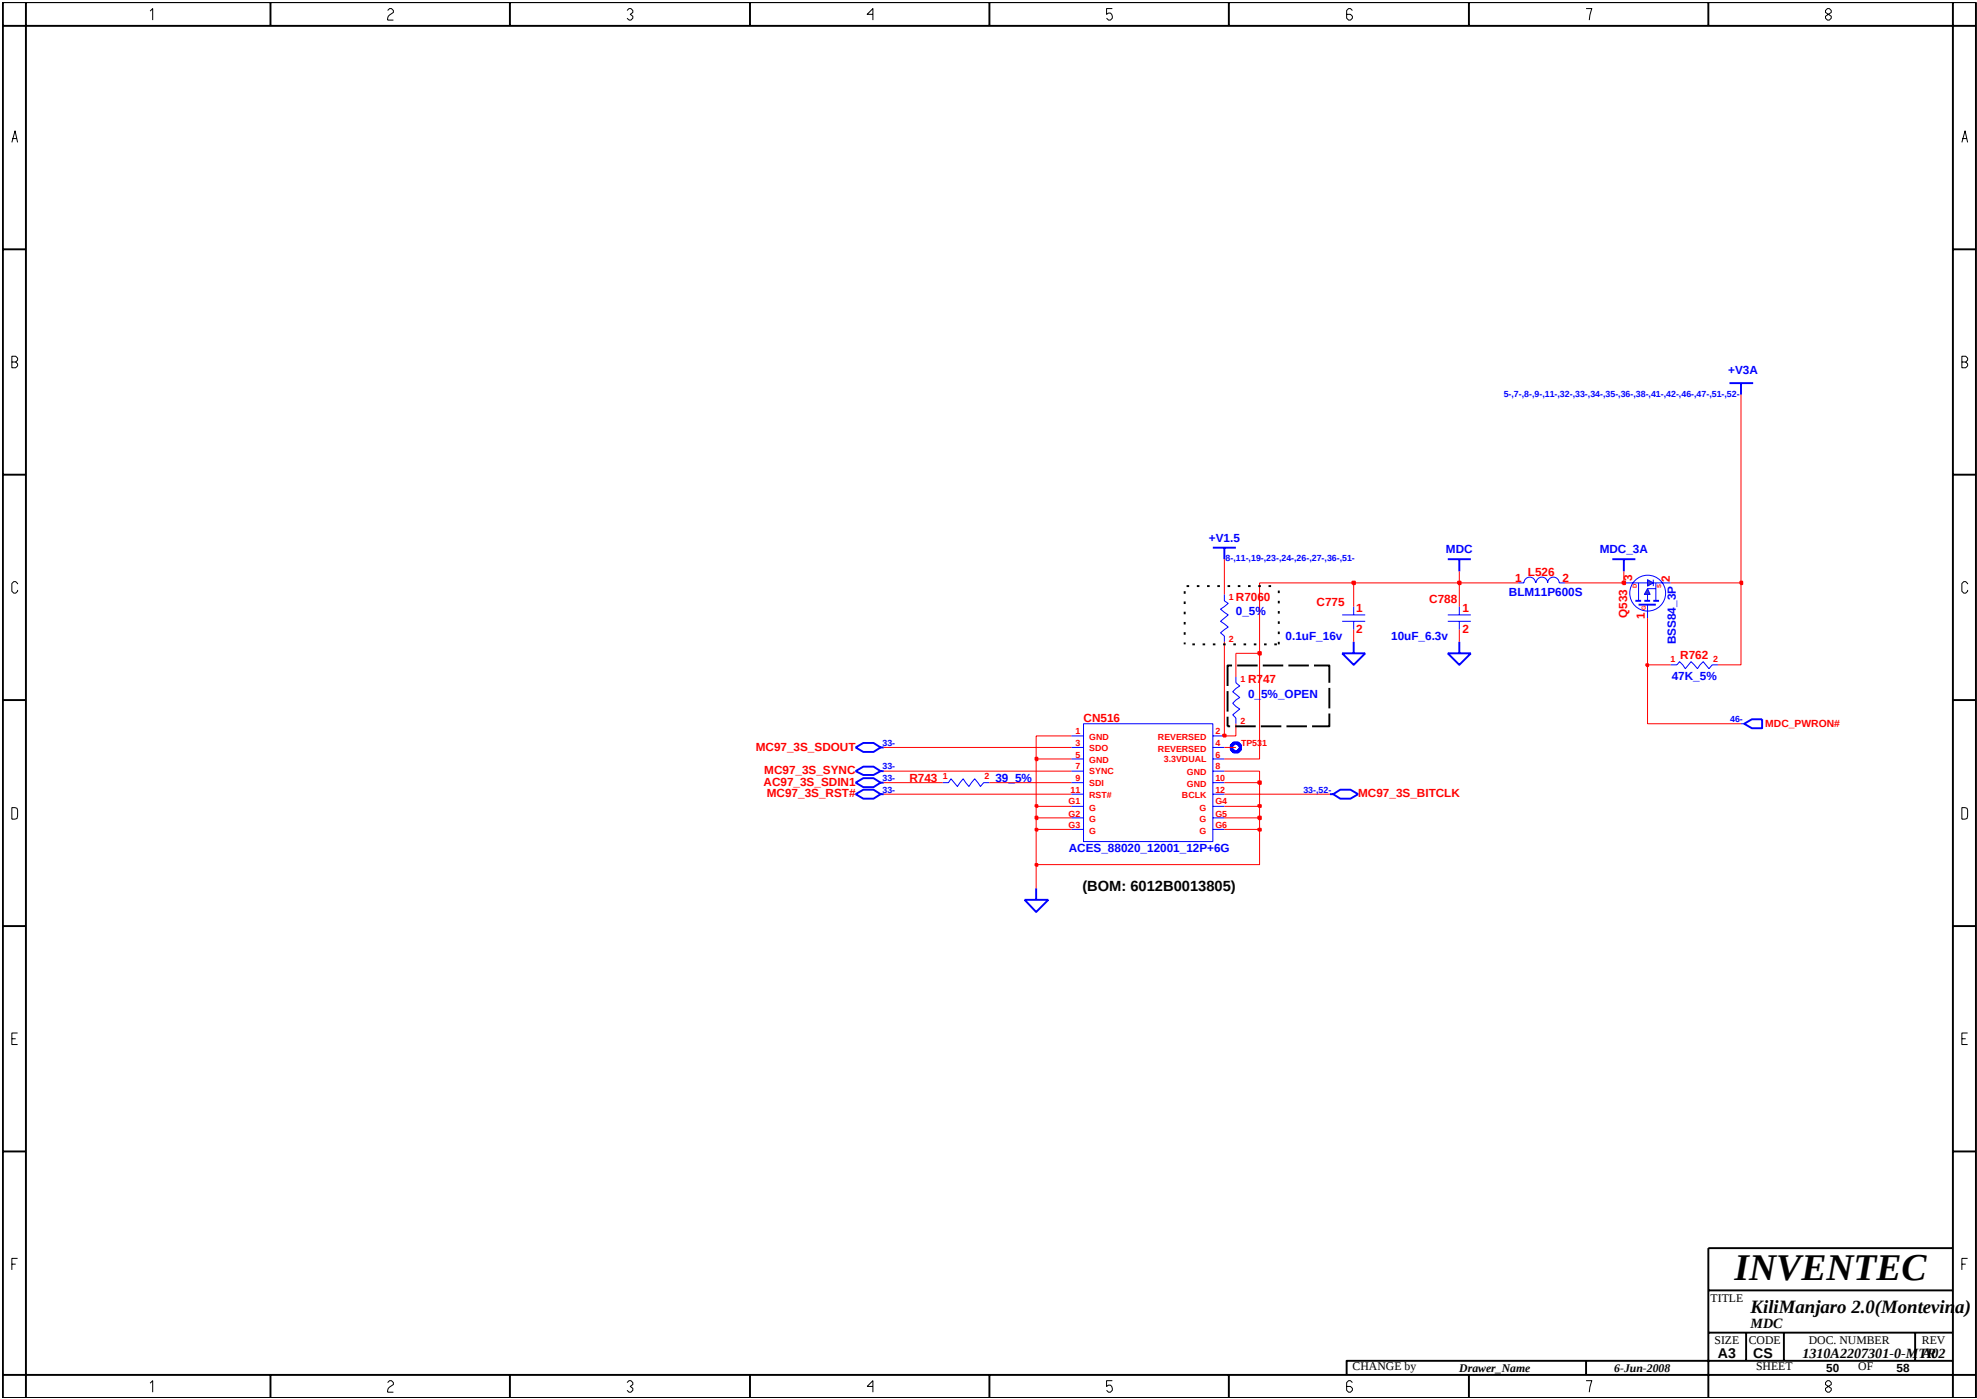


INVENTEC			
TITLE			
KiliManjaro 2.0(Montevina)			
MDC			
SIZE	CODE	DOC. NUMBER	REV
A3	CS	1310A2207301-0-M	02
CHANGE by		6-Jun-2008	
DRAWN by			
SHEET		50	OF 58
		8	

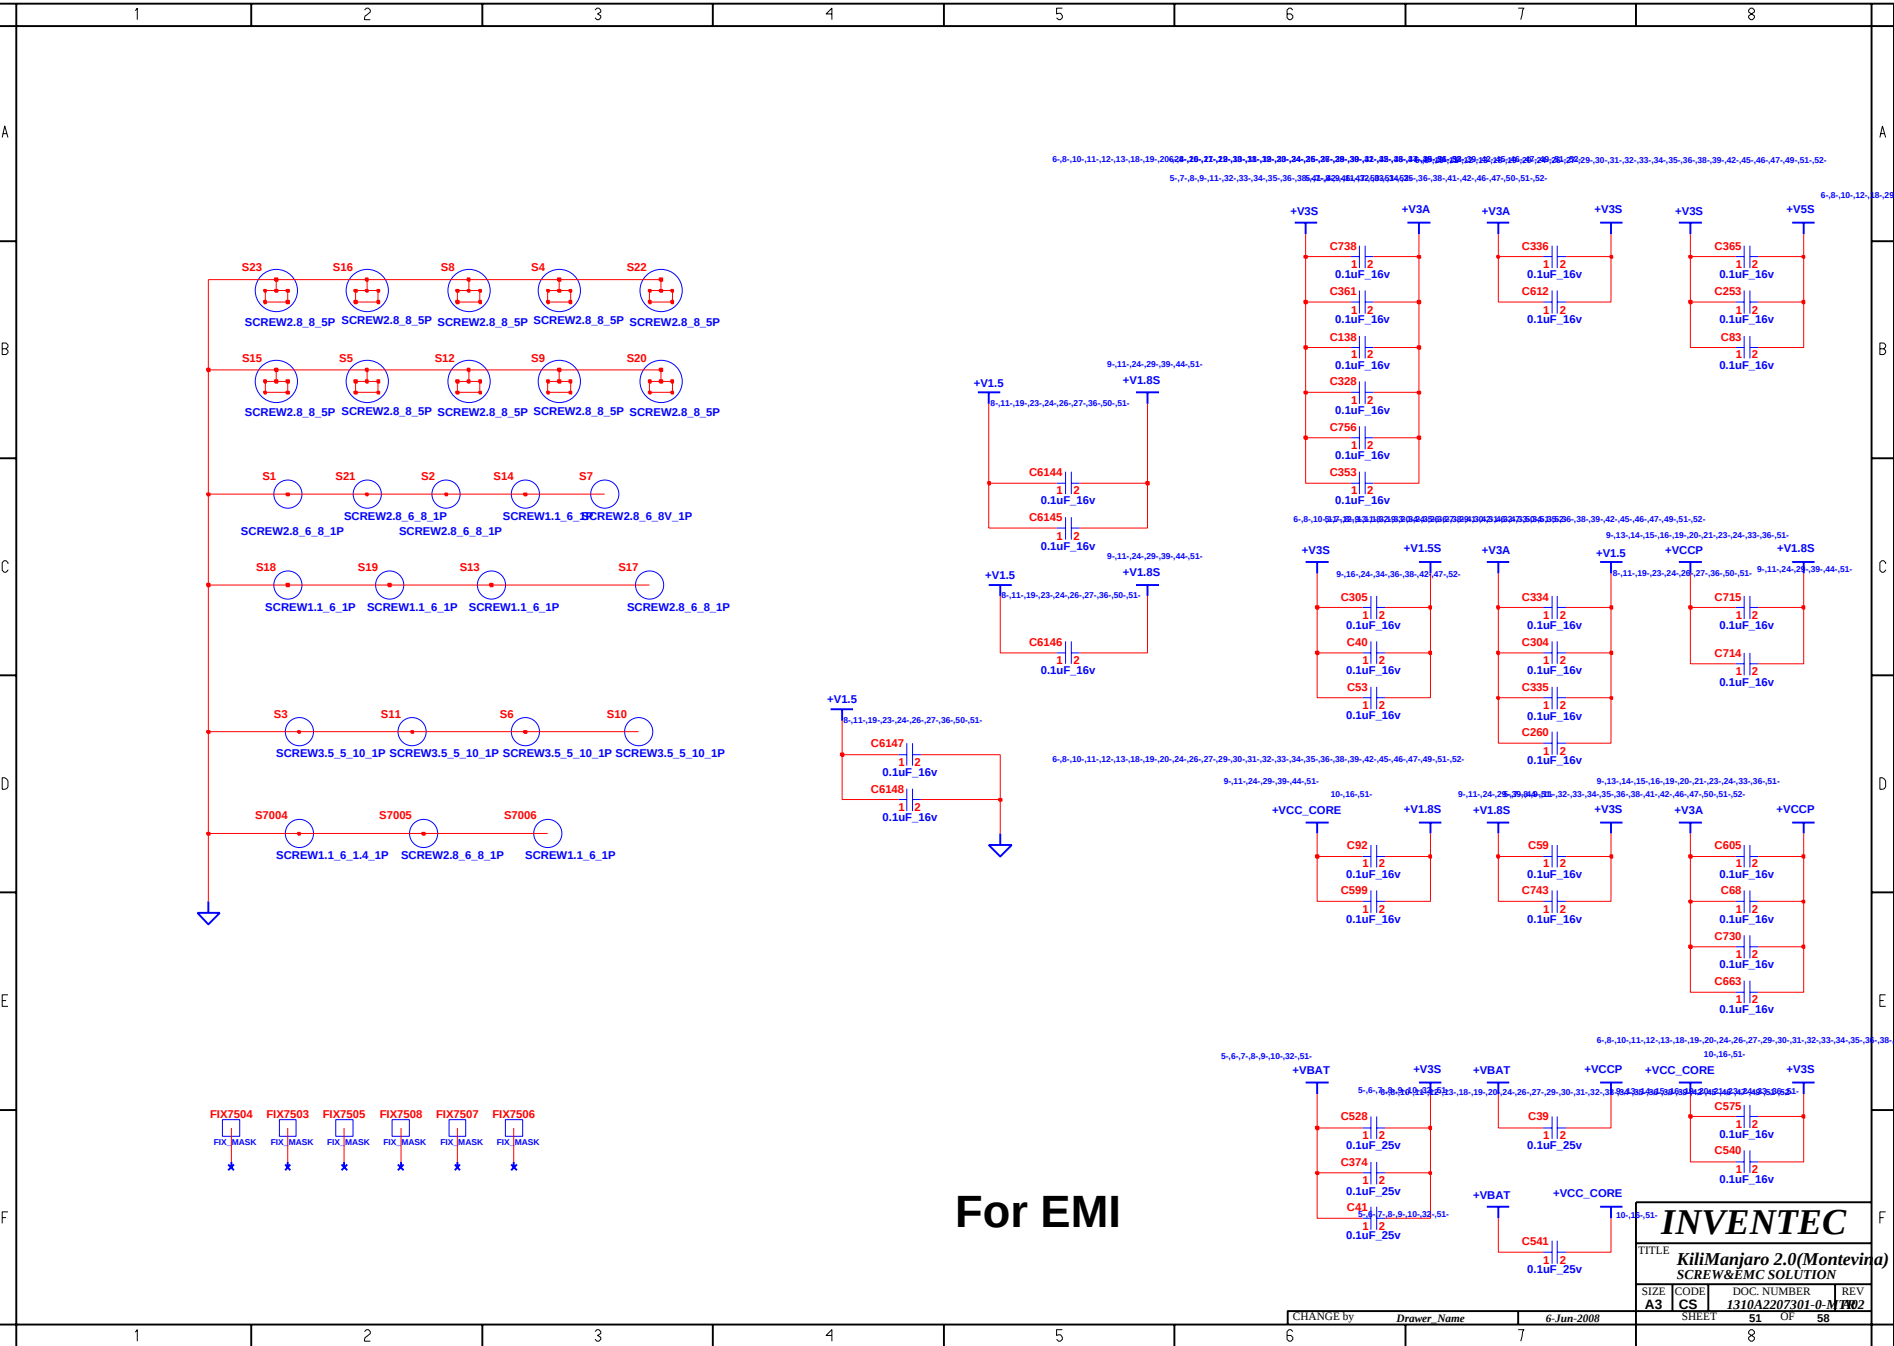

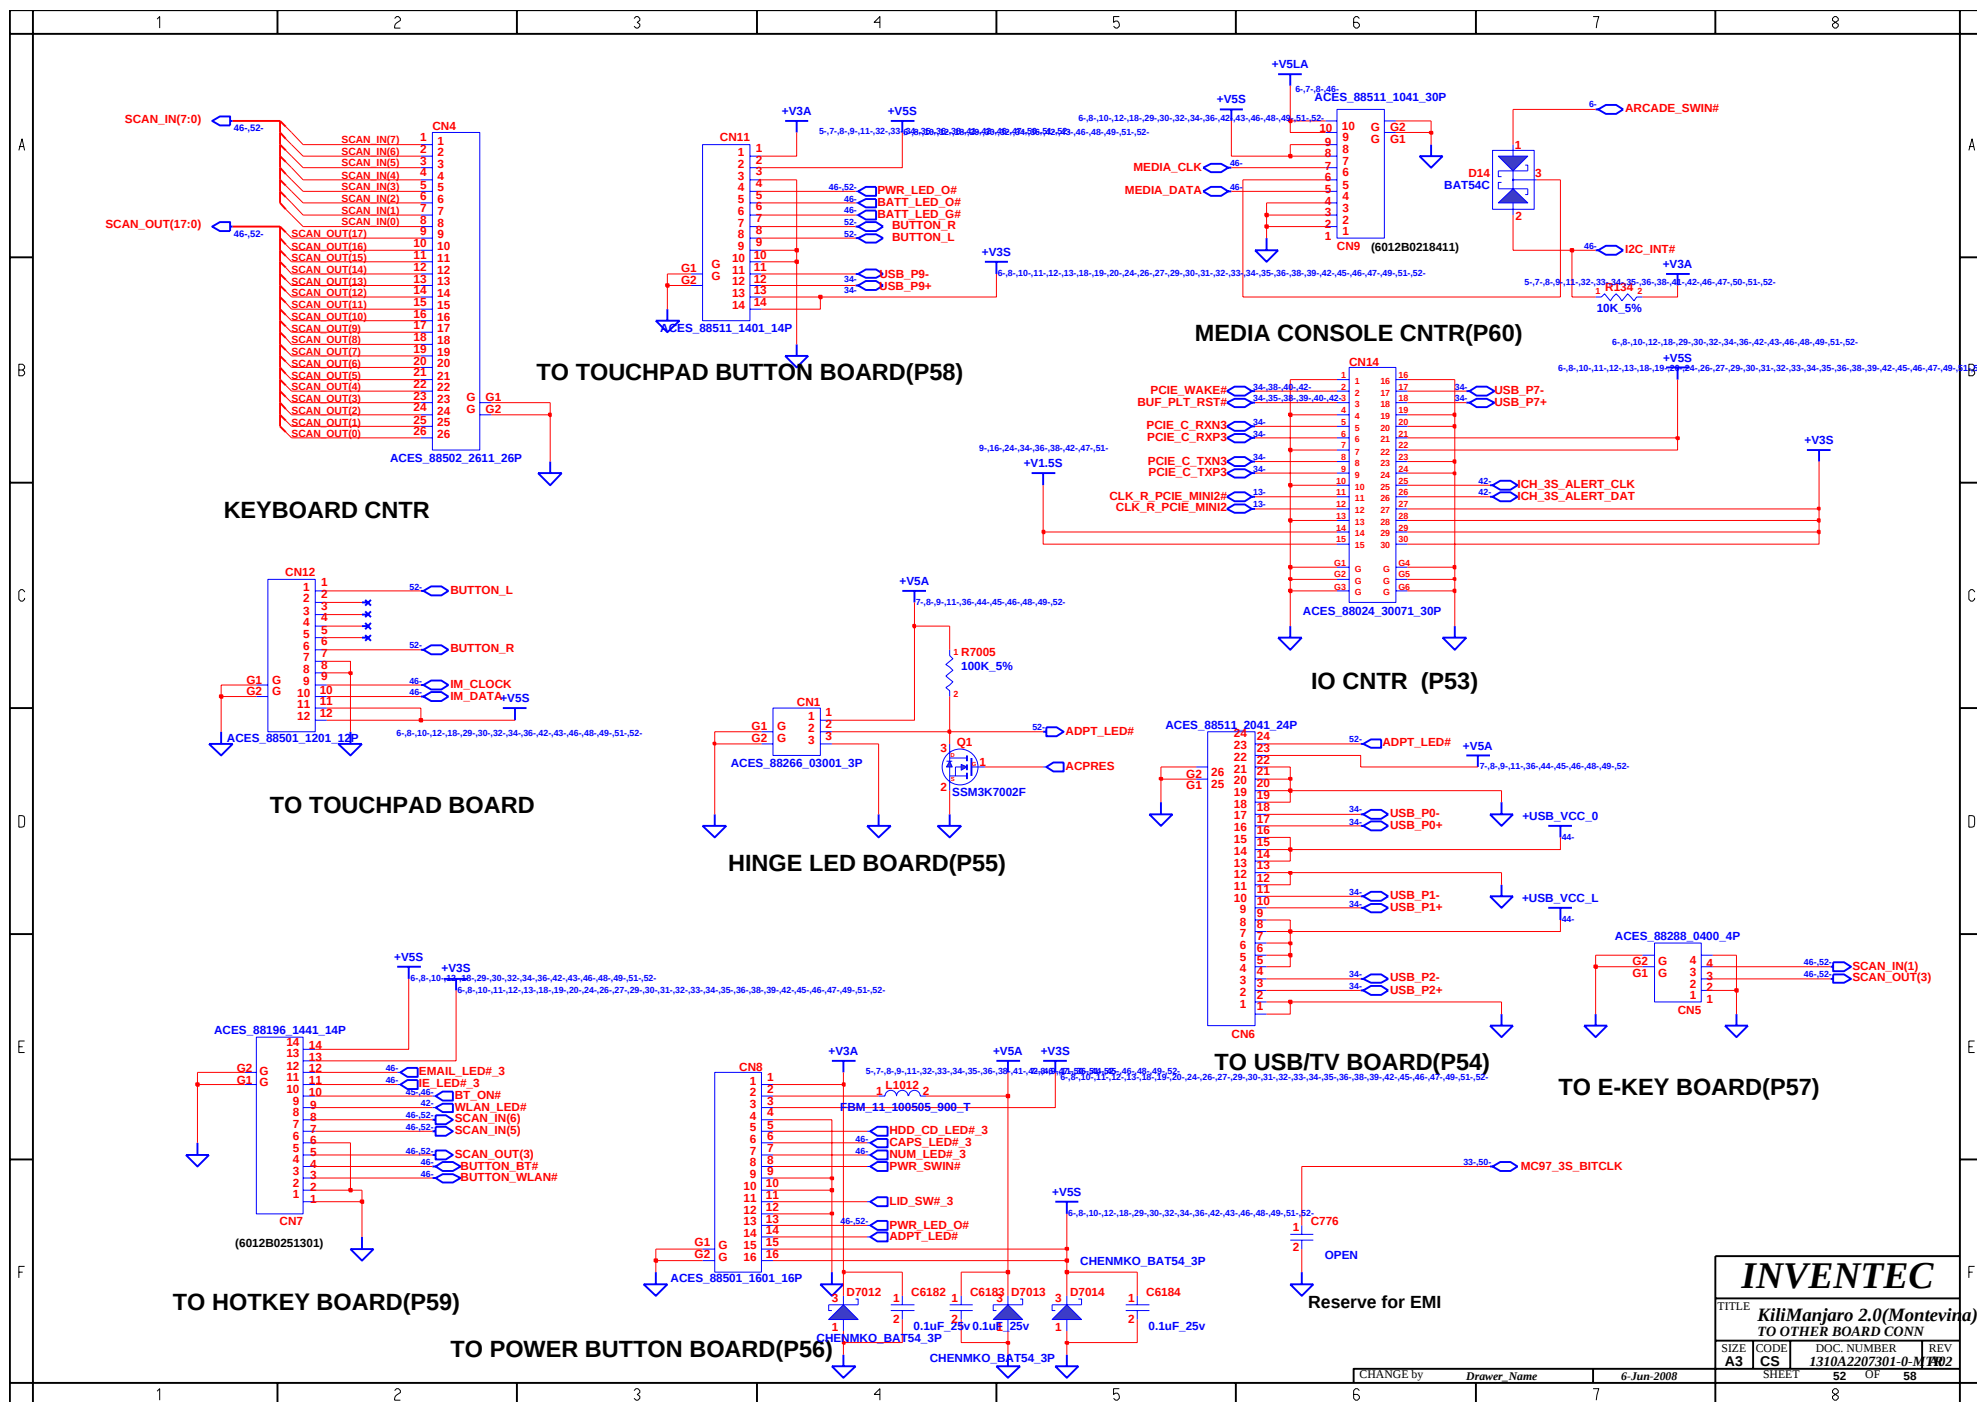

IO BOARD

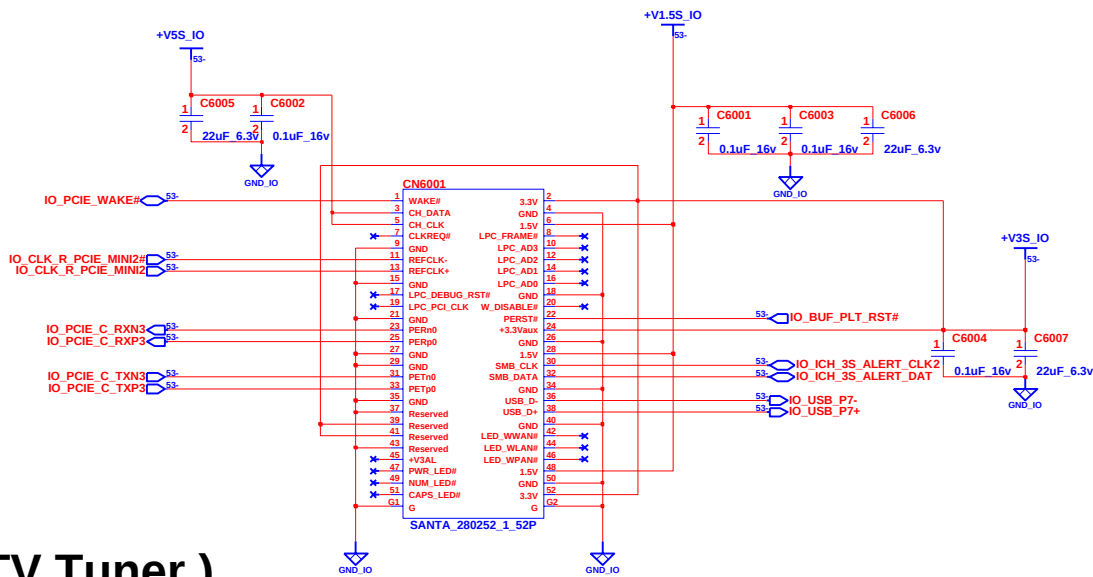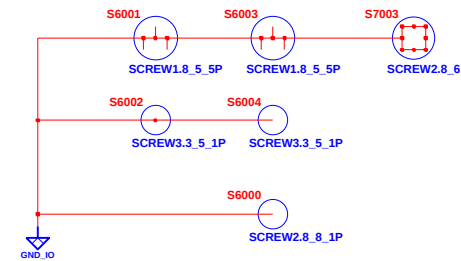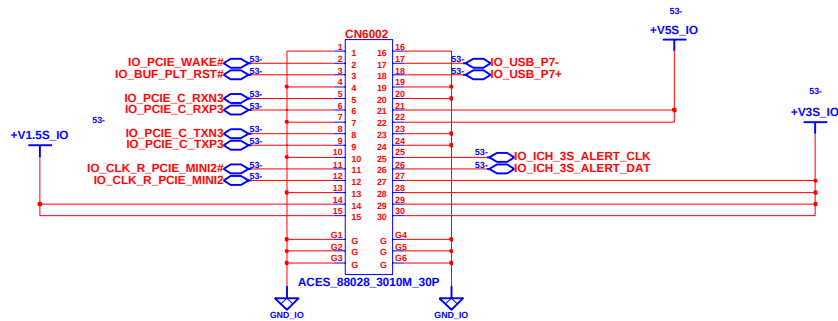


(TV Tuner)




INVENTEC			
TITLE KiliManjaro 2.0(Montevina)			
MEDIA BOARD			
SIZE A3	CODE CS	DOC. NUMBER 1310A2207301-0-M	REV 102
SHEET 53		OF 58	

CHANGE by Drawer Name 6-Jun-2008

USB & TV BOARD

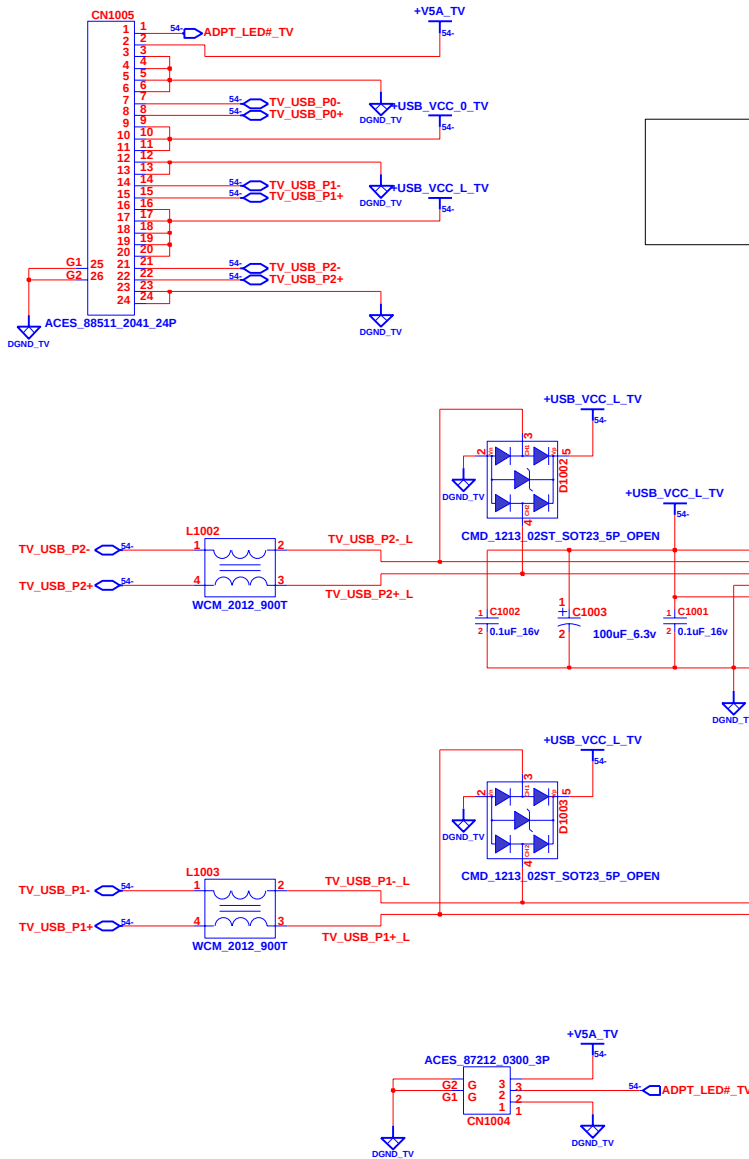


TV ANT

 


INVENTEC			
TITLE KiliManjaro 2.0(Montevina) USB & TV BOARD			
SIZE A3	CODE CS	DOC. NUMBER 1310A2207301-0-M	REV P02
SHEET 54		OF 58	

CHANGE by *Drawn Name* 6-Jun-2008

HINGE LED Board 1

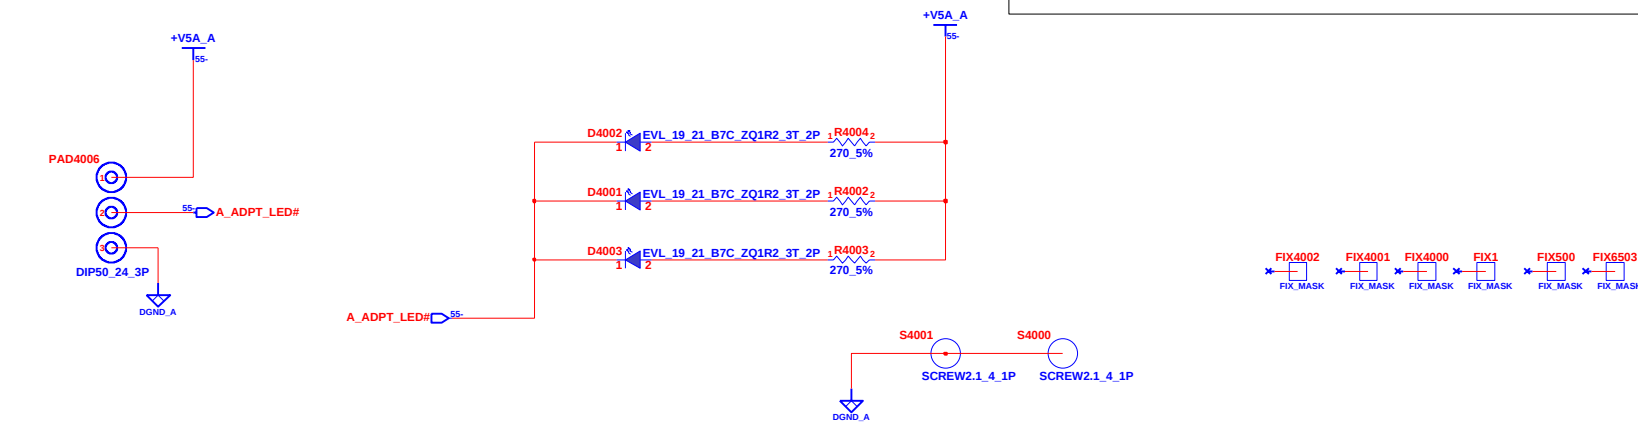

HINGE LED Board 2

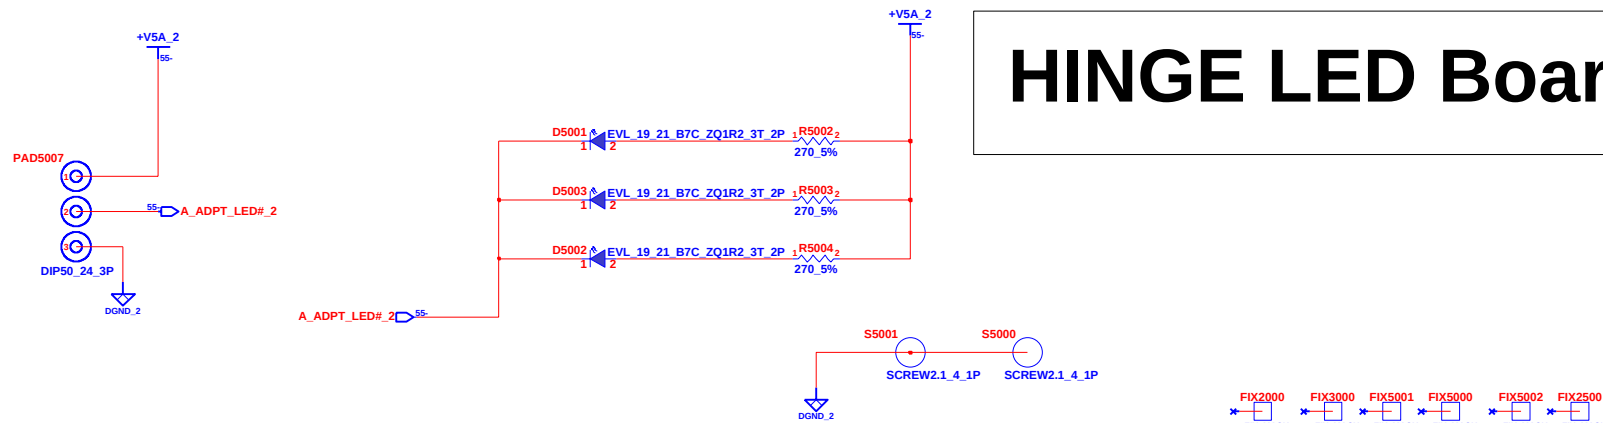

INVENTEC



TITLE
KiliManjaro 2.0(Montevina)
PowerJack BOARD

SIZE A3	CODE CS	DOC. NUMBER 1310A2207301-0-M	REV 02
-------------------	-------------------	--	------------------

CHANGE by *Drawn Name* 6-Jun-2008

SHEET 55 OF 58

PowerButton Board

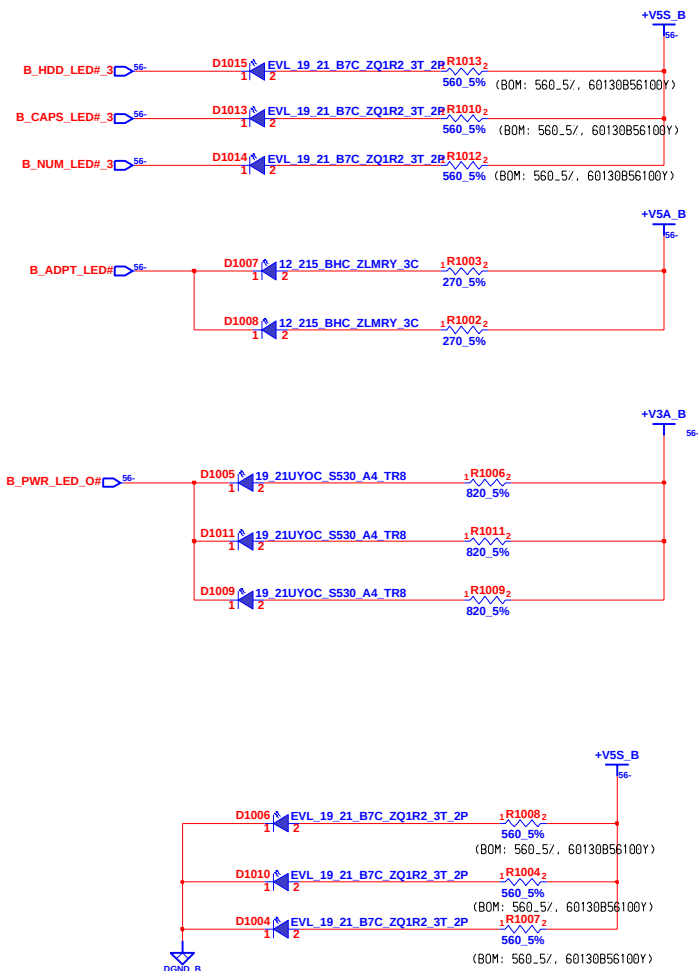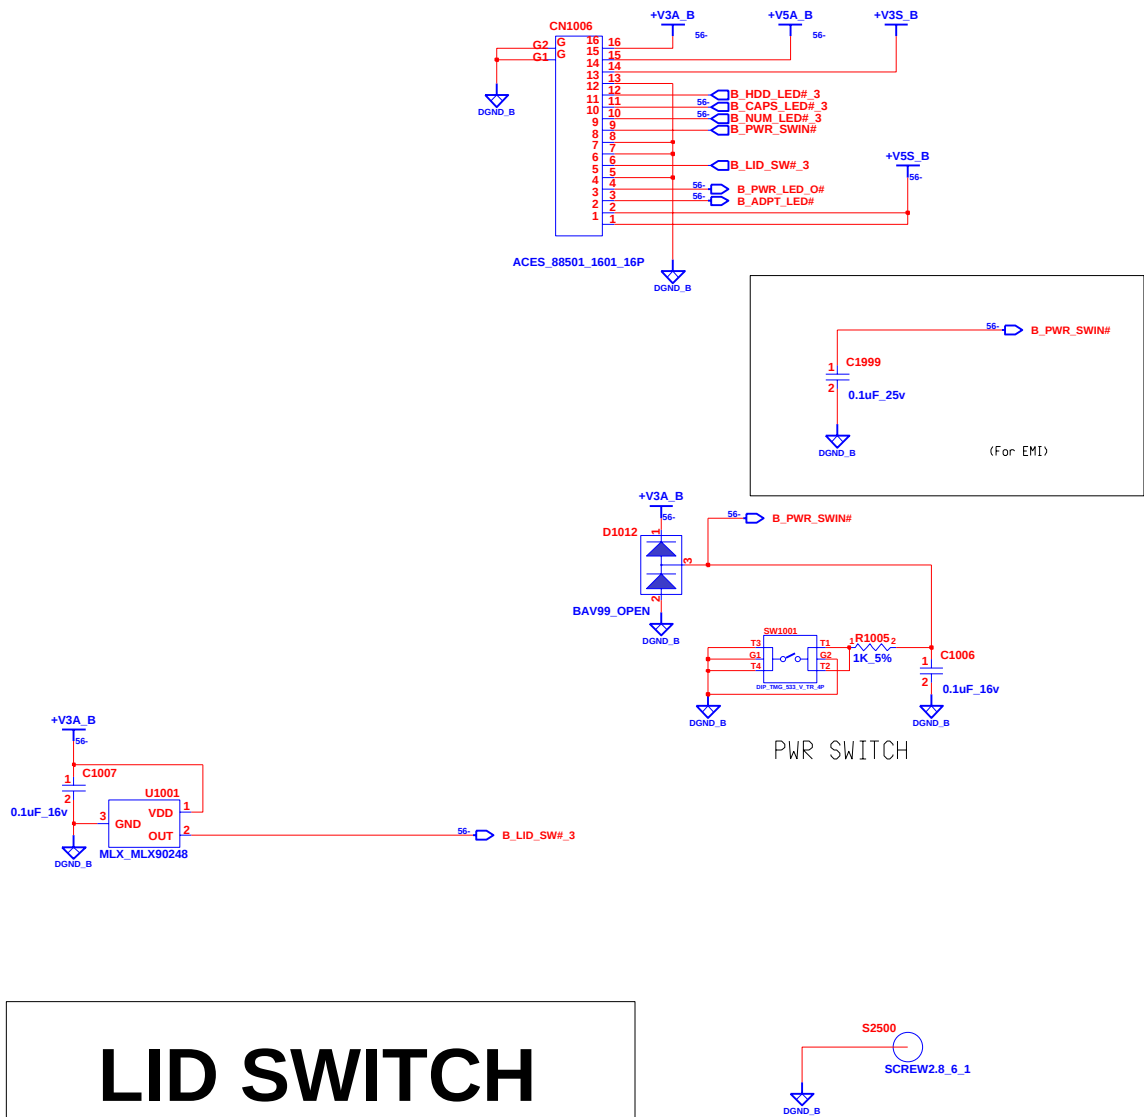

LID SWITCH

INVENTEC			
TITLE KiliManjaro 2.0(Montevina) PowerButton Board			
SIZE A3	CODE CS	DOC. NUMBER 1310A2207301-0-M	REV R02
SHEET 56		OF 58	

FIX2502	FIX2501	FIX2503	FIX2003	FIX2001	FIX2002
FIX MASK	FIX MASK	FIX MASK	FIX MASK	FIX MASK	FIX MASK

CHANGE by	Drawn Name	6-Jun-2008
-----------	------------	------------

E-KEY Board

The schematic diagram illustrates the electrical layout of the E-KEY Board. It includes the following components and connections:

- ACES_88288_0400_4P**: A 4-pin connector with pins 1, 2, 3, and 4. Pin 1 is connected to **EK_SCAN_IN(1)**, pin 2 to **EK_SCAN_OUT(3)**, pin 3 to **DGND_EK**, and pin 4 to **DGND_EK**.
- SW3001**: A switch with terminals T1, T2, T3, and T4. T1 is connected to **EK_SCAN_OUT(3)**, T2 to **DGND_EK**, T3 to **EK_SCAN_IN(1)**, and T4 to **DGND_EK**. The switch is labeled **(E BUTTTON)**.
- S3001** and **S3002**: Two screws. S3001 is connected to **DGND_EK** and S3002 to **SCREW1.4_4_1P**.
- FIX502**, **FIX3**, **FIX4**, **FIX3002**, **FIX3003**, and **FIX3001**: Six screws, each connected to a **FIX_MASK** component.

INVENTEC
TITLE: **KiliManjaro 2.0(Montevina)**
E-KEY BOARD
SIZE: **A3** CODE: **CS** DOC. NUMBER: **1310A2207301-0-M** REV: **PRO2**
CHANGE by: **Drawer_Name** 6-Jun-2008 SHEET: **57** OF: **58**

TITLE	<i>KiliManjaro 2.0(Montevina)</i> <i>E-KEY BOARD</i>
-------	---

SIZE A3	CODE CS	DOC. NUMBER 1310A2207301-0-MT102	REV 1
SHEET 57		OF 58	

CHANGE by	<i>Drawer_Name</i>	6-Jun-2008
-----------	--------------------	------------

